


- NOTE: 1. THE ELECTRICIAN SHALL INSTALL ADDITIONAL #12 WIRE TIE SUPPORTS FROM THE CEILING GRID TO THE STRUCTURE ABOVE FOR SUPPORT OF THE LIGHT FIXTURES CLIPPED ON THE GRID.
- NOTE: 2. LIGHT FIXTURES, SECURITY CAMERA DOMES, AND MIRROR PANELS (UON) ARE DOLLAR TREE SUPPLIED.
- NOTE: 3. MOUNT LIGHTS 10'-0" AFF IN STOCKROOM.

REFLECTED CEILING LEGEND

- 2'-0"X4'-0" ACOUSTICAL CEILING TILE AND GRID- SEE FINISH NOTE 11.
- GWB - PAINT WHITE UNLESS OTHERWISE NOTED.
- 8'-0" STRIP LED LIGHT FIXTURE WITH LAMPS ON NIGHT LIGHT CIRCUIT. SURFACE MOUNT TO GWB AND ACT CEILING.
- 8'-0" STRIP LED LIGHT FIXTURE. SURFACE MOUNT TO GWB AND ACT CEILING.
- 8'-0" STRIP LED LIGHT FIXTURE WITH LAMPS ON EMERGENCY LIGHT CIRCUIT WITH BATTERY PACK SURFACE MOUNT TO GWB AND ACT CEILING. FOR FIXTURES WITH 4 LAMPS, THE EMERGENCY BATTERY PACK WILL ONLY OPERATE 2 OF THE LAMPS.
- 4'-0" STRIP LED LIGHT FIXTURE WITH LAMPS ON NIGHT LIGHT CIRCUIT. SURFACE MOUNT TO TO GWB AND ACT CEILING.
- 4'-0" STRIP LED LIGHT FIXTURE. SURFACE MOUNT TO ACT AND GWB CEILING.
- 4'-0" STRIP LED LIGHT FIXTURE WITH LAMPS ON EMERGENCY LIGHT CIRCUIT WITH BATTERY PACK. SURFACE MOUNT TO TO GWB AND ACT CEILING.
- EXIT LIGHT
- SECURITY CAMERA DOME
- SECURITY CAMERA DOME MTD ON WALL @ 10'-0" AFF.
- VENTILATION FAN
- CEILING HEIGHT ABOVE FINISH FLOOR
- MIRROR PANEL
- DIFFUSER
- RETURN AIR GRILLE
- POWER POLE
- HEATER

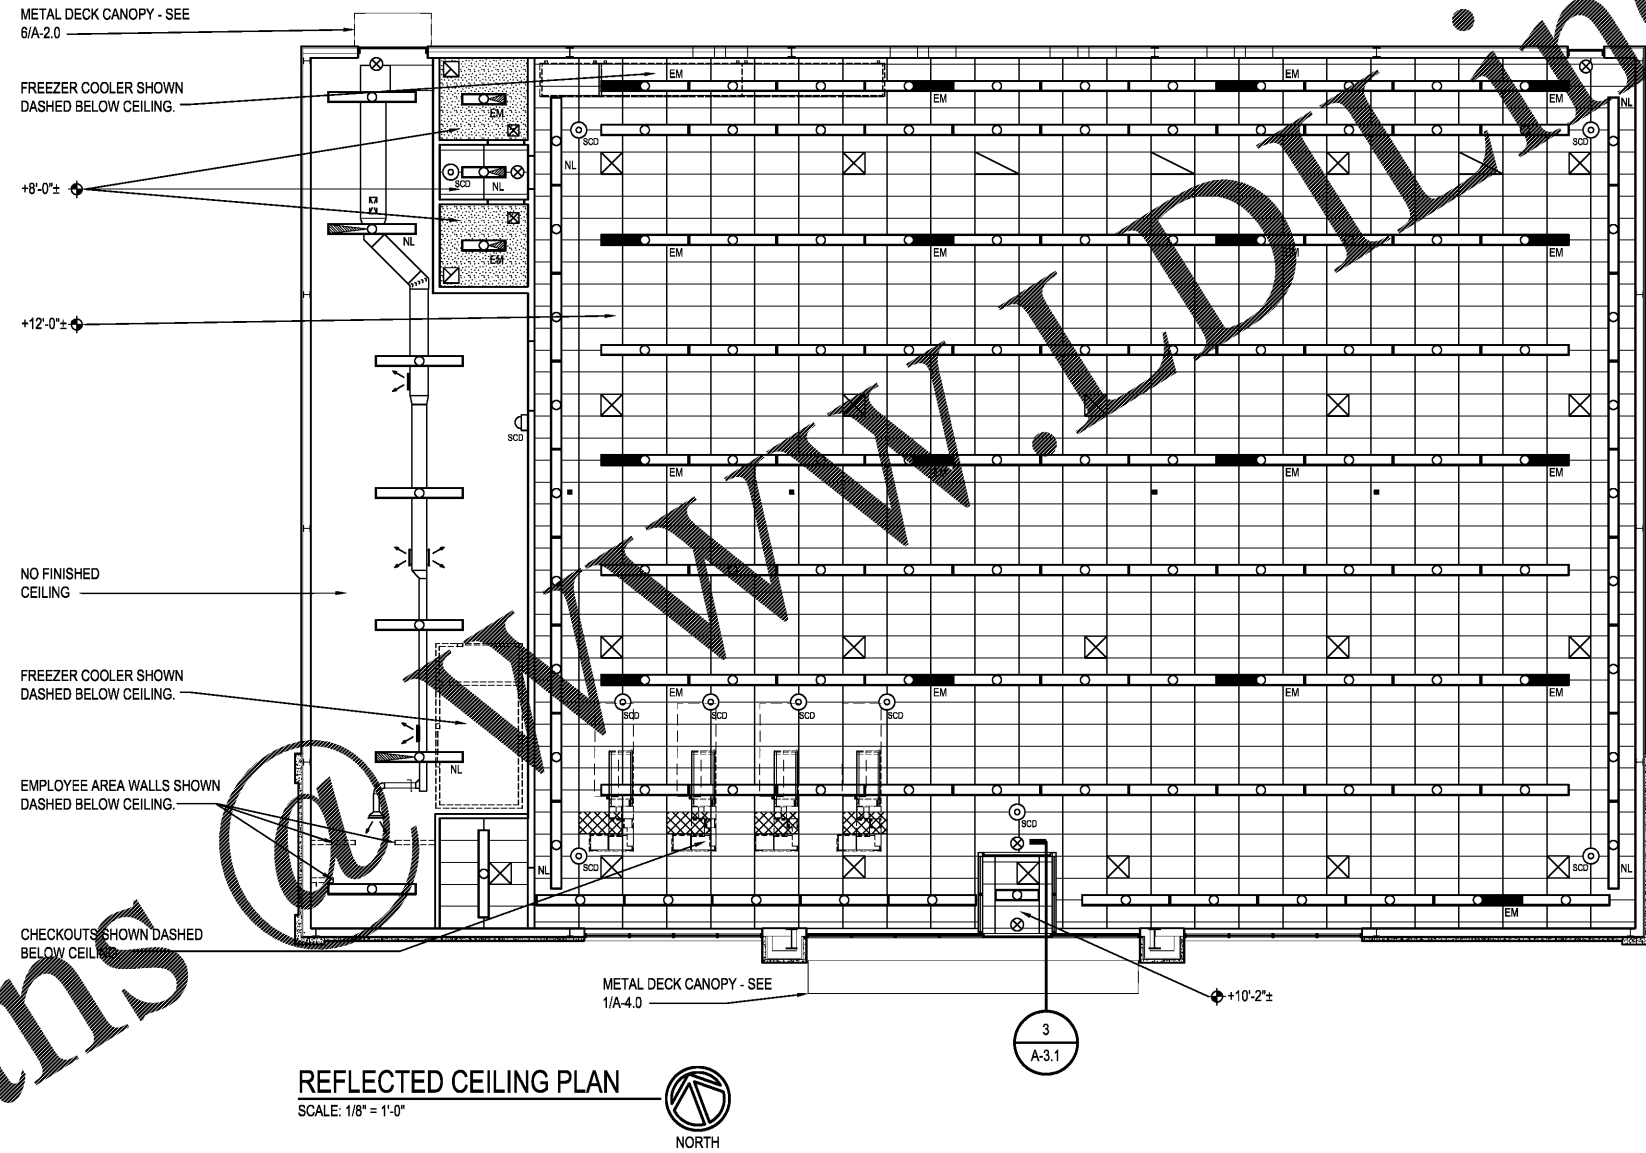

Order Plans

 3801 SPRING HILL AVENUE MOBILE, ALABAMA 36608 (251) 344-7073 / FAX (251) 345-9179	REV. DATE 08/08/17	DRN LGS CHK	DESCRIPTION DOCUMENT CONTROL	 08-08-2017	 COLUMBUS, GA REFLECTED CEILING PLAN
	PROJ. NO. 17138-73	DWG. NO. A-1.2			