



3'-0" x 7'-0" METAL DECK CANOPY - HANGER ROD SUPPORTED W/ 8" FASCIA - SUPPLIED & INSTALLED BY SIGN VENDOR - GC TO PROVIDE & INSTALL WALL BOLTS (SEE SPECS, T-5, & 4/A-2.1)

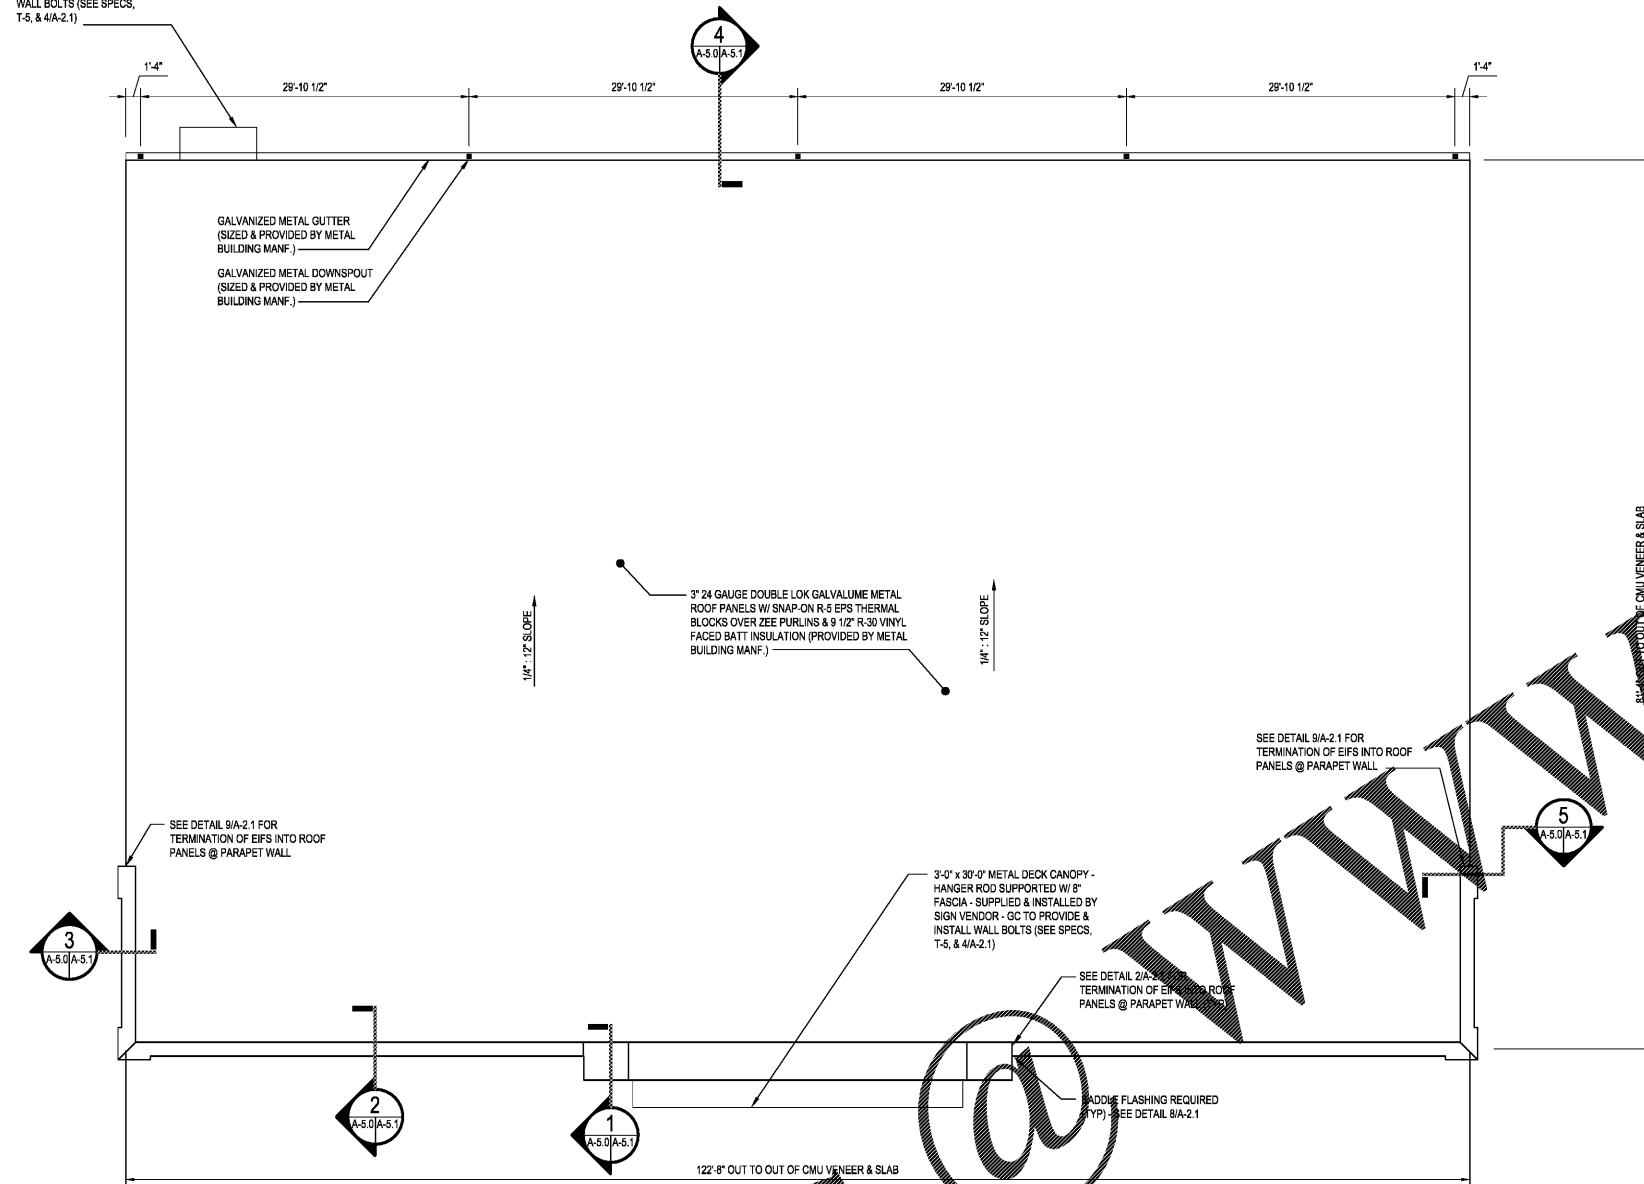


ROOF PLAN
SCALE: 1/8"=1'-0"

WWW.LDILine.com

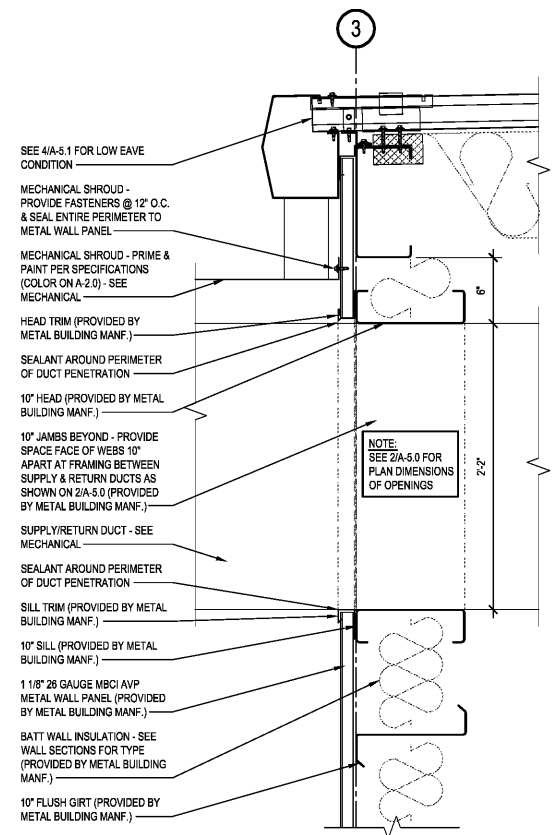

HVAC DUCT PENETRATION DETAIL 1
SCALE: 1 1/2"=1'-0"

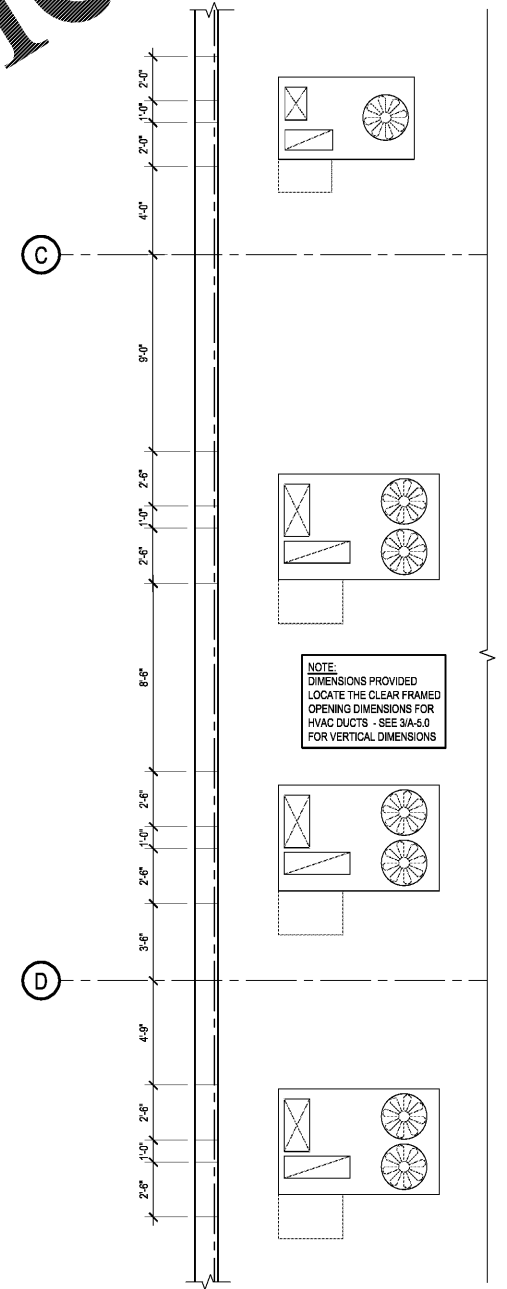

HVAC PENETRATION PLAN 2
SCALE: 1/4"=1'-0"

Order Plans

	COLUMBUS, GA ROOF PLAN & MISCELLANEOUS DETAILS
3901 SPRING HILL AVENUE MOBILE, ALABAMA 36608 (251) 344-7073 / FAX (251) 343-9179	PROJ. NO. 1605-84 DWG. NO. A-5.0