

TELETROL SYSTEMS INC.
286 Commercial Street
Manchester, NH 03101


PHILIPS
teletrol
sense and simplicity

**DOLLAR TREE
LINE DIAGRAM
(FOR REFERENCE ONLY)**

REVISION: (PART NUMBER 94-327)	DATE:
ADD NEW CONTROLLER TO DESIGN (ECN 2187)	4/11/14
ADD INTERCONNECTION INFORMATION FOR AUXILIARY I/O PANEL, 01-451 (ECN 2234)	8/28/14
ADD ANTUMBRA OPTION (ECN 2239)	8/12/14

DRAWN: W.P.C.	CHECKED: R.S.R.
------------------	--------------------

ENERGY
MANAGEMENT
PLAN

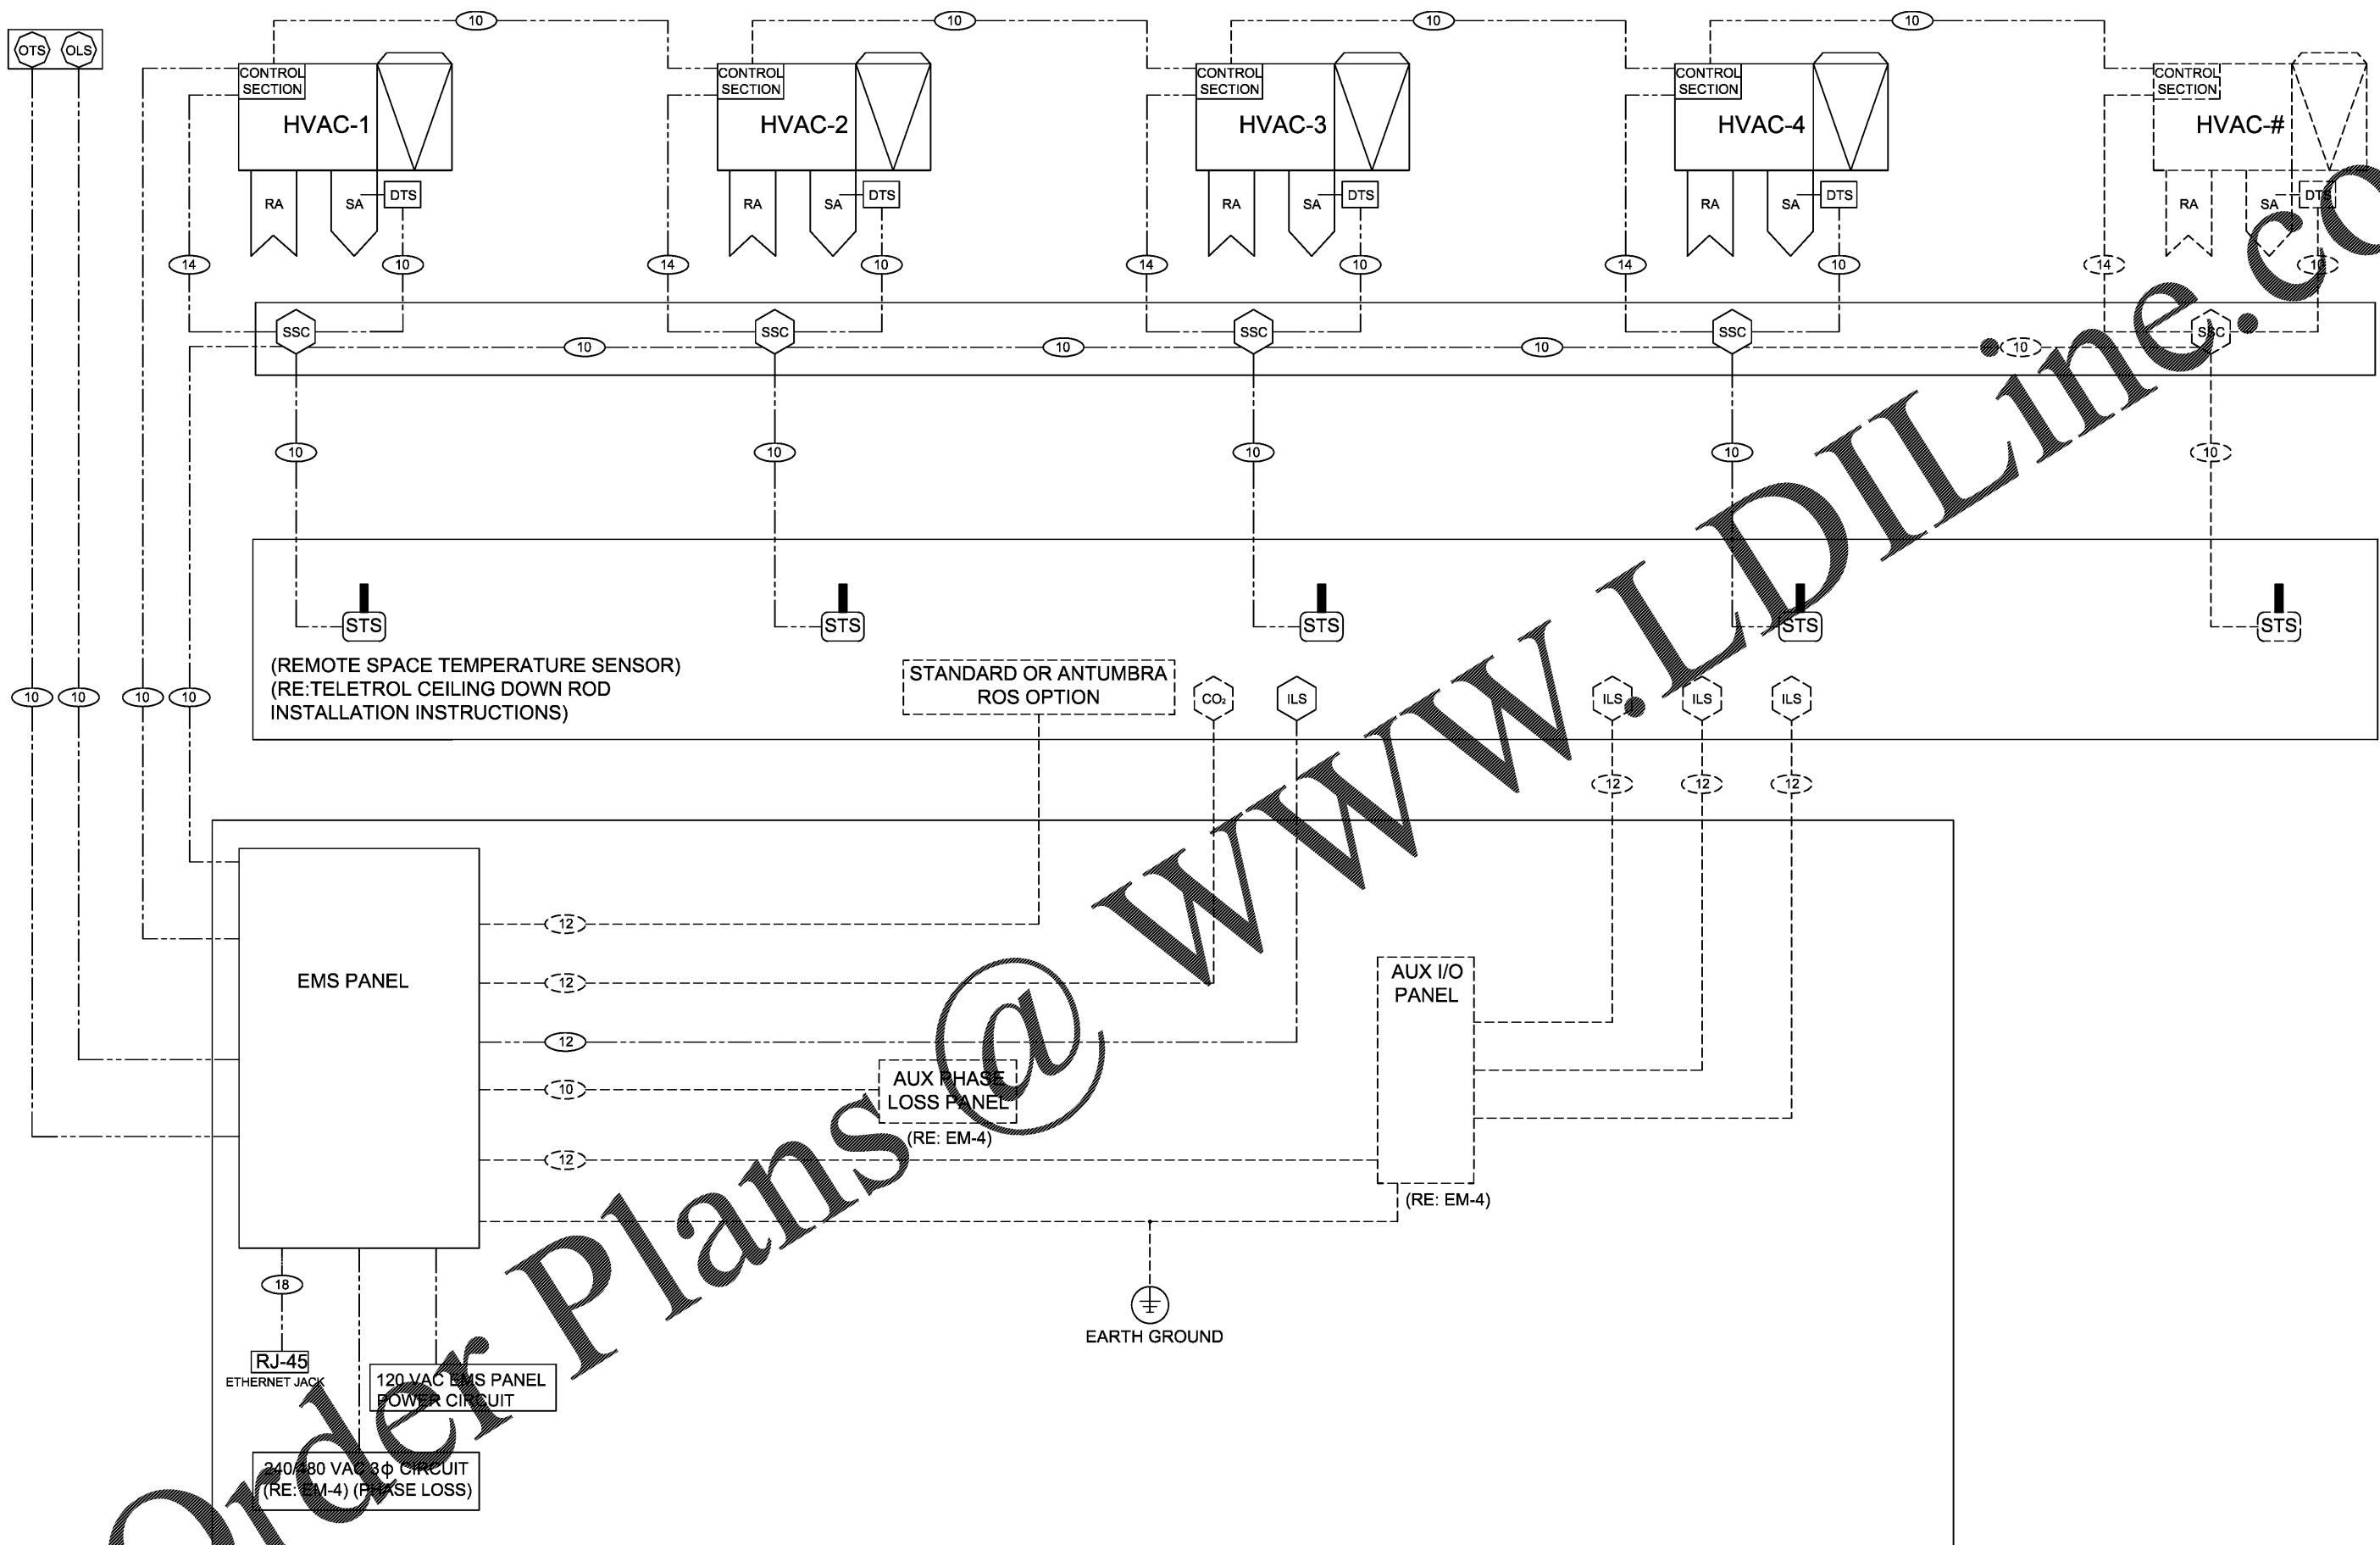

MOUNTED IN ELECTRICAL ROOM/AREA ADJACENT TO LIGHTING
CIRCUIT PANELS) (RE: EM-3 EMS WIRING DETAIL)

ENERGY MANAGEMENT SYSTEM SINGLE LINE DIAGRAM

SCALE: None