


GAS PIPING AND CONNECTION BY GAS COMPANY.
 GAS METER CAPABLE OF SUPPLYING 2.0M BTU BY GAS COMPANY. HOOKUP IS TO BE PROVIDED AT FUTURE TENANT IMPROVEMENTS.

| PLUMBING LEGEND | |
|-------------------------------|----------|
| SANITARY SEWER (SAN) | --- |
| STORM SEWER (ST) | --- |
| GREASE WASTE (GW) | ---GW--- |
| VENT (V) | --- |
| COLD WATER (CW) | --- |
| GAS LINE (G) | --- |
| FLOOR CLEANOUT (FCO) | ○ FCO |
| CLEANOUT TO GRADE (COTG) | □ COTG |
| PIPE DROP | --- |
| PIPE RISE | --- |
| SHUT-OFF VALVE | ⊕ |
| EXISTING SANITARY SEWER (SAN) | --- |

- PLUMBING KEYED NOTES:**
- EXTEND AND CONNECT TO SITE SANITARY SEWER MAIN. I.E. = 36" A.F.F. COORDINATE LOCATION AND INVERT WITH CIVIL PLANS FROM 10' COMMENCEMENT OF WORK.
 - PROVIDE 4" SANITARY SUB WITH CLEANOUT COVER FOR FUTURE TENANT IMPROVEMENT.
 1" CW RISER WITH SHUT-OFF VALVE AT 4'-0" A.F.F. EXTEND TO TIGHT STRUCTURE AND CAP FOR FUTURE TENANT IMPROVEMENT.
 - EXTEND AND CONNECT TO SITE DOMESTIC WATER. COORDINATE WITH CIVIL PLANS.
 - PROVIDE 6" GREASE STUB WITH CLEANOUT COVER FOR FUTURE TENANT IMPROVEMENT.
 - PROVIDE 3" VTR AND CAP FOR FUTURE TENANT IMPROVEMENT.

PLUMBING PLAN
 SCALE: 1/8" = 1'-0"

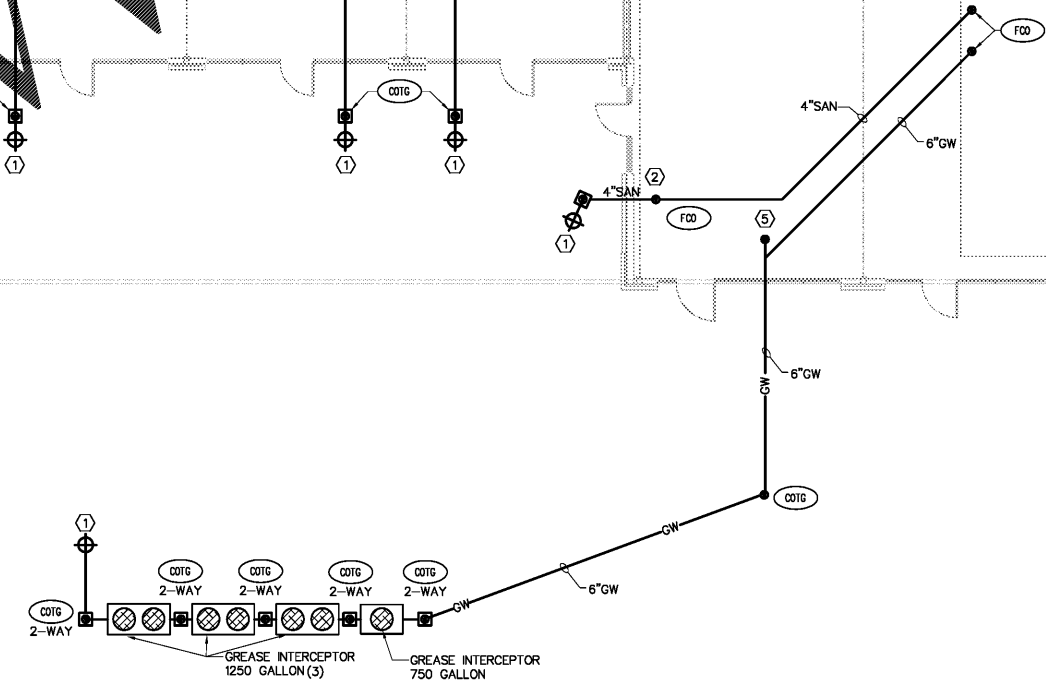

MIBI
 michael brady inc.
 ARCHITECTURE INTERIORS
 4300000008

1560 PALM BEACH LAKES BLVD
 SUITE 200
 LAKE MARY, FLORIDA 32746
 PHONE: 407-966-0330
 FAX: 407-966-0336
 WWW.MIBIARCHITECTURE.COM

THE DESIGN PROFESSIONAL DENIES ANY AND ALL RESPONSIBILITY AND LIABILITY FOR PROBLEMS WHICH ARISE FROM FAILURE TO FOLLOW THESE PLANS, SPECIFICATIONS AND THE DESIGN INTENT THEY CONVEY, OR PROBLEMS WHICH ARISE FROM OTHERS FAILURE TO OBTAIN AND/OR FOLLOW THE DESIGN PROFESSIONAL'S GUIDANCE WITH RESPECT TO ANY ERRORS, OMISSIONS, INCONSISTENCIES, AMBIGUITIES OR CONFLICTS WHICH ARE ALLEGED.

COPYRIGHT © MICHAEL BRADY INC. 2017

A NEW DEVELOPMENT FOR:
WEST PALM BEACH RETAIL BUILDING
 1560 PALM BEACH LAKES BLVD
 WEST PALM BEACH, FL 33401

THIS DRAWING HAS BEEN ISSUED:
 FOR REVIEW ONLY
 FOR PERMITTING ONLY
 SCHEMATIC DESIGN
 DESIGN DEVELOPMENT
 CONSTRUCTION DOCUMENTS

Drawing Title:
 PLUMBING PLAN

Date: 05/24/17
 Designed By: LR
 Drawn By: LR
 Reviewed By: JS
 Comm. No. 170217
 Revisions:

Order Forms