



KEYNOTES

- 1 EX. PLUMBING FIXTURE TO REMAIN
- 2 REMOVE EX. FLOOR SINK, CAP EXISTING POLE AND INFILL AS NEEDED

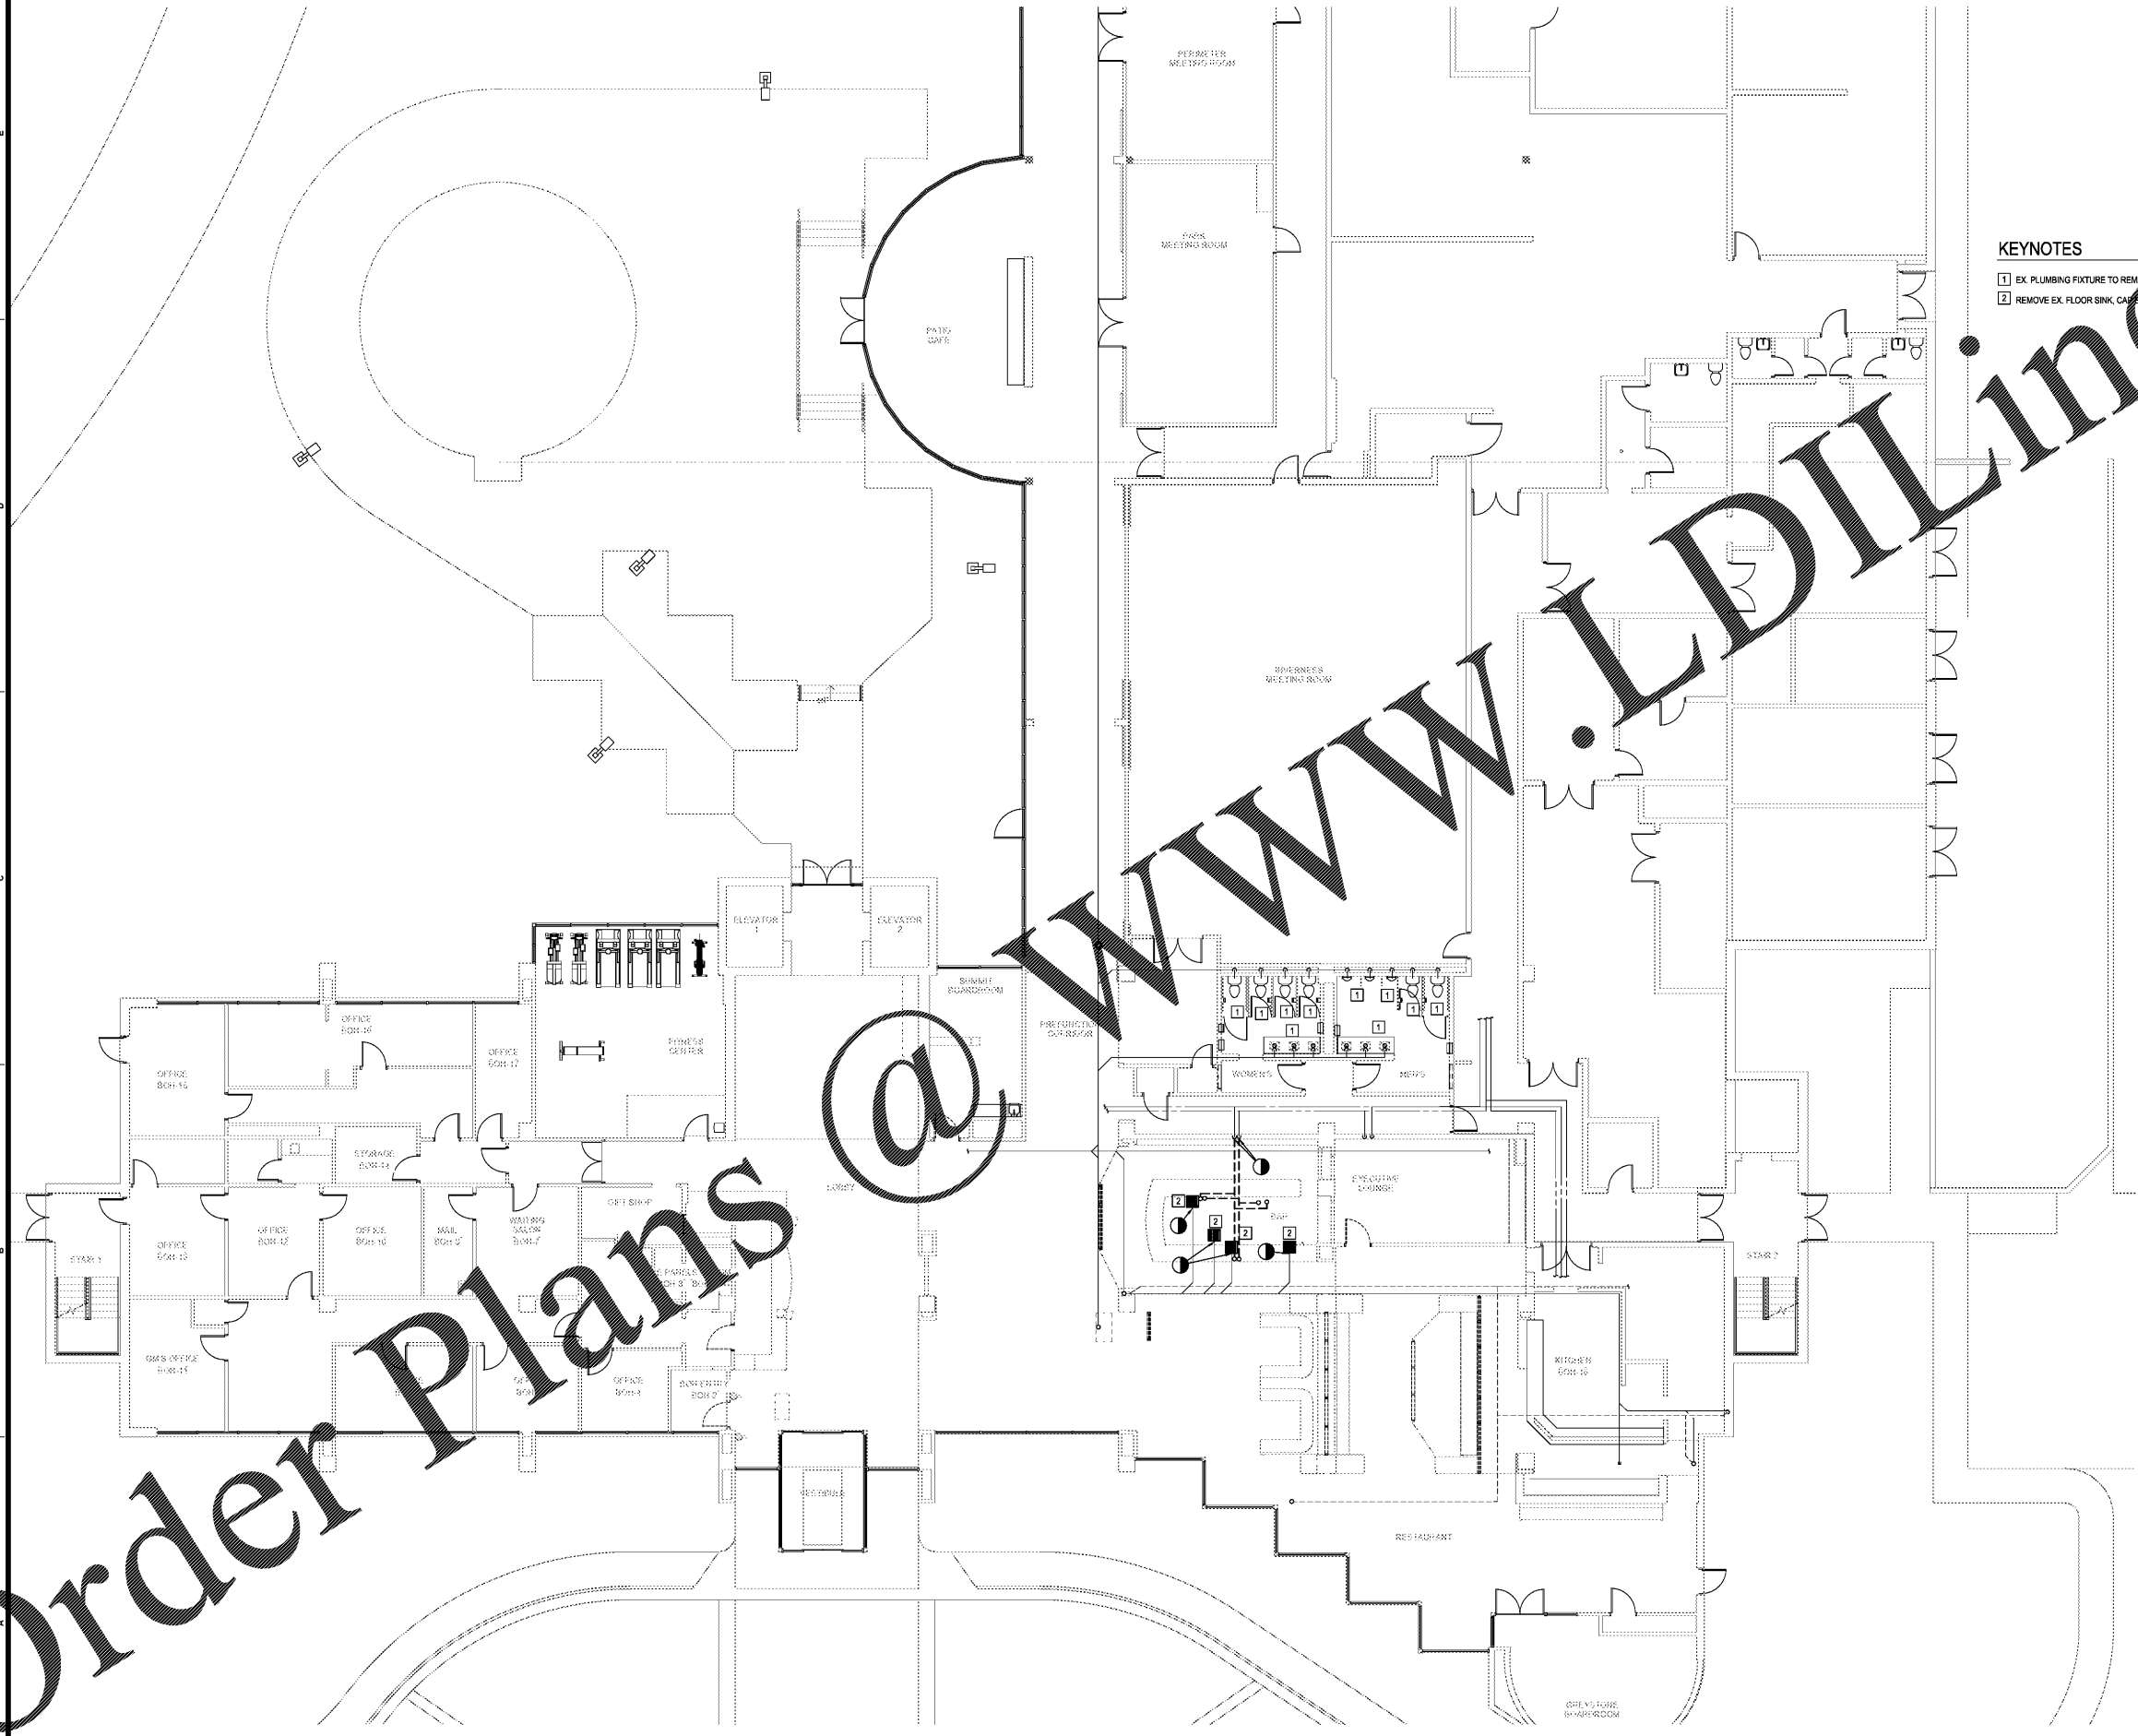

Order Plans @

 1A FIRST FLOOR DEMOLITION PLAN - SOUTH
SCALE: 1/8" = 1'-0"



3/2/2017 5:36 PM