

 

COPYRIGHT 2017 BASKERVILL. USE OF THIS WORK IN WHOLE OR IN PART IS FORBIDDEN WITHOUT EXPRESSED WRITTEN CONSENT.

ISSUE
06/12/2017 -
CONSTRUCTION
DRAWINGS

DRAWING TITLE
FIRST FLOOR
DEMOLITION PLAN -
NORTH

DRAWING NO.
P111B

- KEYNOTES**
- 1 REMOVE EXISTING PLUMBING FIXTURE. CAP EXISTING WATER, WASTEWATER LINES AS REQUIRED.
 - 2 RELOCATE EXISTING PLUMBING FIXTURE. EXTEND EX. WATER, WASTEWATER LINES AS NEEDED.
 - 3 EX. PLUMBING FIXTURE TO REMAIN.

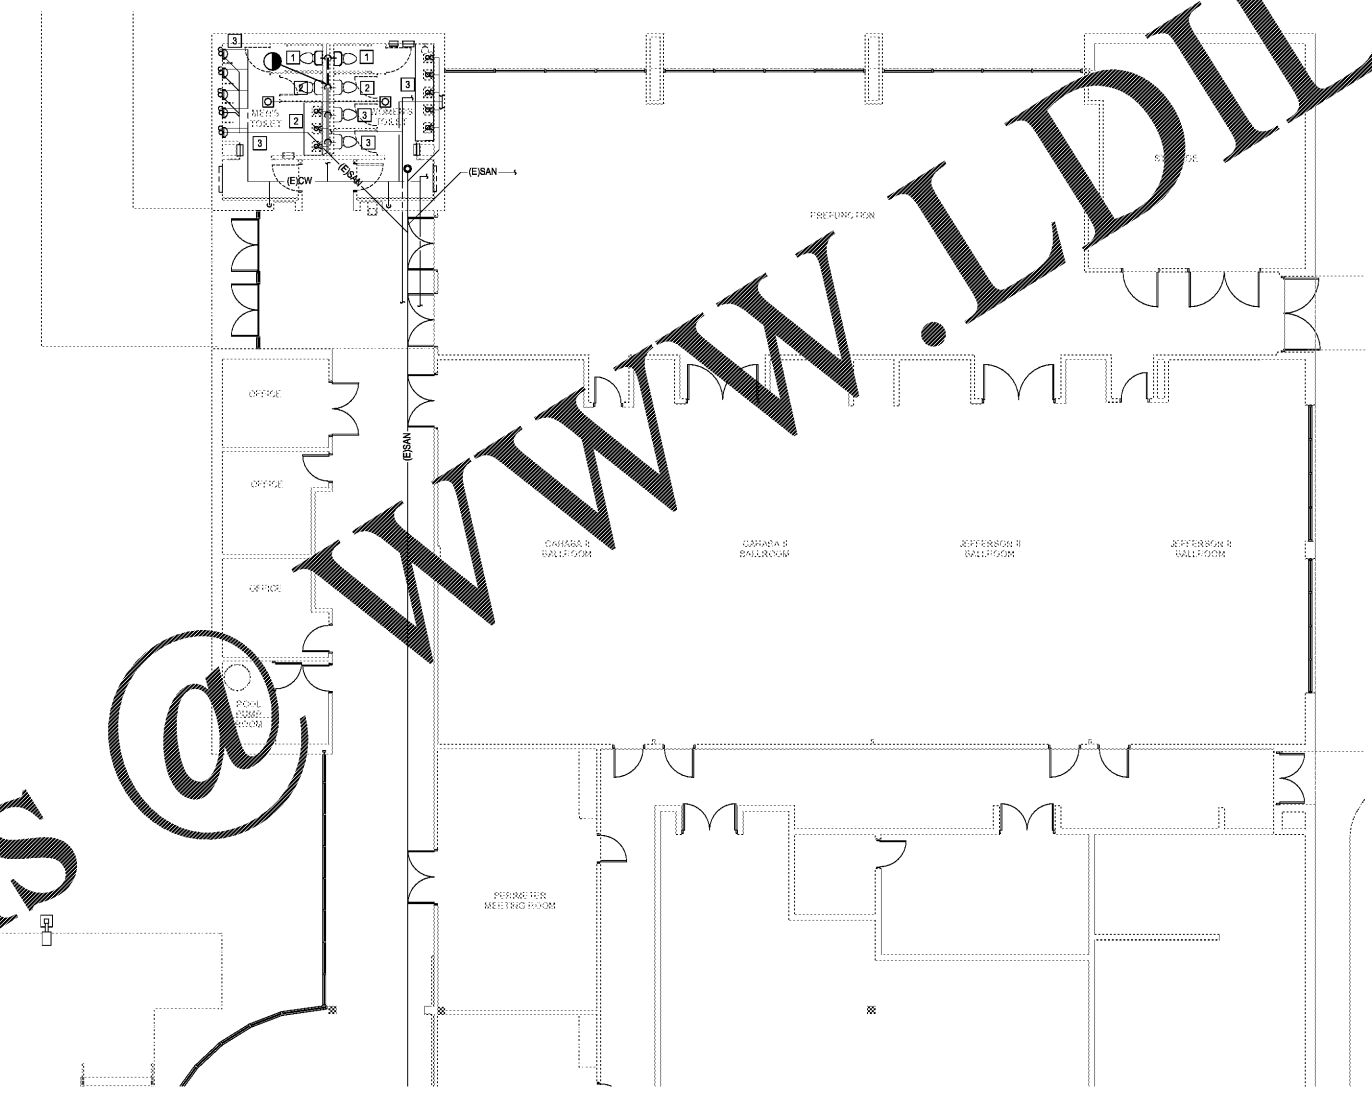

1B FIRST FLOOR DEMOLITION PLAN -NORTH
SCALE: 1/8" = 1'-0"

Order Plans @

WWW.LDILINE.COM

3/2/2017 5:36 PM