
 


1 THIRD FLOOR PLAN - NEW WORK
E113 SCALE: 1/8" = 1'-0"

- KEYNOTES**
- 1 REFER TO ENLARGED PLANS.
 - 2 E.C. TO WIRE NEW LIGHT FIXTURE TO EXISTING CIRCUITS AND LIGHTING CONTROLS SERVING THIS AREA.

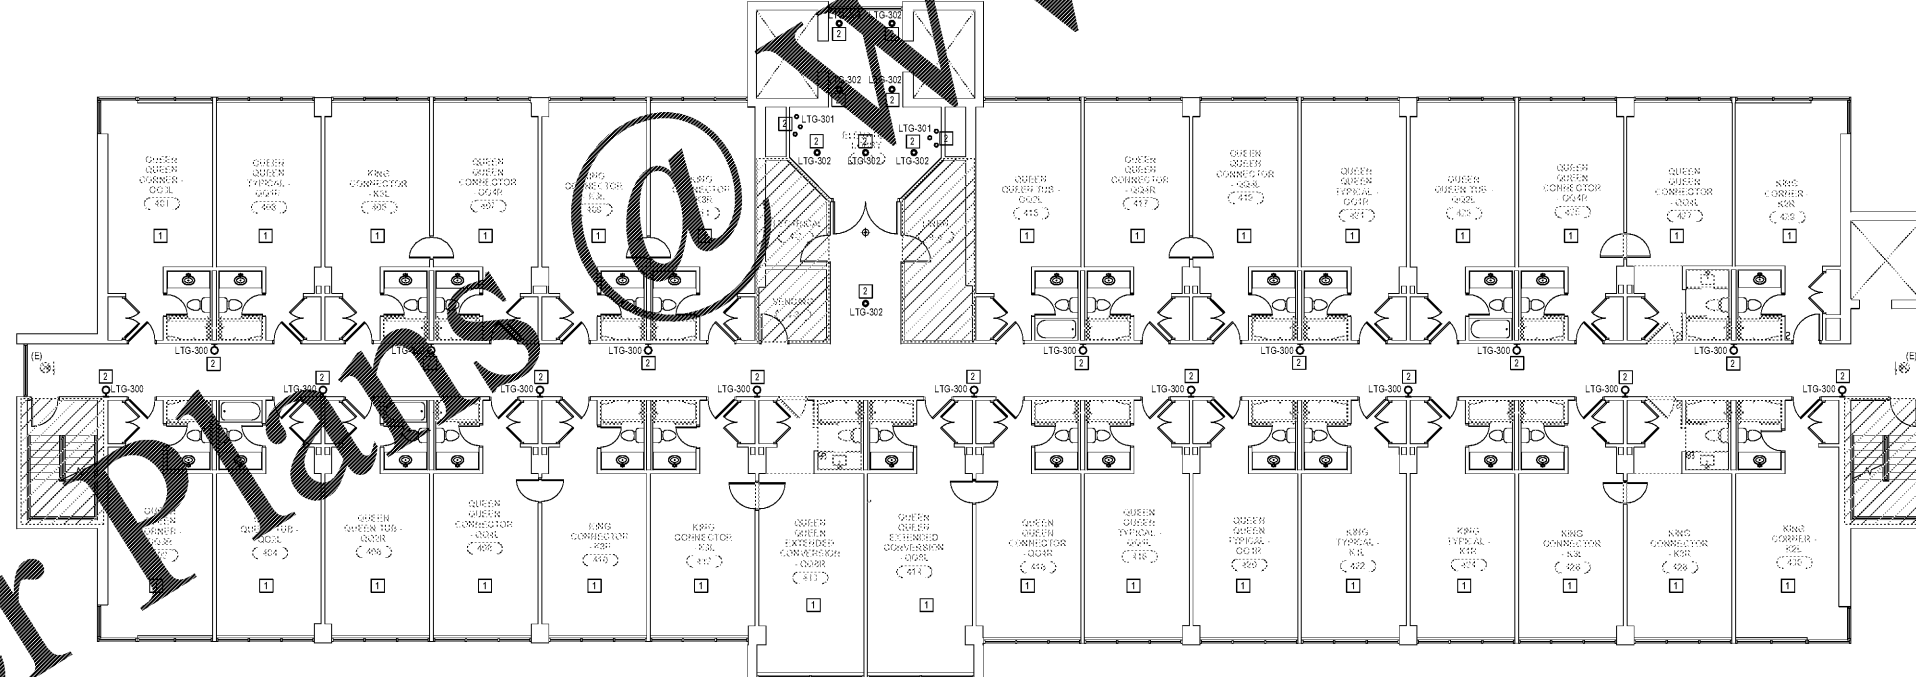

2 FOURTH FLOOR PLAN - NEW WORK
E113 SCALE: 1/8" = 1'-0"



COPYRIGHT 2017 BASKERVILL. USE OF THIS WORK IN WHOLE OR IN PART IS FORBIDDEN WITHOUT EXPRESSED WRITTEN CONSENT.

ISSUE
**06/12/2017 -
CONSTRUCTION
DRAWINGS**

DRAWING TITLE
**THIRD & FOURTH
FLOOR PLAN - NEW
WORK**

DRAWING NO.
E113

Order Plans @ www.LSOnline.com