


1 FIFTH FLOOR PLAN - NEW WORK
E114 SCALE: 1/8" = 1'-0"

- KEYNOTES
- 1 REFER TO ENLARGED PLANS.
 - 2 E.C. TO WIRE NEW LIGHT FIXTURE TO EXISTING CIRCUITS AND LIGHTING CONTROLS SERVING THIS AREA.



2 SIXTH FLOOR PLAN - NEW WORK
E114 SCALE: 1/8" = 1'-0"

 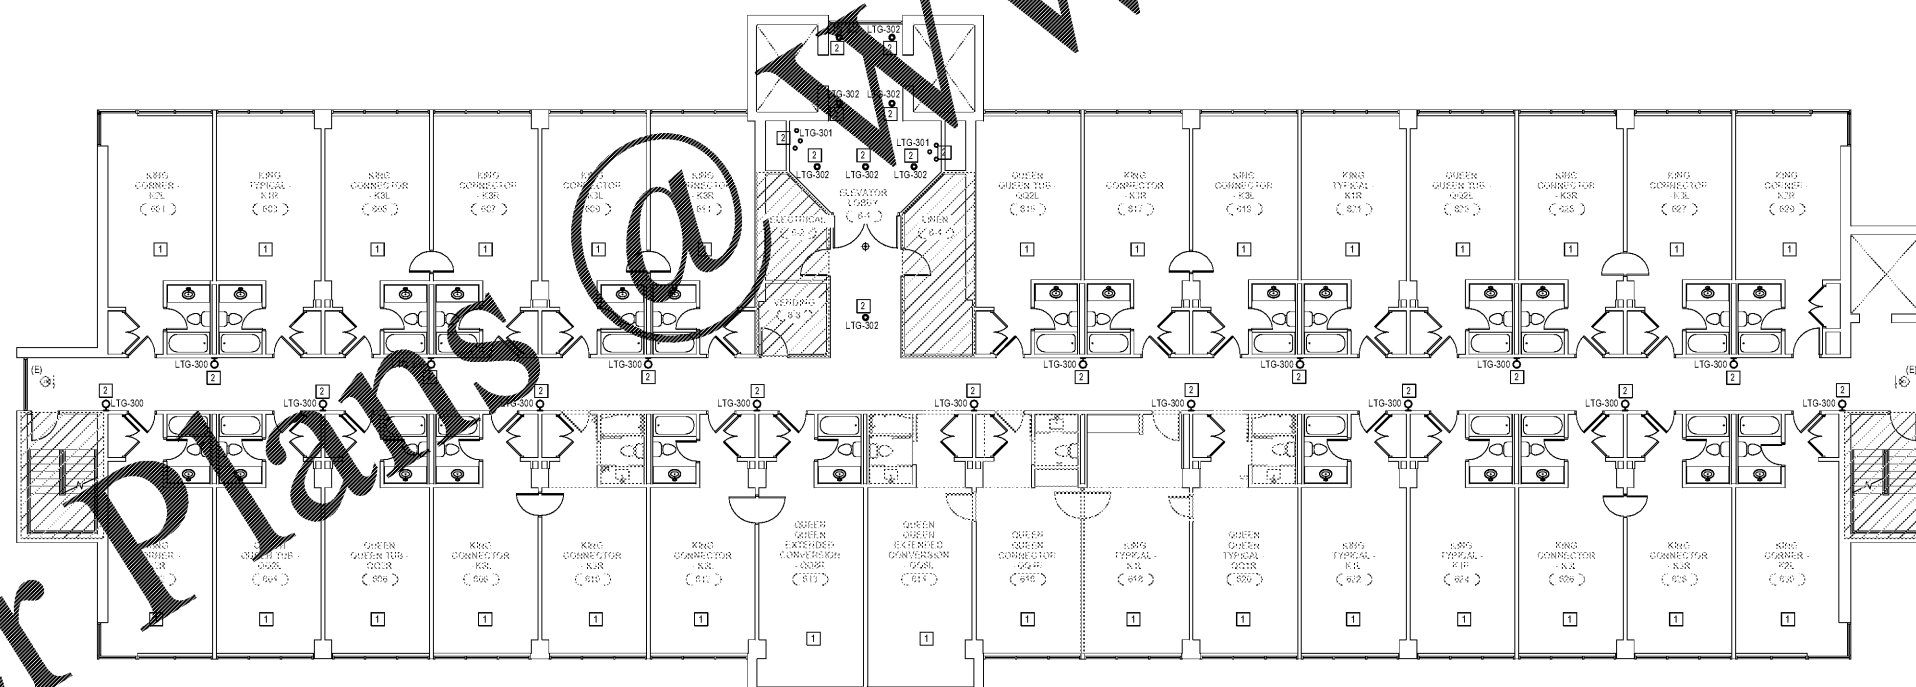


COPYRIGHT 2017 BASKERVILLE. USE OF THIS WORK IN WHOLE OR IN PART IS FORBIDDEN WITHOUT EXPRESSED WRITTEN CONSENT.

ISSUE
06/12/2017 -
CONSTRUCTION
DRAWINGS

DRAWING TITLE
FIFTH & SIXTH FLOOR
PLAN - NEW WORK

DRAWING NO.
E114



Order Plans @