



1 SEVENTH FLOOR PLAN - NEW WORK
E115 SCALE: 1/8" = 1'-0"

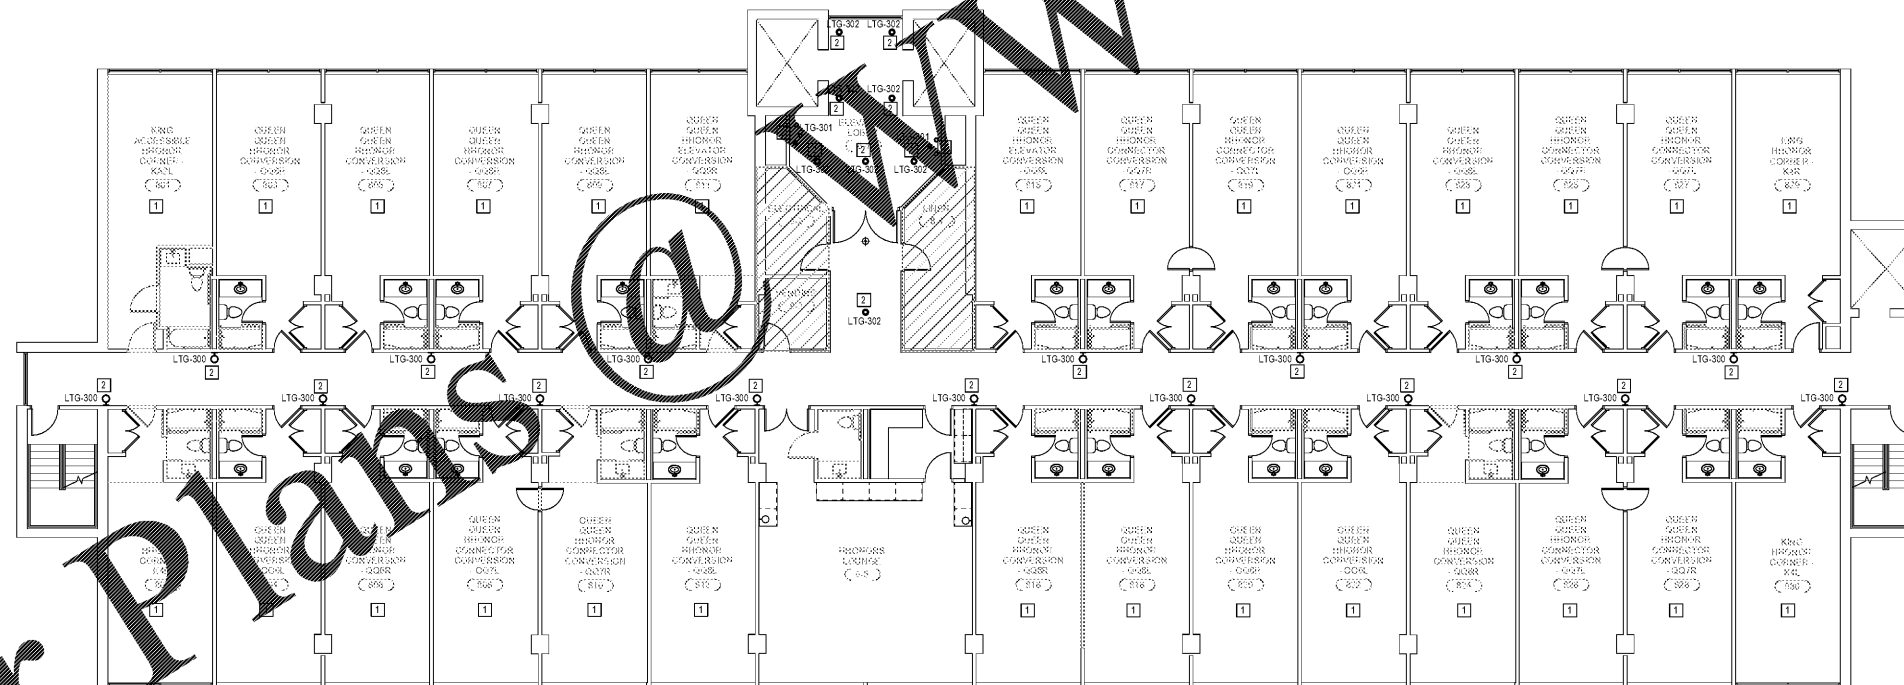

2 EIGHTH FLOOR PLAN - NEW WORK
E115 SCALE: 1/8" = 1'-0"

KEYNOTES

 - 1 REFER TO ENLARGED PLANS.
- 2 E.C. TO WIRE NEW LIGHT FIXTURE TO EXISTING CIRCUITS AND LIGHTING CONTROLS SERVING THIS AREA.



ISSUE
06/12/2017 -
CONSTRUCTION
DRAWINGS

DRAWING TITLE
SEVENTH & EIGHTH
FLOOR PLAN - NEW
WORK

DRAWING NO.
E115

Order Plans @

WWW.LDOnline.com