




COPYRIGHT 2017 BASKERVILL. USE OF THIS WORK IN WHOLE OR IN PART IS FORBIDDEN WITHOUT EXPRESSED WRITTEN CONSENT.

ISSUE
06/12/2017 -
CONSTRUCTION
DRAWINGS


DRAWING TITLE
FIRST FLOOR
LIGHTING PLAN -
SOUTH

DRAWING NO.
E211A

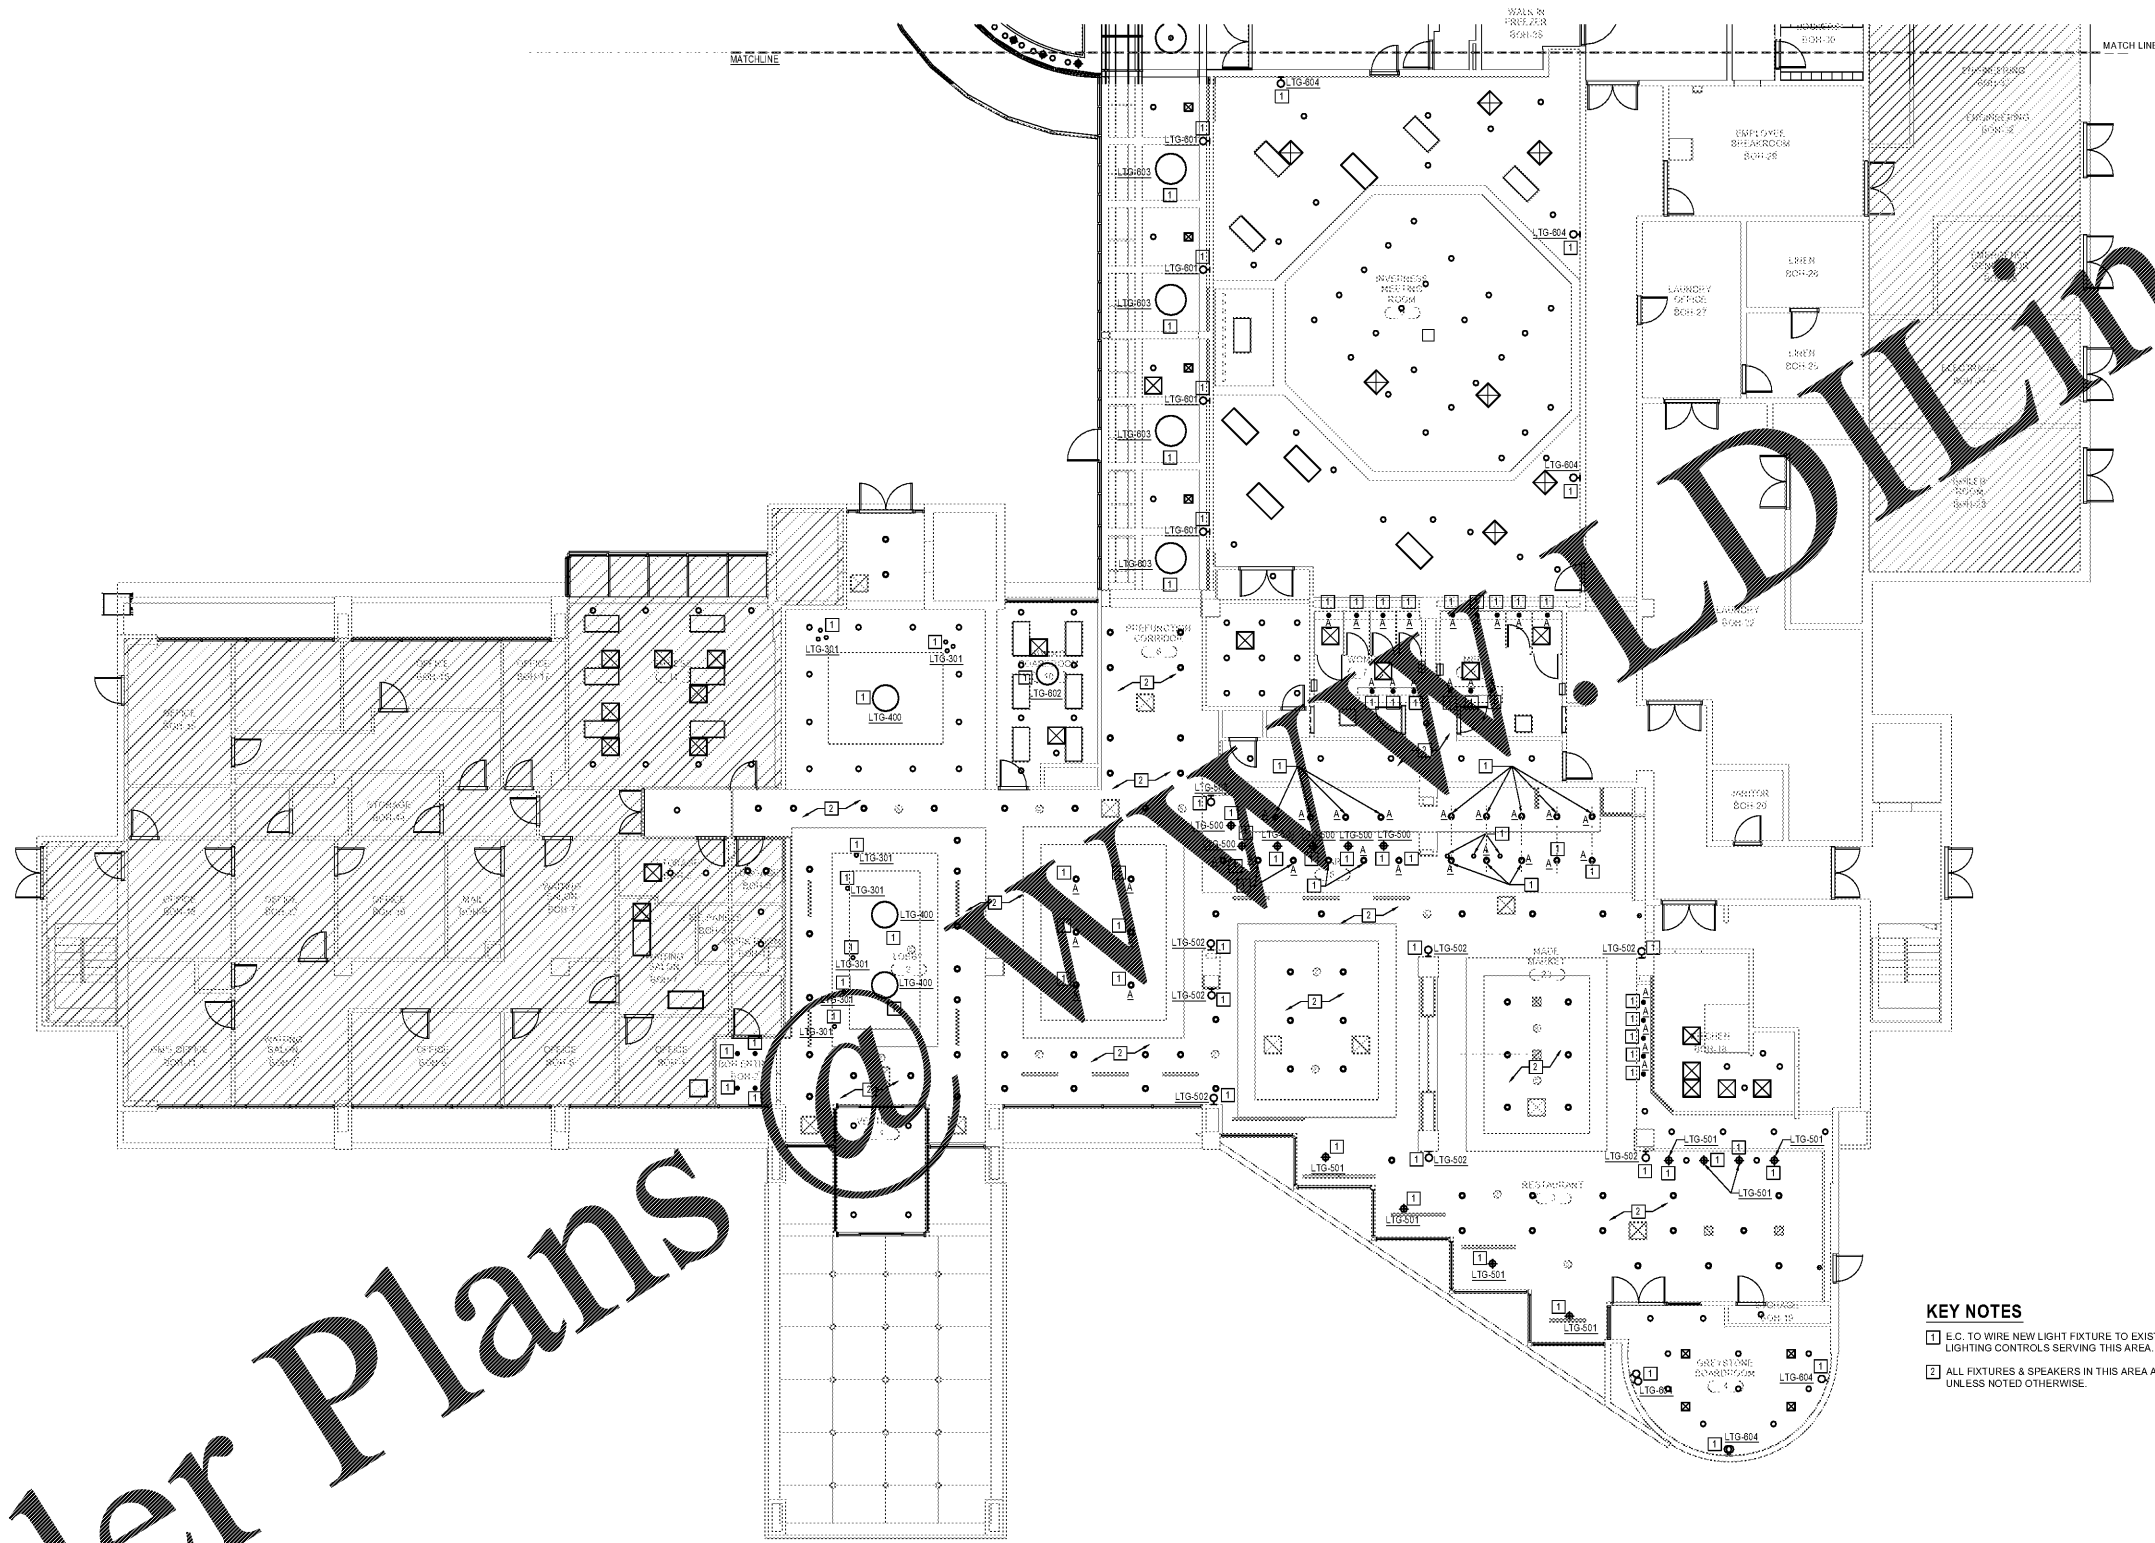

1 FIRST FLOOR LIGHTING PLAN - SOUTH
E211 SCALE: 1/8" = 1'-0"

 KEY NOTES
□ E.C. TO WIRE NEW LIGHT FIXTURE TO EXISTING CIRCUITS AND LIGHTING CONTROLS SERVING THIS AREA.
□ ALL FIXTURES & SPEAKERS IN THIS AREA ARE EXISTING RELOCATED UNLESS NOTED OTHERWISE.



Order Plans