
 


BAR EQUIPMENT CONNECTION SCHEDULE										
EQUIP NO.	EQUIP DESCRIPTION	PBD.	VOLTS	Ø	HP	AMPS	KW	TYPE	MOUNTING HEIGHT	REMARKS
E2	DISHWASHER	-	208	3	-	48.3	19.5	DIRECT	-	-
E19	COFFEE BREWER	-	208	1	-	25.1	8.1	DIRECT	-	-
E30	TEA BREWER	-	120	1	-	14.0	1.7	5-15P	-	-
E31	GAS FRYER	-	120	1	-	1.0	-	5-20P	-	-
E32	REFRIGERATED BASE	-	120	1	-	2.9	-	5-15P	-	-
E33	GAS COOKTOP GRIDDLE	-	120	1	-	1.0	-	5-15P	-	-
E34	GAS CHARBROILER	-	120	1	-	1.0	-	5-15P	-	-
E35	RANGE	-	120	1	-	3.4	-	5-15P	-	-
E36	REACH-IN FREEZER	-	120	1	-	7.2	-	5-15P	-	-
E37	PIZZA PREP FRIDGE	-	120	1	-	4.7	-	5-15P	-	-
E61	SELF SERVE FRIDGE	-	120	1	-	16.0	-	5-20P	-	-
E62	FRIDGE MERCHANDISER	-	120	1	-	5.4	-	5-15P	-	-
E63	FREEZER MERCHANDISER	-	120	1	-	9.3	-	5-15P	-	-
E67	U.C. DISHWASHER	-	208	1	-	36.8	-	DIRECT	-	-
E81	BACK BAR REFIG. CABINET	-	120	1	-	5.7	-	5-15P	-	-
E82	MUG CHILLER	-	120	1	-	7.1	-	5-15P	-	-
E83	BACK BAR REFIG. CABINET	-	120	1	-	5.7	-	5-15P	-	-
E89	BLENDER	-	120	1	3.5	13.0	-	C/P	-	-
E90	POS STATION	-	120	1	-	-	1.8	5-20P	-	-
E91	ESPRESSO MACHINE	-	208	1	-	30	5.0	L14-30P	-	-
E92	REACH-IN U.C. FRIDGE	-	120	1	1.0	14.0	-	C/P	-	-
E97	MICROWAVE CONVECTION	-	208	1	-	30.0	4.7	6-30P	-	-
E99	ICE MACHINE	-	120	1	-	5.0	26	5-15P	-	-
E100	BUFFET FRIDGE	-	120	1	-	8	-	5-15P	-	-
E101	TOASTER	-	208	1	-	15.9	-	6-20P	-	-
E111	INDUCTION WARMER	-	120	1	-	34	60	5-15P	-	-
E112	HEAT LAMP	-	208	1	-	-	3.45	DIRECT	-	-
E115	INDUCTION RANGE WARMER	-	120	1	-	5.4	65	5-15P	-	-

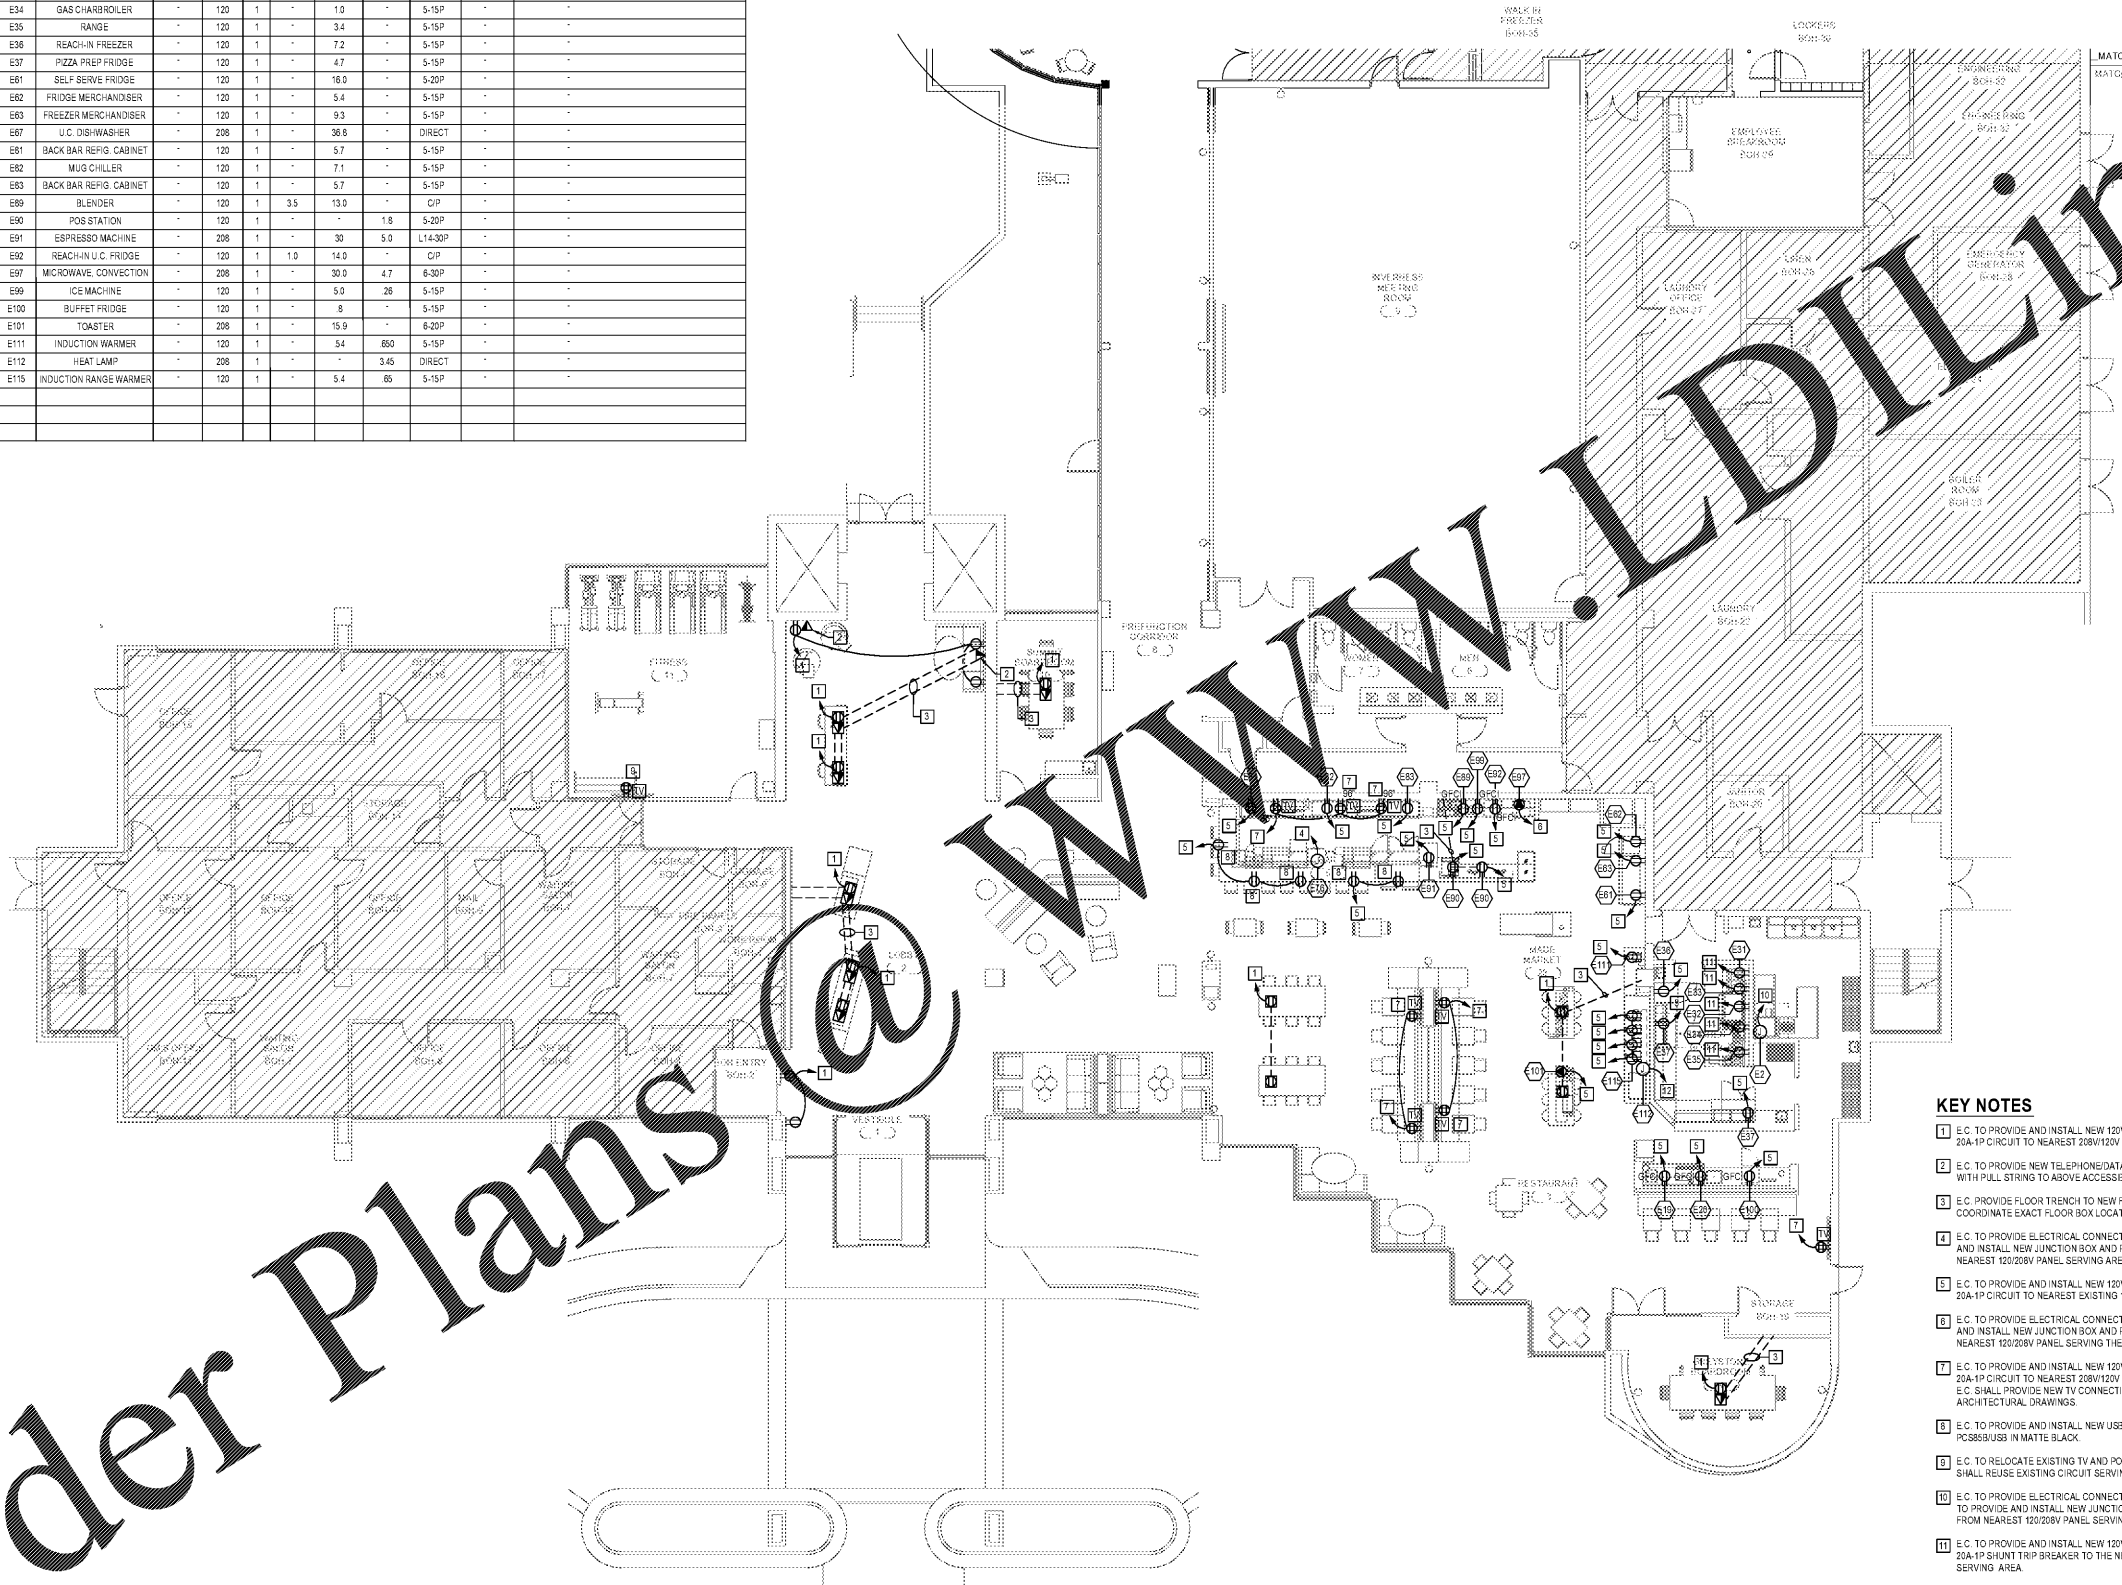

- KEY NOTES**
- E.C. TO PROVIDE AND INSTALL NEW 120V FLOORBOX. E.C. SHALL PROVIDE NEW 20A-1P CIRCUIT TO NEAREST 208V/120V PANEL WITH AVAILABLE BREAKER SPACE.
  - E.C. TO PROVIDE NEW TELEPHONE/DATA JACK. E.C. TO PROVIDE 3/4" CONDUIT WITH PULL STRING TO ABOVE ACCESSIBLE AREA.
  - E.C. PROVIDE FLOOR TRENCH TO NEW FLOOR BOX LOCATION. E.C. TO COORDINATE EXACT FLOOR BOX LOCATION WITH ARCHITECTURAL PLANS.
  - E.C. TO PROVIDE ELECTRICAL CONNECTION TO DISHWASHER. E.C. TO PROVIDE AND INSTALL NEW JUNCTION BOX AND PROVIDE NEW 40A-3P CIRCUIT FROM NEAREST 120/208V PANEL SERVING AREA.
  - E.C. TO PROVIDE AND INSTALL NEW 120V RECEPTACLE. E.C. SHALL PROVIDE NEW 20A-1P CIRCUIT TO NEAREST EXISTING 120/208V PANEL SERVING AREA.
  - E.C. TO PROVIDE ELECTRICAL CONNECTION TO DISHWASHER. E.C. TO PROVIDE AND INSTALL NEW JUNCTION BOX AND PROVIDE NEW 30A-2P CIRCUIT FROM NEAREST 120/208V PANEL SERVING THE BAR AREA.
  - E.C. TO PROVIDE AND INSTALL NEW 120V DUPLEX. E.C. SHALL PROVIDE NEW 20A-1P CIRCUIT TO NEAREST 208V/120V PANEL WITH AVAILABLE BREAKER SPACE. E.C. SHALL PROVIDE NEW TV CONNECTION. COORDINATE MOUNTING HEIGHT WITH ARCHITECTURAL DRAWINGS.
  - E.C. TO PROVIDE AND INSTALL NEW USB/RECEPTACLE. MCKETT MODEL # PC885UB3 IN MATTE BLACK.
  - E.C. TO RELOCATE EXISTING TV AND POWER CONNECTION IN FITNESS ROOM. E.C. SHALL REUSE EXISTING CIRCUIT SERVING AREA.
  - E.C. TO PROVIDE ELECTRICAL CONNECTION TO DISHWASHER WITH HEATER. E.C. TO PROVIDE AND INSTALL NEW JUNCTION BOX AND PROVIDE NEW 50A-3P CIRCUIT FROM NEAREST 120/208V PANEL SERVING THE KITCHEN AREA.
  - E.C. TO PROVIDE AND INSTALL NEW 120V RECEPTACLE. E.C. SHALL PROVIDE NEW 20A-1P SHUNT TRIP BREAKER TO THE NEAREST EXISTING 120/208V PANEL SERVING AREA.
  - E.C. TO PROVIDE ELECTRICAL CONNECTION TO HEAT LAMP. E.C. TO PROVIDE AND INSTALL NEW JUNCTION BOX AND PROVIDE NEW 30A-2P CIRCUIT FROM NEAREST 120/208V PANEL SERVING THE KITCHEN AREA.

NOTE: E.C. TO COORDINATE WITH ARCHITECTURAL DRAWINGS FOR EXACT LOCATIONS AND MOUNTING HEIGHTS OF DEVICES.



**1** FIRST FLOOR ELECTRICAL PLAN - NEW WORK  
 E311 SCALE: 1/8" = 1'-0"



ISSUE  
**06/12/2017 -**  
**CONSTRUCTION**  
**DRAWINGS**

DRAWING TITLE  
**FIRST FLOOR**  
**ELECTRICAL PLAN -**  
**SOUTH**

DRAWING NO.  
**E311**

Order Plans @