


Order Plans

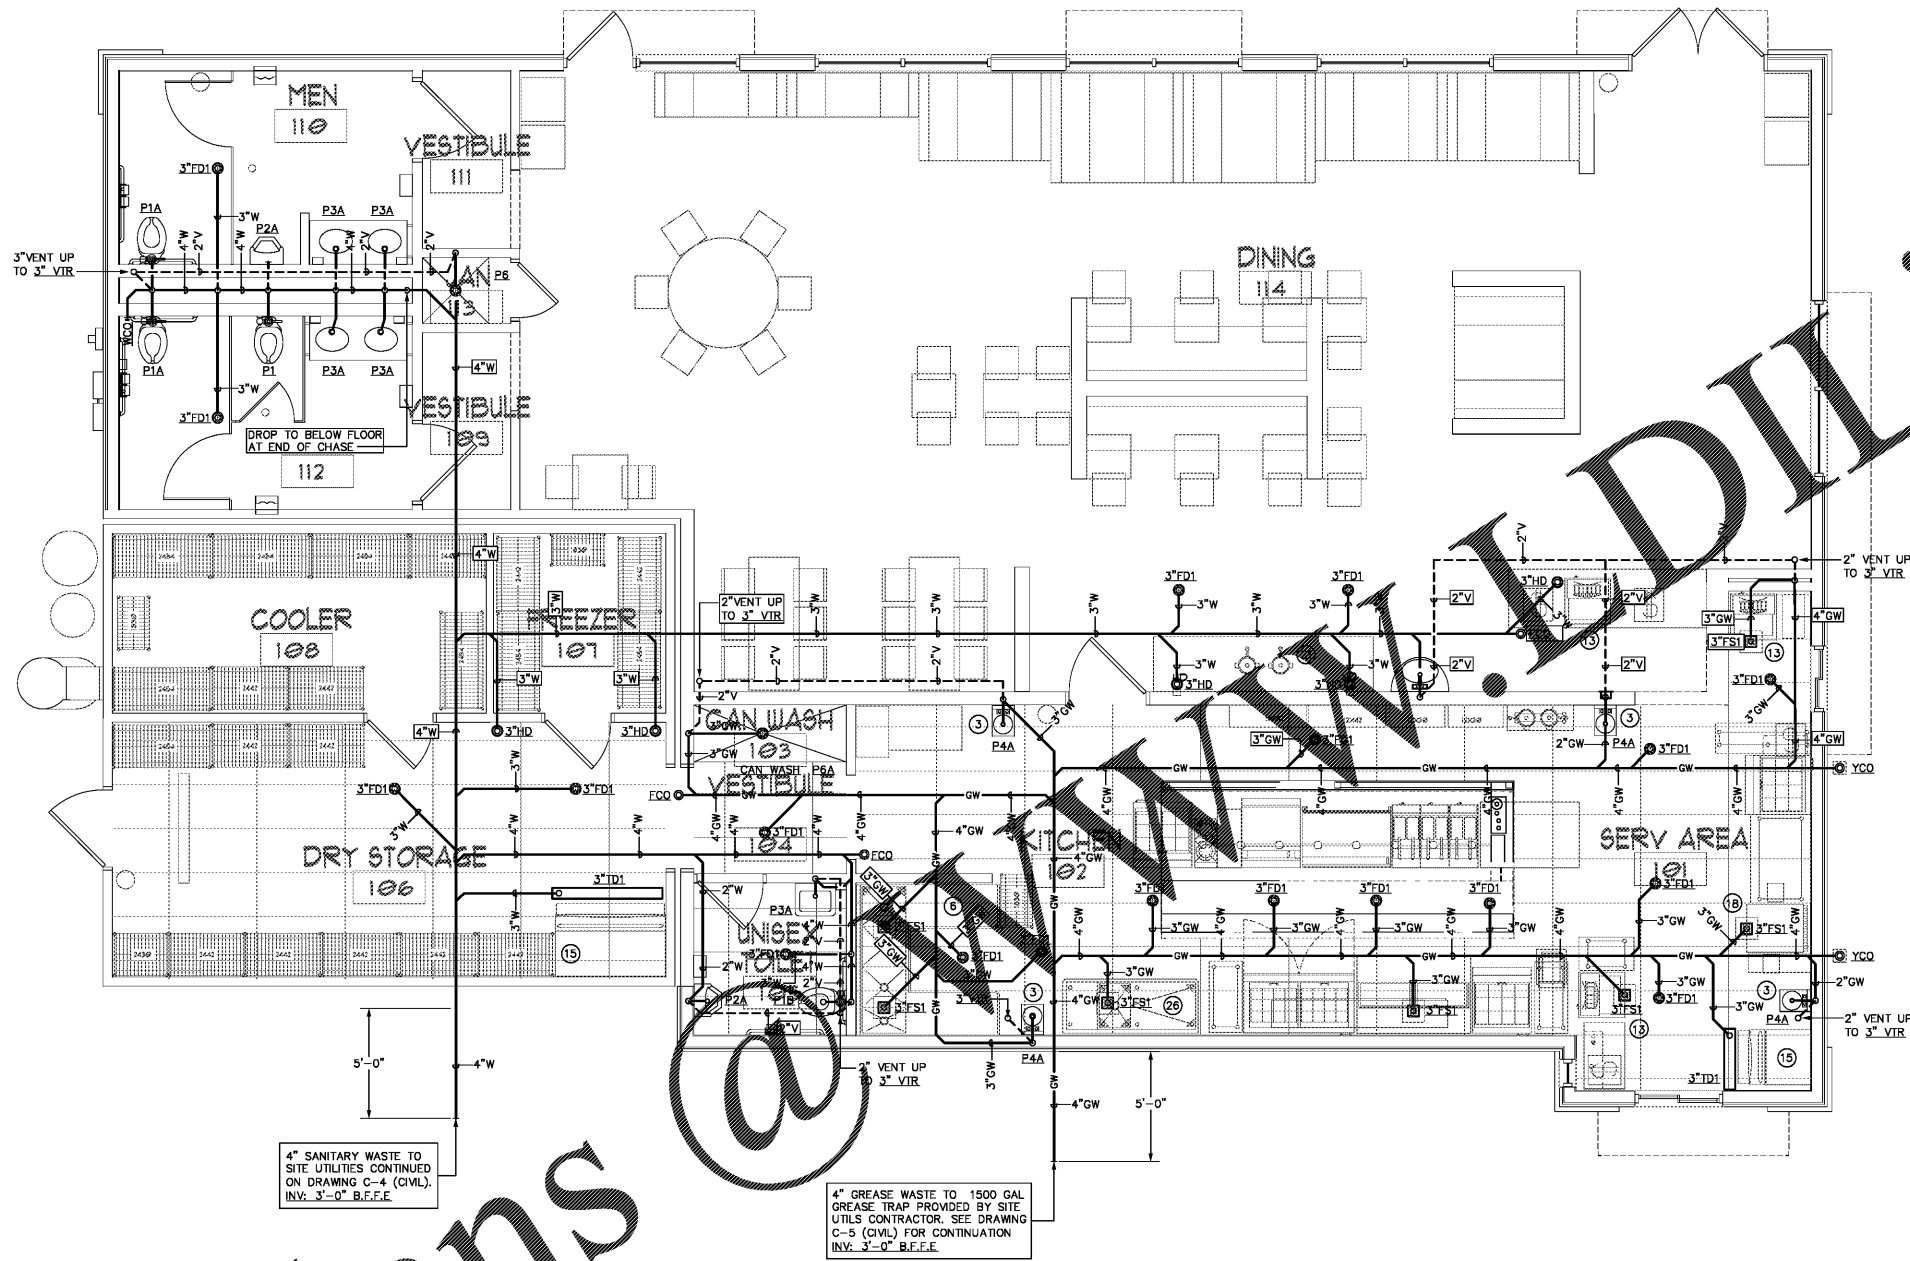

1 WASTE AND VENT FLOOR PLAN - PLUMBING
1/4" = 1'-0"

KITCHEN EQUIPMENT CONNECTION SCHEDULE								
SYM.	DESCRIPTION	SAN	VENT	HW	CW	FW	GAS	REMARKS
3	HAND SINK	2"	2"	1/2"	1/2"	-	-	PROVIDE MIXING VALVE MXXV1 SET AT 105° F
6	4-COMPARTMENT SINK	FS	-	1/2"	1/2"	-	-	IW TO FLOOR SINK
13	BEVERAGE MACHINE W/ICE BIN	HD	-	-	-	1/2"	-	IW TO FLOOR SINK OR HD; PROVIDE WATTS SD3 BFP
18	MILK SHAKE MACHINE	HD	-	-	-	1/2"	-	IW TO FLOOR SINK OR HD; PROVIDE WATTS SD3 BFP.
21	TEA BREWER	-	-	-	-	1/2"	-	PROVIDE WATTS SD3 BFP.
26	VEGETABLE PREP SINK	FS	-	1/2"	1/2"	-	-	IW TO FLOOR SINK
15	ICE MACHINE	TD	-	-	-	1/2"	-	1/4" IW TO FLOOR SINK. PROVIDE WATTS SD3 BFP.

NOTES:
1. KITCHEN EQUIPMENT AND FAUCETS SHALL BE PROVIDED BY THE FOOD SERVICE EQUIPMENT SUPPLIER AND FINAL CONNECTIONS SHALL BE MADE BY THE PLUMBING CONTRACTOR.
2. PLUMBING CONTRACTOR AND FOOD SERVICE EQUIPMENT SUPPLIER SHALL COORDINATE INSTALLATION OF KITCHEN EQUIPMENT.

LINDSEY ARCHITECTURE
125 S. ... Street, Suite 300
...boro, NC 27401
P. 336.617.4402
F. 336.617.4434
www.lindseyarchitecture.com

Optima engineering
1927 South Tryon St., Suite 200, Charlotte, NC 28203
Phone: 704-338-1922 • www.optimaengineering.com
North Carolina License Number: C-6814



8/04/17

COOK OUT
2546 Chimney Rock Road
Hendersonville, NC

HK	DATE	DESCRIPTION

WASTE AND VENT FLOOR PLAN - PLUMBING

DATE: 08-04-17
DRAWN BY: IRG
CHECK BY: DAR
JOB NO.: 17-000-000
SHEET:

P101