


HK	DATE	DESCRIPTION


PLUMBING GAS FLOOR PLAN

DATE: 08-04-17
 DRAWN BY: IRG
 CHECK BY: DAR
 JOB NO.: 17-001-000
 SHEET: **P301**

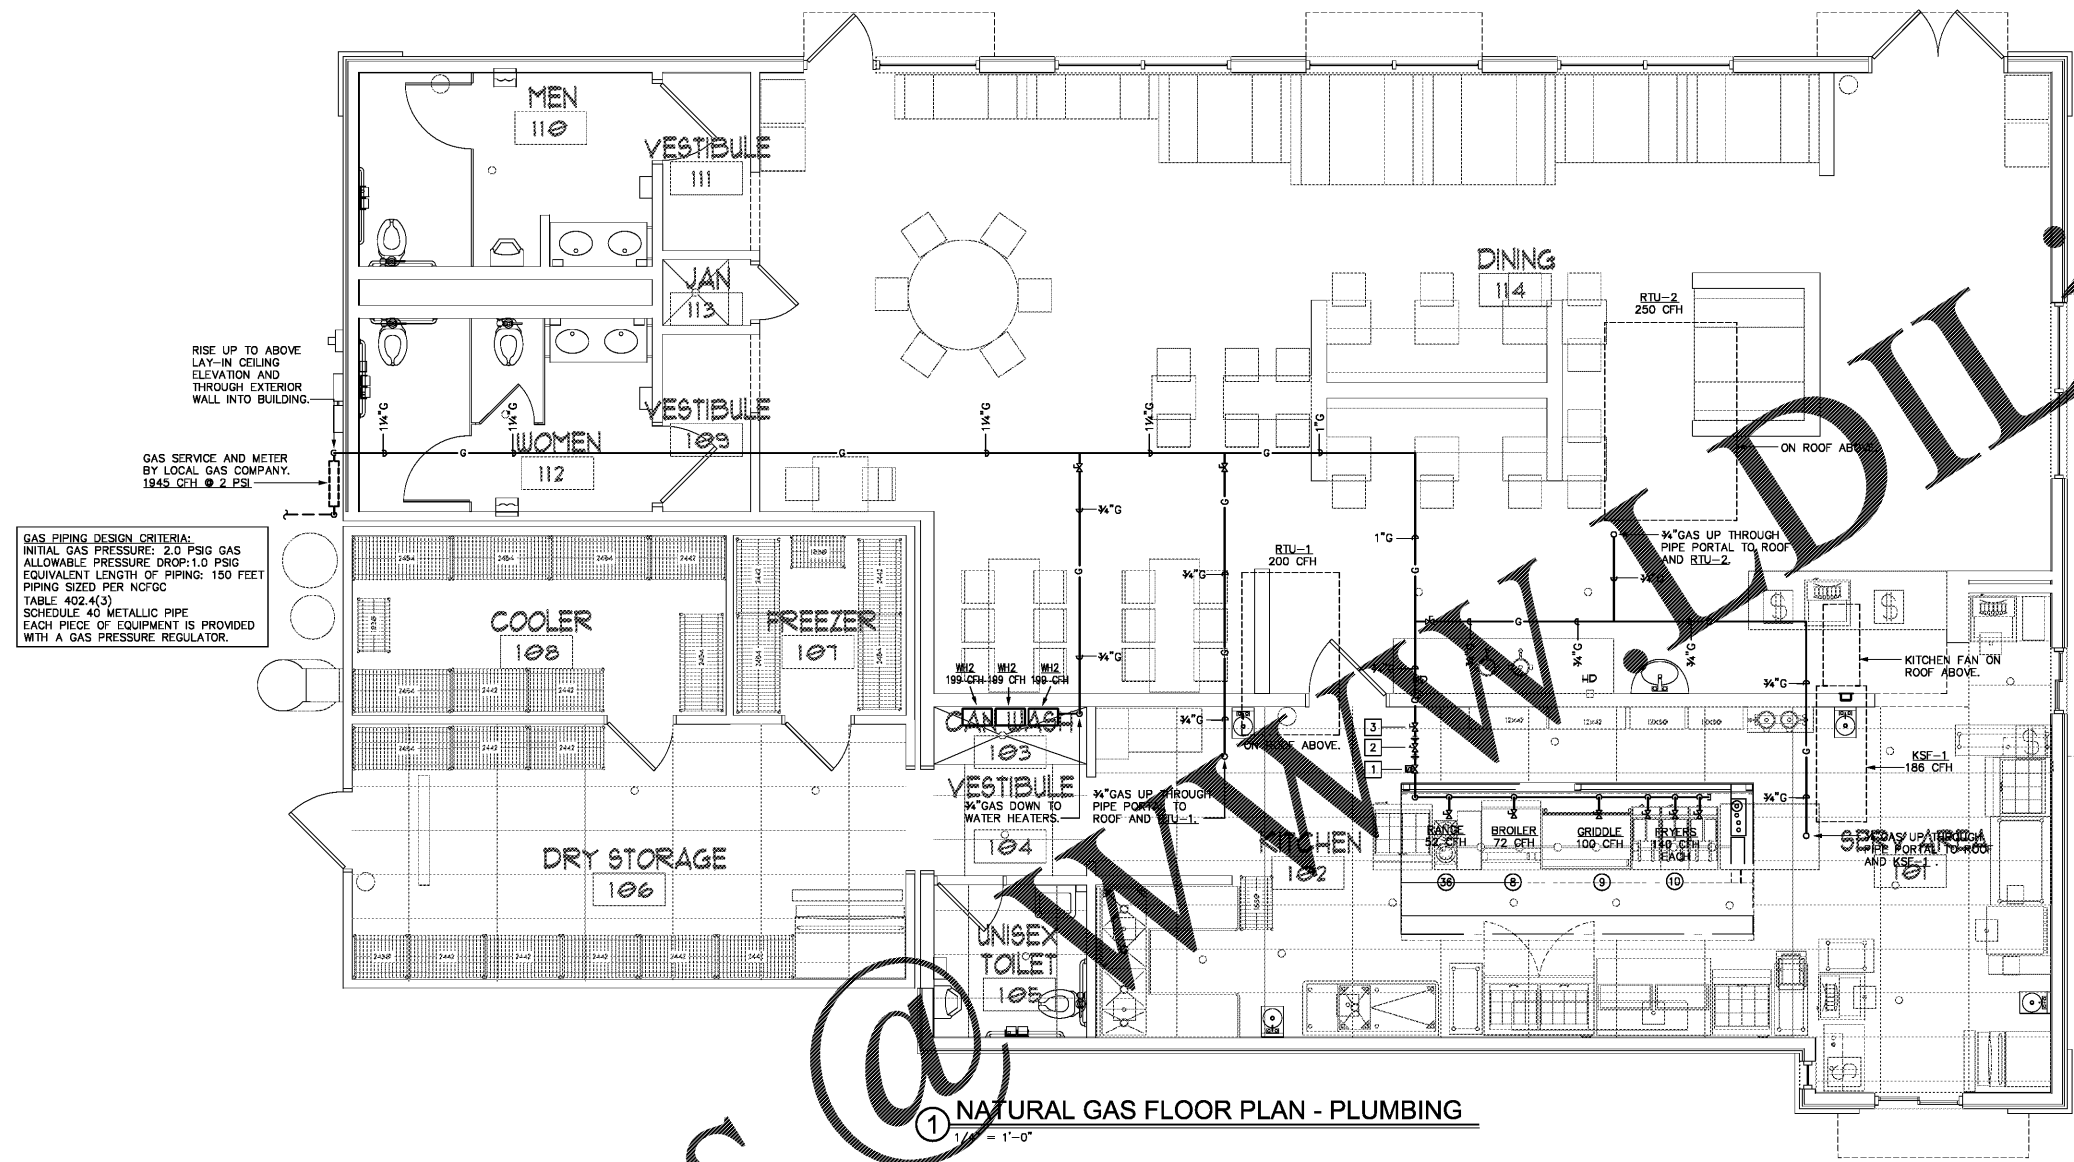

GAS PIPING DESIGN CRITERIA:
 INITIAL GAS PRESSURE: 2.0 PSIG GAS
 ALLOWABLE PRESSURE DROP: 1.0 PSIG
 EQUIVALENT LENGTH OF PIPING: 150 FEET
 PIPING SIZED PER NCFGC
 TABLE 402.4(3)
 SCHEDULE 40 METALLIC PIPE
 EACH PIECE OF EQUIPMENT IS PROVIDED
 WITH A GAS PRESSURE REGULATOR.

1 NATURAL GAS FLOOR PLAN - PLUMBING
 1/8" = 1'-0"

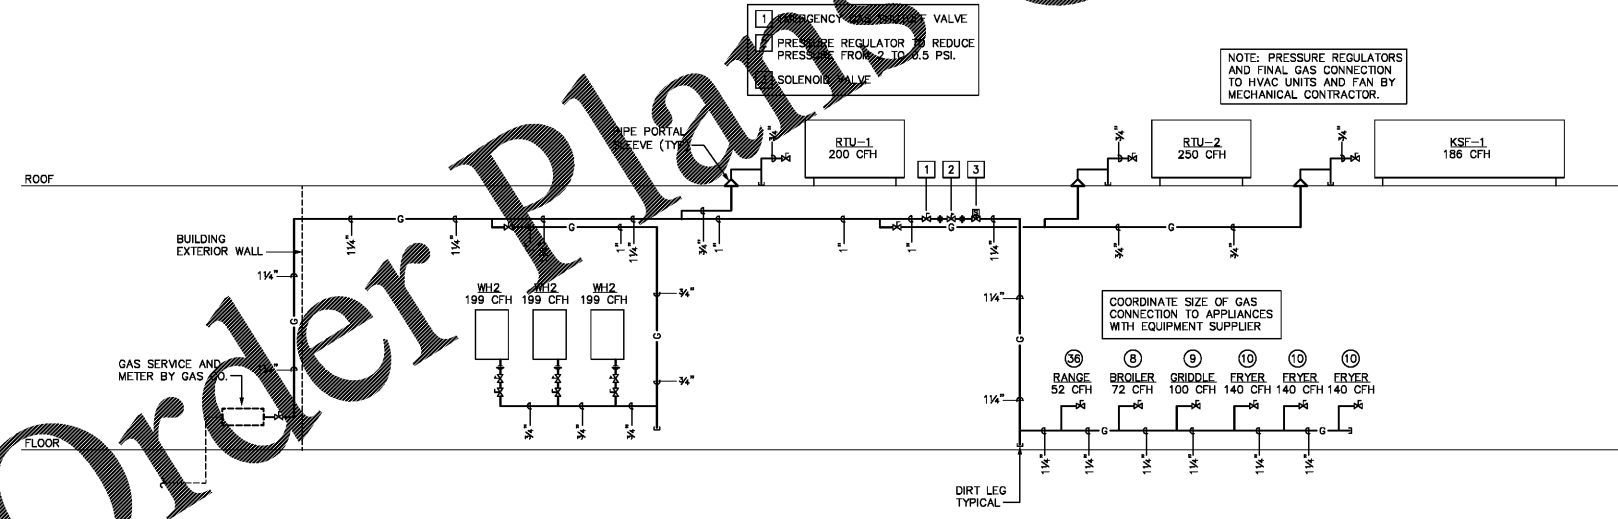

2 NATURAL GAS RISER DIAGRAM
 NO SCALE

KITCHEN EQUIPMENT GAS CONNECTION SCHEDULE

SYM.	DESCRIPTION	SAN	VENT	HW	CW	FW	GAS	REMARKS
(8)	CHAR. GRILL W/STAND (BROILER)	-	-	-	-	-	3/4"	72 CFH
(9)	GRIDDLE W/STAND	-	-	-	-	-	3/4"	100 CFH
(10)	(3) 40 LB. FRYER	-	-	-	-	-	3/4"	140 CFH
(5)	2 BURNER HOT PLATE	-	-	-	-	-	3/4"	52 CFH

NOTES:
 1. PLUMBING CONTRACTOR AND FOOD SERVICE EQUIPMENT SUPPLIER SHALL COORDINATE INSTALLATION OF KITCHEN EQUIPMENT.

Order Plans @