


GENERAL LIGHTING NOTES:

- L1. SEE ARCHITECTURAL PLANS AND COORDINATE WITH OWNER FOR THE EXACT LOCATION OF ALL LIGHTING FIXTURES.
- L2. LIGHTING DESIGN FOR THIS PROJECT ASSUMES 80% REFLECTANCE ON THE CEILING, 50% REFLECTANCE ON THE WALLS AND 20% REFLECTANCE ON THE FLOORS.
- L3. EXIT LIGHTS SHALL NOT BE SWITCHED.
- L4. EXIT, EMERGENCY AND NIGHT LIGHTS SHALL BE CONNECTED TO THE BRANCH CIRCUIT INDICATED. BREAKER SHALL BE EQUIPPED WITH A HANDLE-LOCKING DEVICE. ASSOCIATED BOXES & CONDUIT (EVERY FIVE FEET MINIMUM) SHALL BE PAINTED RED.
- L5. ELECTRICAL CONTRACTOR SHALL VERIFY THAT ALL AREAS IN WHICH FOOD AND/OR DRINKS ARE PREPARED, OR IN WHICH UTENSILS ARE WASHED, SHALL BE PROVIDED WITH AT LEAST 50FC OF LIGHT ON FOOD PREPARATION WORK LEVELS AND AT UTENSILS WASHING WORK LEVELS. AT LEAST 10FC OF LIGHT AT 30 INCHES ABOVE THE FLOOR SHALL BE PROVIDED IN ALL OTHER AREAS, INCLUDING STORAGE ROOMS AND WALK-IN UNITS. LIGHT BULBS IN FOOD PREPARATION, STORAGE, AND DISPLAY AREAS SHALL BE SHATTERPROOF OR SHIELDED SO AS TO PRECLUDE THE POSSIBILITY OF BROKEN BULBS OR LAMPS FALLING INTO FOOD. HEAT LAMPS SHALL BE PROTECTED AGAINST BREAKAGE BY A SHIELD SURROUNDING AND EXTENDING BEYOND THE BULB, LEAVING ONLY THE FACE OF THE BULB EXPOSED.

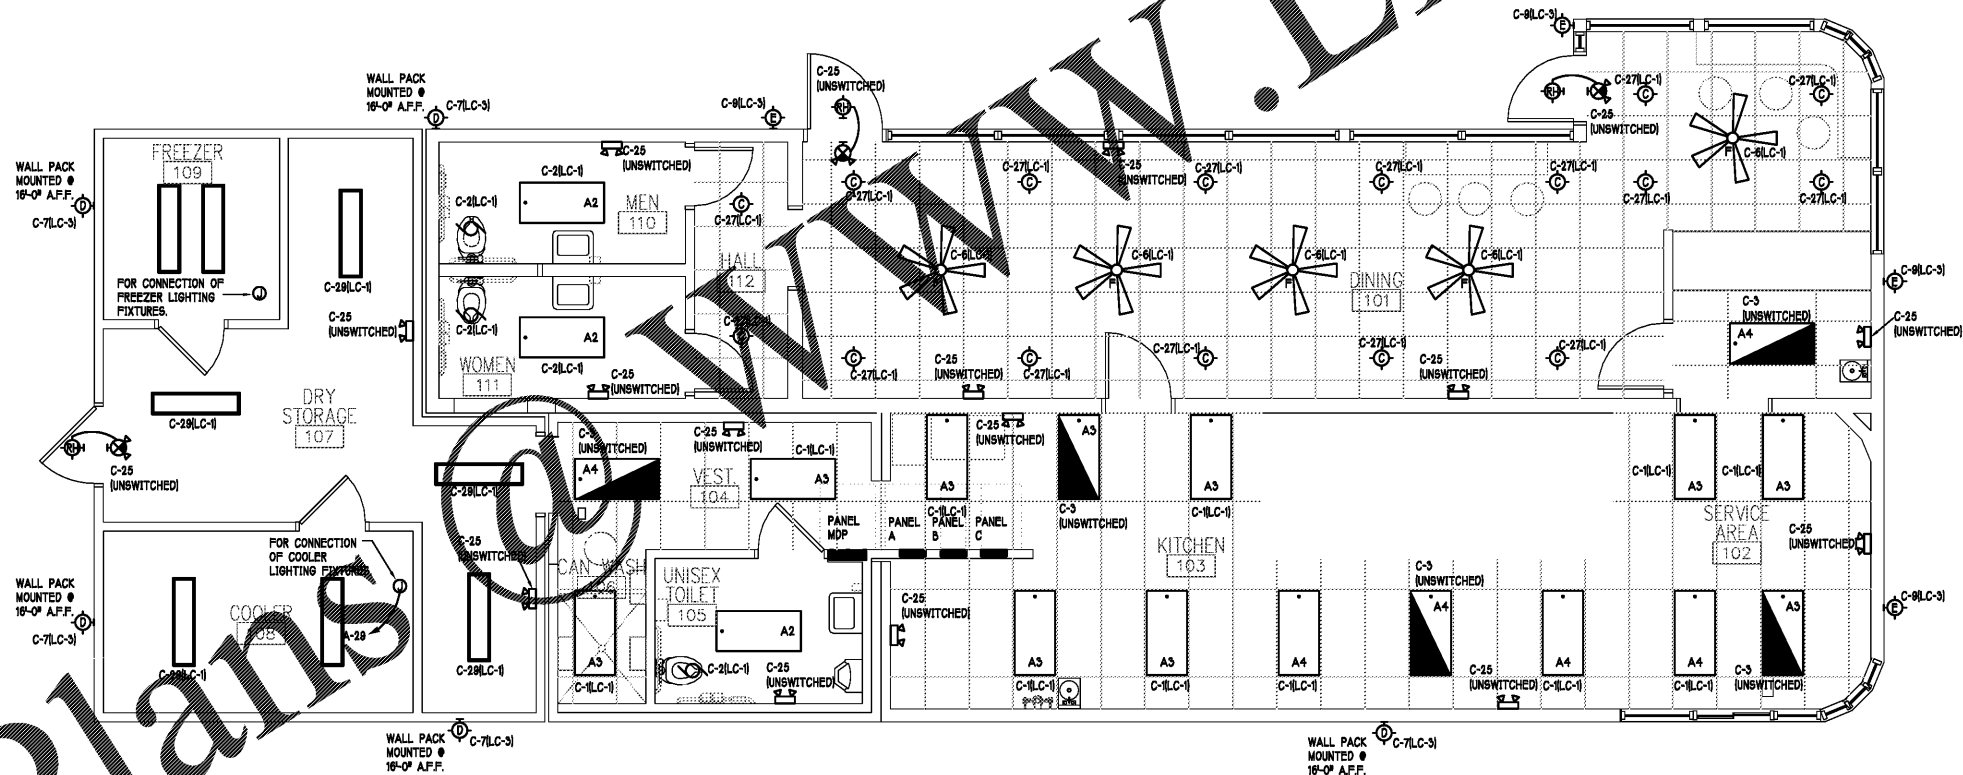


1 ELECTRICAL POWER PLAN
E2 1/4"=1'-0"

Order Plans

WWW.LDILine.com

LINDSEY ARCHITECTURE
125 S. Main Street, Suite 300
Columbus, NC 27401
p. 336.617.4402
f. 336.617.4434
www.lindsayarchitecture.com

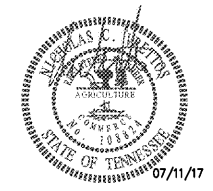

VP ENGINEERING
VRETTOS PAPPAS CONSULTING ENGINEERS, P.A.
193 S.W. 215th St., Lakeland, FL 33853
2815 Colleton Drive, Ste 100, Charleston, SC 29405
194-322-7765 www.vpe.com

COOK OUT
975 W. Poplar Ave.
Columbia, TN

| Mk | Date | Description |
|----|------|-------------|
| | | Revisions |

ELECTRICAL LIGHTING PLAN

Date 07-11-17
Drawn By VOA
Check By DRP
Job No. 17-019-000
Sheet

E3