


LIGHT FIXTURE SCHEDULE

TYPE	DESCRIPTION	MANUFACTURER CATALOG NUMBER	LAMP	NOTES
CW	4' LED STRIP	XVWLED	24W LED	SEE NOTE 1
G	EXTERIOR WALL PACK, WET LOCATION LISTED	LITHONIA DSXW1 LED 20C 1000 40K TFTM MVOLT	75W LED	SEE NOTE 1 & 3
N	EXTERIOR WALL PACK, WET LOCATION LISTED	LITHONIA DSXW1 LED 10C 350 40K T2S MVOLT	14W LED	SEE NOTE 1 & 3
P1	POLE LIGHT (TENON, 25'-0" DIRECT BURIAL POLE)	LITHONIA DSX2 LED 80C 1000 40K T3M MVOLT RPA AST20-280 DDBXD POLE - RTADB 25 7E T20 VD DDB PB062615H1	1-275W LED	SEE NOTE 1, 2, & 3
P2	POLE LIGHT (TENON, 25'-0" DIRECT BURIAL POLE)	LITHONIA DSX2 LED 80C 1000 40K T3M MVOLT RPA AST20-190 DDBXD HS POLE - RTADB 25 7E T20 VD DDB PB062615H1	1-275W LED	SEE NOTE 1, 2, & 3

NOTES:  
 1. NO OTHER SYSTEMS ARE ACCEPTABLE UNLESS REQUESTED AND PRE-APPROVED IN WRITING BY FAMILY DOLLAR STORE.  
 2. PROVIDE IN LINE FUSING IN BASE OF POLE  
 3. ALL EXTERIOR LIGHTS TO BE FULL CUTOFF FIXTURES, NO EXCEPTIONS

STATISTICS						
Description	Symbol	Avg	Max	Min	Max/Min	Avg/Min
OVERALL SITE	+	0.5 fc	12.9 fc	NA	NA	NA
PARKING AREA	*	3.9 fc	12.9 fc	1.6 fc	8.1:1	2.4:1

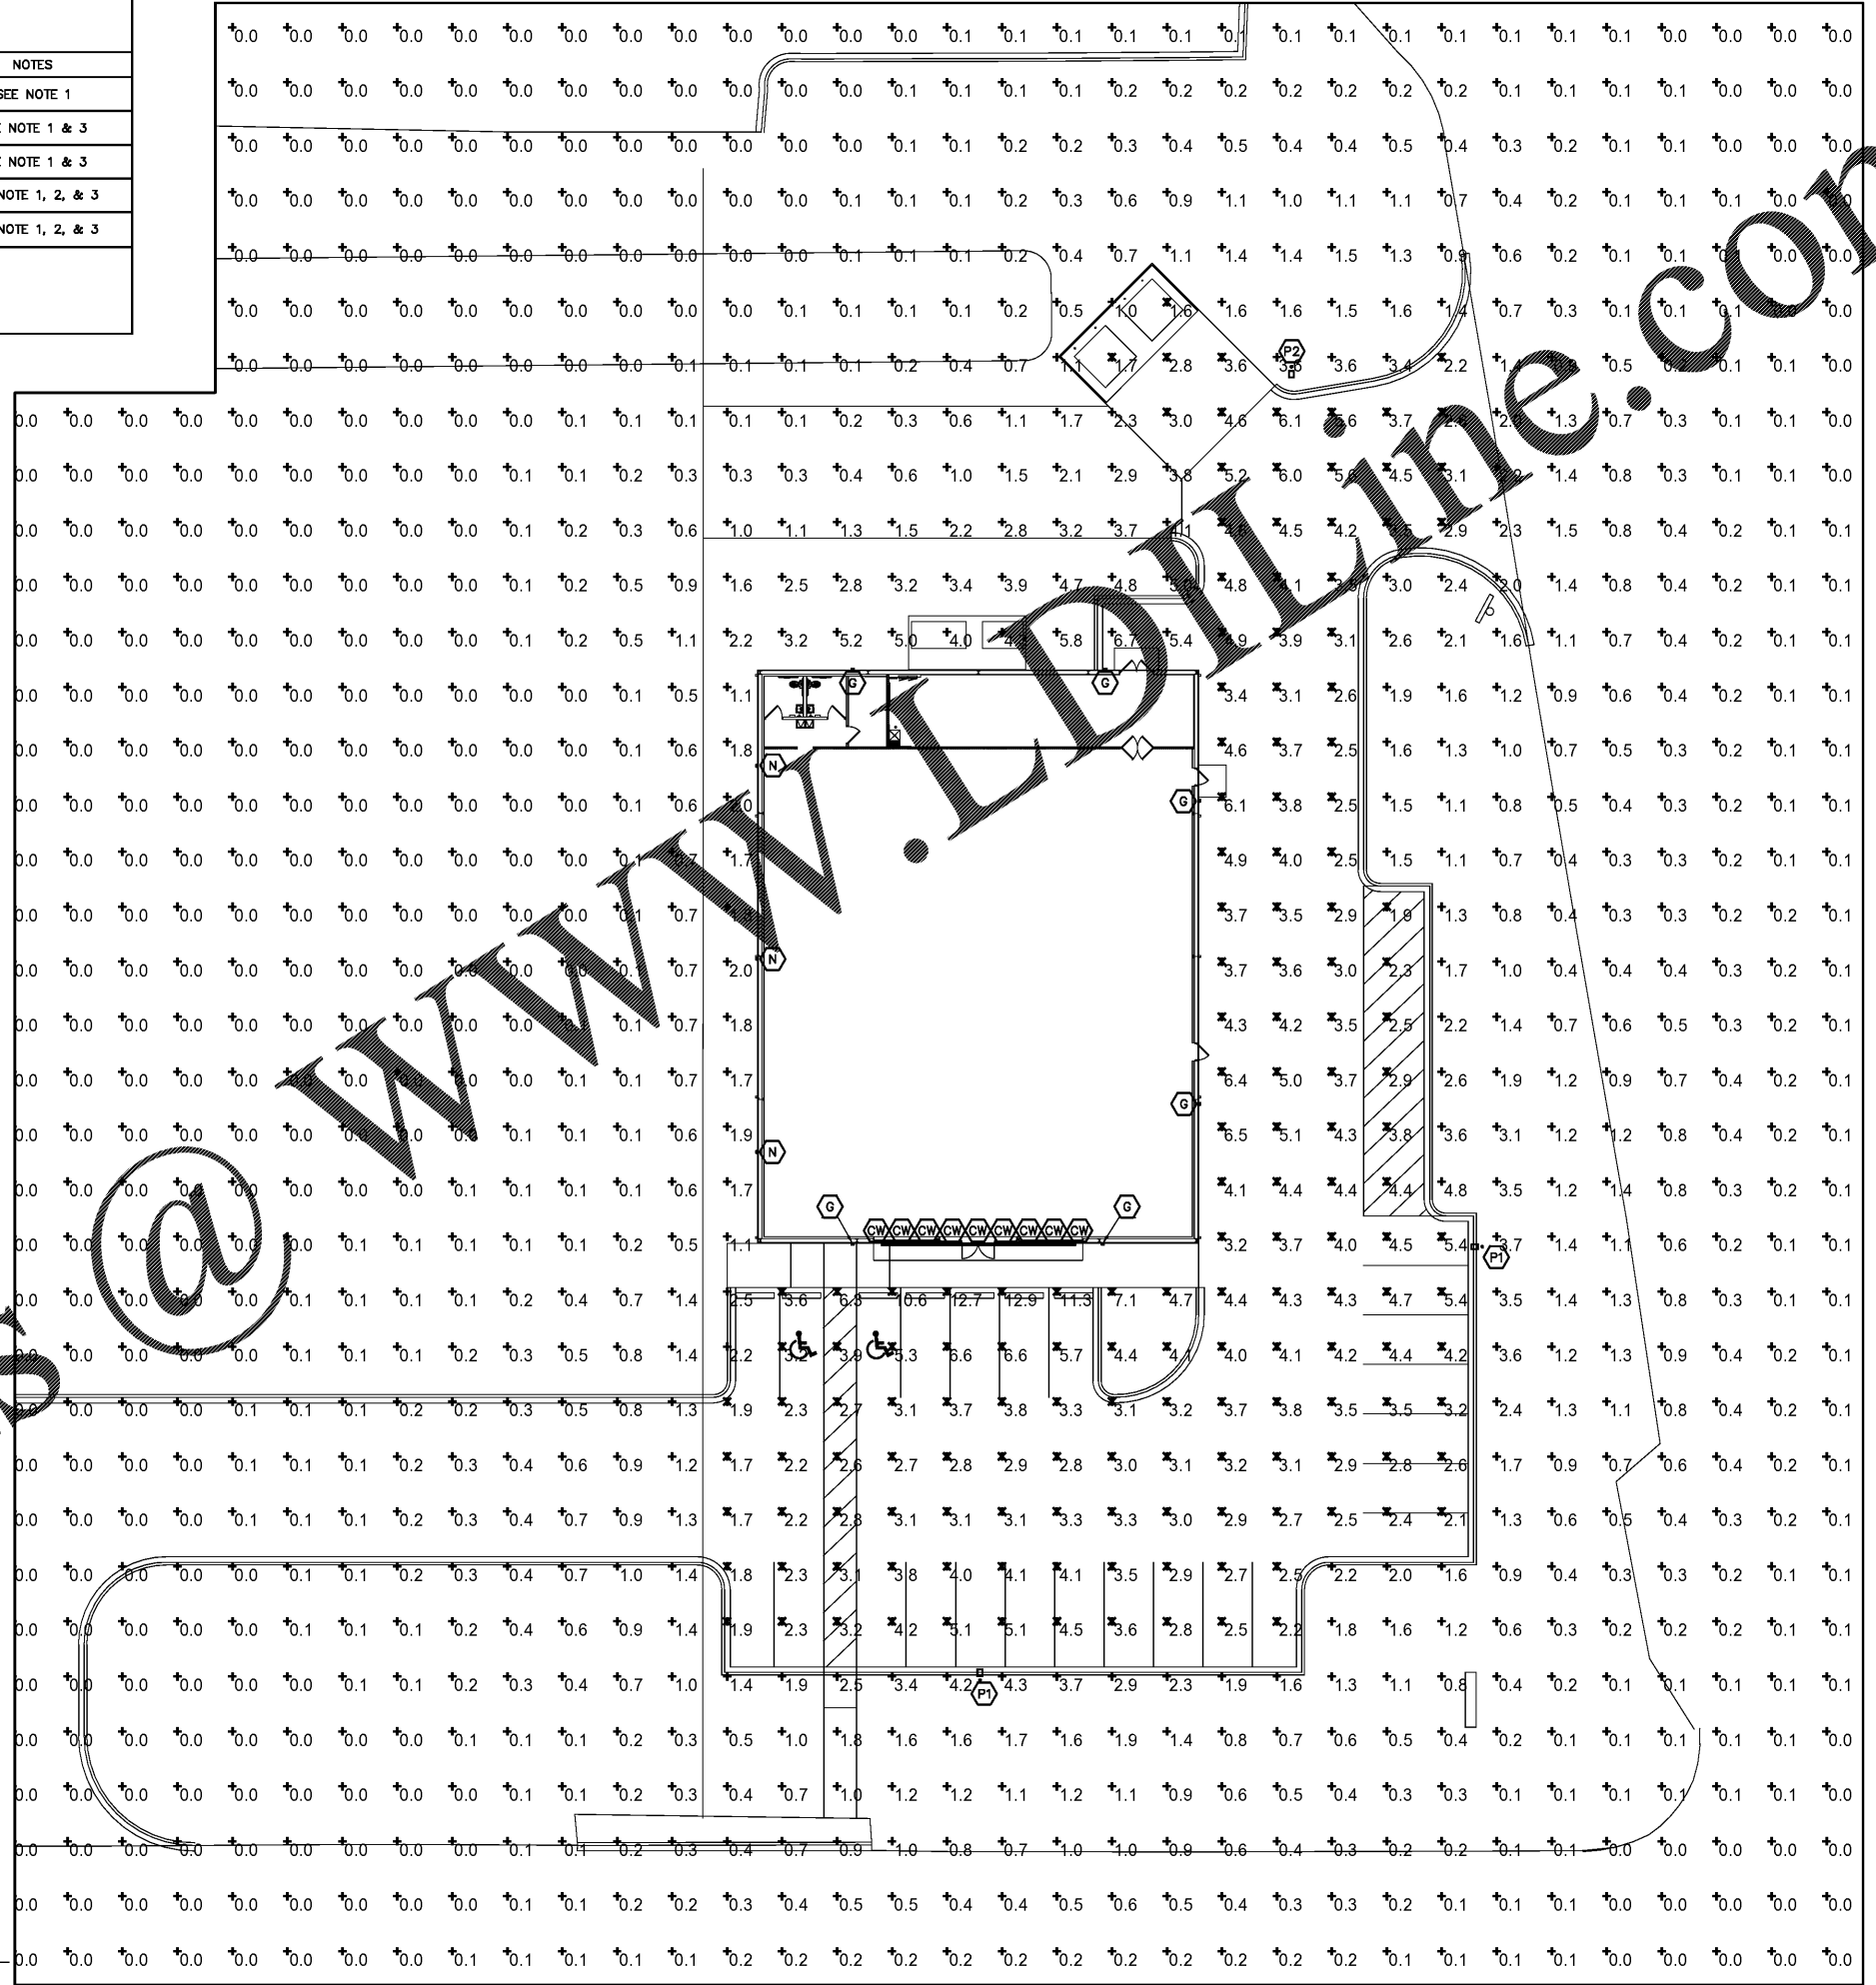



**pb2**  
 architecture  
 + engineering  
 100  
 Alton Avenue Suite 100  
 Greenville, SC 29615  
 Phone: 479.636.3545  
 Fax: 479.636.1209  
 Engineer of Record  
 Keith A. Williams, P.E.  
 South Carolina License No. 25844  
 COA Number: 4672

STIPULATION FOR REUSE  
 THIS DRAWING WAS PREPARED FOR THE EXCLUSIVE USE OF THE CLIENT. IT IS NOT TO BE REPRODUCED, COPIED, OR TRANSMITTED IN ANY FORM OR BY ANY MEANS, ELECTRONIC OR MECHANICAL, INCLUDING PHOTOCOPYING, RECORDING, OR BY ANY INFORMATION STORAGE AND RETRIEVAL SYSTEM, WITHOUT THE WRITTEN PERMISSION OF THE ARCHITECT. ANY REUSE OF THIS DRAWING FOR ANY OTHER PROJECT WITHOUT THE WRITTEN PERMISSION OF THE ARCHITECT IS STRICTLY PROHIBITED. VIOLATION OF THIS STIPULATION MAY BE CAUSAL TO LEGAL ACTION.

**FAMILY DOLLAR STORE**  
 1145 WHITE HORSE RD.  
 GREENVILLE, SOUTH CAROLINA  
 JOB NUMBER: 2017.0123

ISSUE BLOCK	

CHECKED BY: HS  
 DRAWN BY: WQ  
 PROTO CYCLE: 2016-01  
 DOCUMENT DATE: 06.22.17

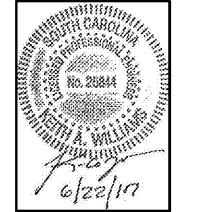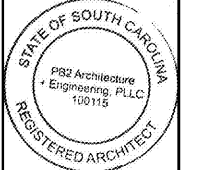

SITE PLAN -  
 PHOTOMETRIC

SHEET: E5.1

PRINTED: 6/22/2017 5:25 PM BY: Travis Spikes LAST SAVED: 4/28/2017 8:21 AM BY: Westonqualls  
 c:\family\_dollar\2017.0123\_greenville\_sc - white\_horse - durham\_drawings\mep\_elec\sheet\e051.dwg

Order Plans @ WWW.LDLINE.COM

1 ELECTRICAL SITE PLAN - PHOTOMETRICS  
 1/16" = 1'-0"