


ALDI Inc. - Virginia Beach, VA

Store No. 161
 4220 Virginia Beach Blvd
 Virginia Beach, VA 23452
 Willis Wayside

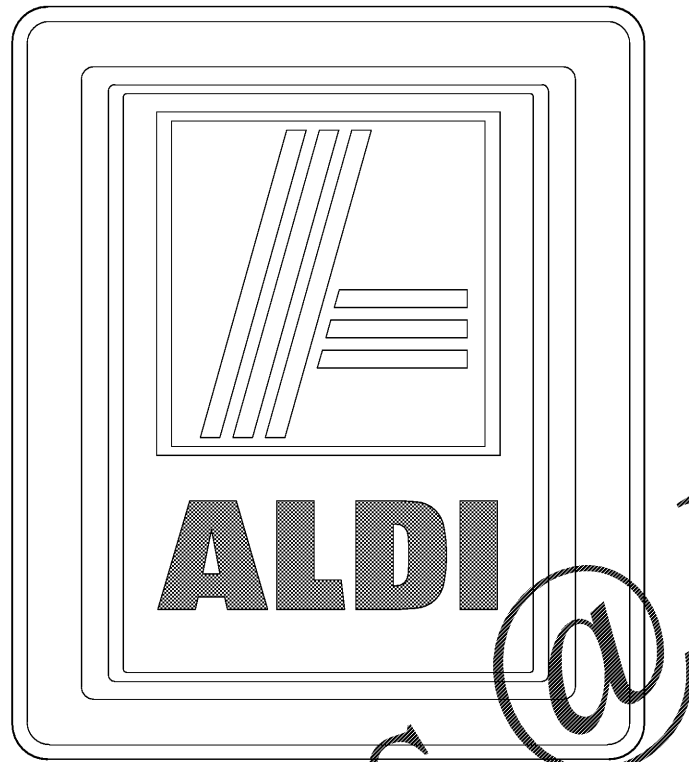

ALDI - Salisbury Division
 1985 Old Union Church Road
 Salisbury, NC 28146

Order Plans @

WWW

Drawing Index

G-001	Cover Sheet	P-401	Plumbing Details
G-002	Code Review	P-501	Plumbing Schedules
G-003	COMcheck		
		FP-101	Fire Protection Floor Plan
D-101	Demolition Plan	FP-201	Fire Protection Legend and Details
		H-101	HVAC Construction Plan
CA-001	Civil Drawings (Refer to Cover Sheet)	H-201	HVAC Legend, Section & Schedules
S-001	General Structural Notes	SE-101	Site Lighting Electrical Plan
S-101	Foundation Plan	E-001	Materials List and Notes
S-102	Slab Plan	E-101	Lighting Plan
S-111	Roof Framing Plan	E-102	Schedules and Diagrams
S-301	Foundation Details	E-201	Electrical Plan
S-302	Foundation Details	E-301	Enlarged Plan
S-303	Foundation Details	E-401	One-line Diagram Schedules & Electrical
S-304	Foundation Details	E-501	Electrical Details
S-401	Steel Framing Sections & Details	CLP-101	Fire Alarm Control Plan
S-402	Steel Framing Sections & Details		
S-403	Steel Framing Sections & Details		
S-404	Steel Framing Sections & Details		
S-405	Steel Framing Sections & Details		
S-406	Steel Framing Sections & Details		
S-407	Steel Framing Sections & Details		
A-001	General Notes, Symbols, & Abbreviations		
A-101	Floor Plans		
A-102	Keyed Notes Plan		
A-111	Refrigerated Ceiling Plans		
A-121	Roof Plans		
A-131	Operating Plan		
A-132	Merchandising Plan		
A-201	Exterior Elevations		
A-211	Interior Elevations		
A-221	Interior Elevations		
A-212	Interior Elevations		
A-214	Interior Elevations		
A-215	Interior Elevations		
A-216	Interior Elevations		
A-301	Wall Sections		
A-302	Wall Sections		
A-303	Wall Sections		
A-304	Wall Sections		
A-305	Wall Sections		
A-306	Wall Sections		
A-401	Enlarged Plans		
A-501	Exterior Details - Section		
A-502	Exterior Details - Section		
A-503	Exterior Details		
A-504	Exterior Details		
A-505	Exterior Details		
A-511	Interior Details - Section		
A-512	Interior Details		
A-513	Interior Details		
A-601	Door Schedules & Details		
A-602	Window Elevations & Details		
A-603	Finish Schedules & Notes		
P-101	Plumbing Floor Plan		
P-102	Plumbing Storm Location Plan		
P-103	Plumbing Drainage Location Plan		
P-201	Enlarged Plumbing Plans		
P-301	Isometric Diagrams		


Deferred Submittals

- Fire Suppression System Drawings
- Fire Alarm System Drawings
- Security System Drawings

Issued:	Date:
A Client Review Set	04/07/17
B Permit Set	04/07/17
C Bid Set	09/05/17
D	
Revisions:	Date:
1	
2	
3	
4	
5	
6	
7	
8	
9	

DO NOT SCALE PLANS

Copying, Printing, Software and other processes required to produce these prints can stretch or shrink the actual paper or layout. Therefore, scaling of this drawing may be inaccurate. Contact your consultants with any need for additional dimensions or clarifications.

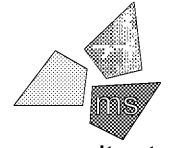

ms consultants, inc.
 engineers, architects, planners
 2221 Schrock Road
 Columbus, Ohio 43229-1547
 phone 614.898.7100
 fax 614.898.7570

DRAWN BY:	MYG
REVIEWED BY:	MJB/CLR

Seal

PROFESSIONAL OF RECORD:
 ERIC ELIZONDO No. 0401016074
 EXP. DATE: 06/30/2018




ALDI Inc. Store #: 161
 VA Beach Blvd & Thalia
 4220 Virginia Beach Blvd
 Virginia Beach, VA 23452
 Willis Wayside
 Project Name & Location:

NOTES

NOTE: THESE DRAWINGS ARE PART OF THE CONTRACT DOCUMENTS AS DESCRIBED IN THE PROJECT MANUAL; IN ANY AND ALL CONFLICTS BETWEEN THE DRAWINGS AND THE TECHNICAL SPECIFICATIONS, THE MOST STRINGENT REQUIREMENT WILL GOVERN AND THE G.C. SHALL COORDINATE WITH THE ALDI REPRESENTATIVE.

DRAWINGS ARE BASED ON ALDI VERSION 7.0 PROTOTYPE RELEASED ON 02.08.17

Project Location

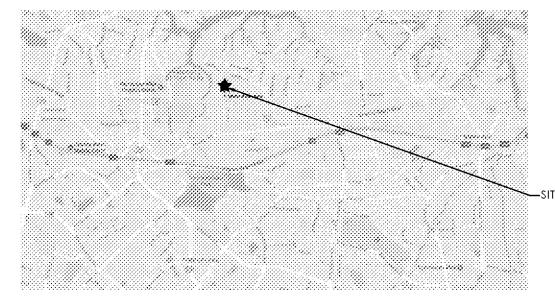

Cover Sheet	
Drawing Name:	
Prototype Rls. 02/08/17	Project No. 40320-40
Type: RHSD-V7	
	G-001
Scale: As Noted	Drawing No.