


PLOTTED: 9/1/2017 1:14 PM

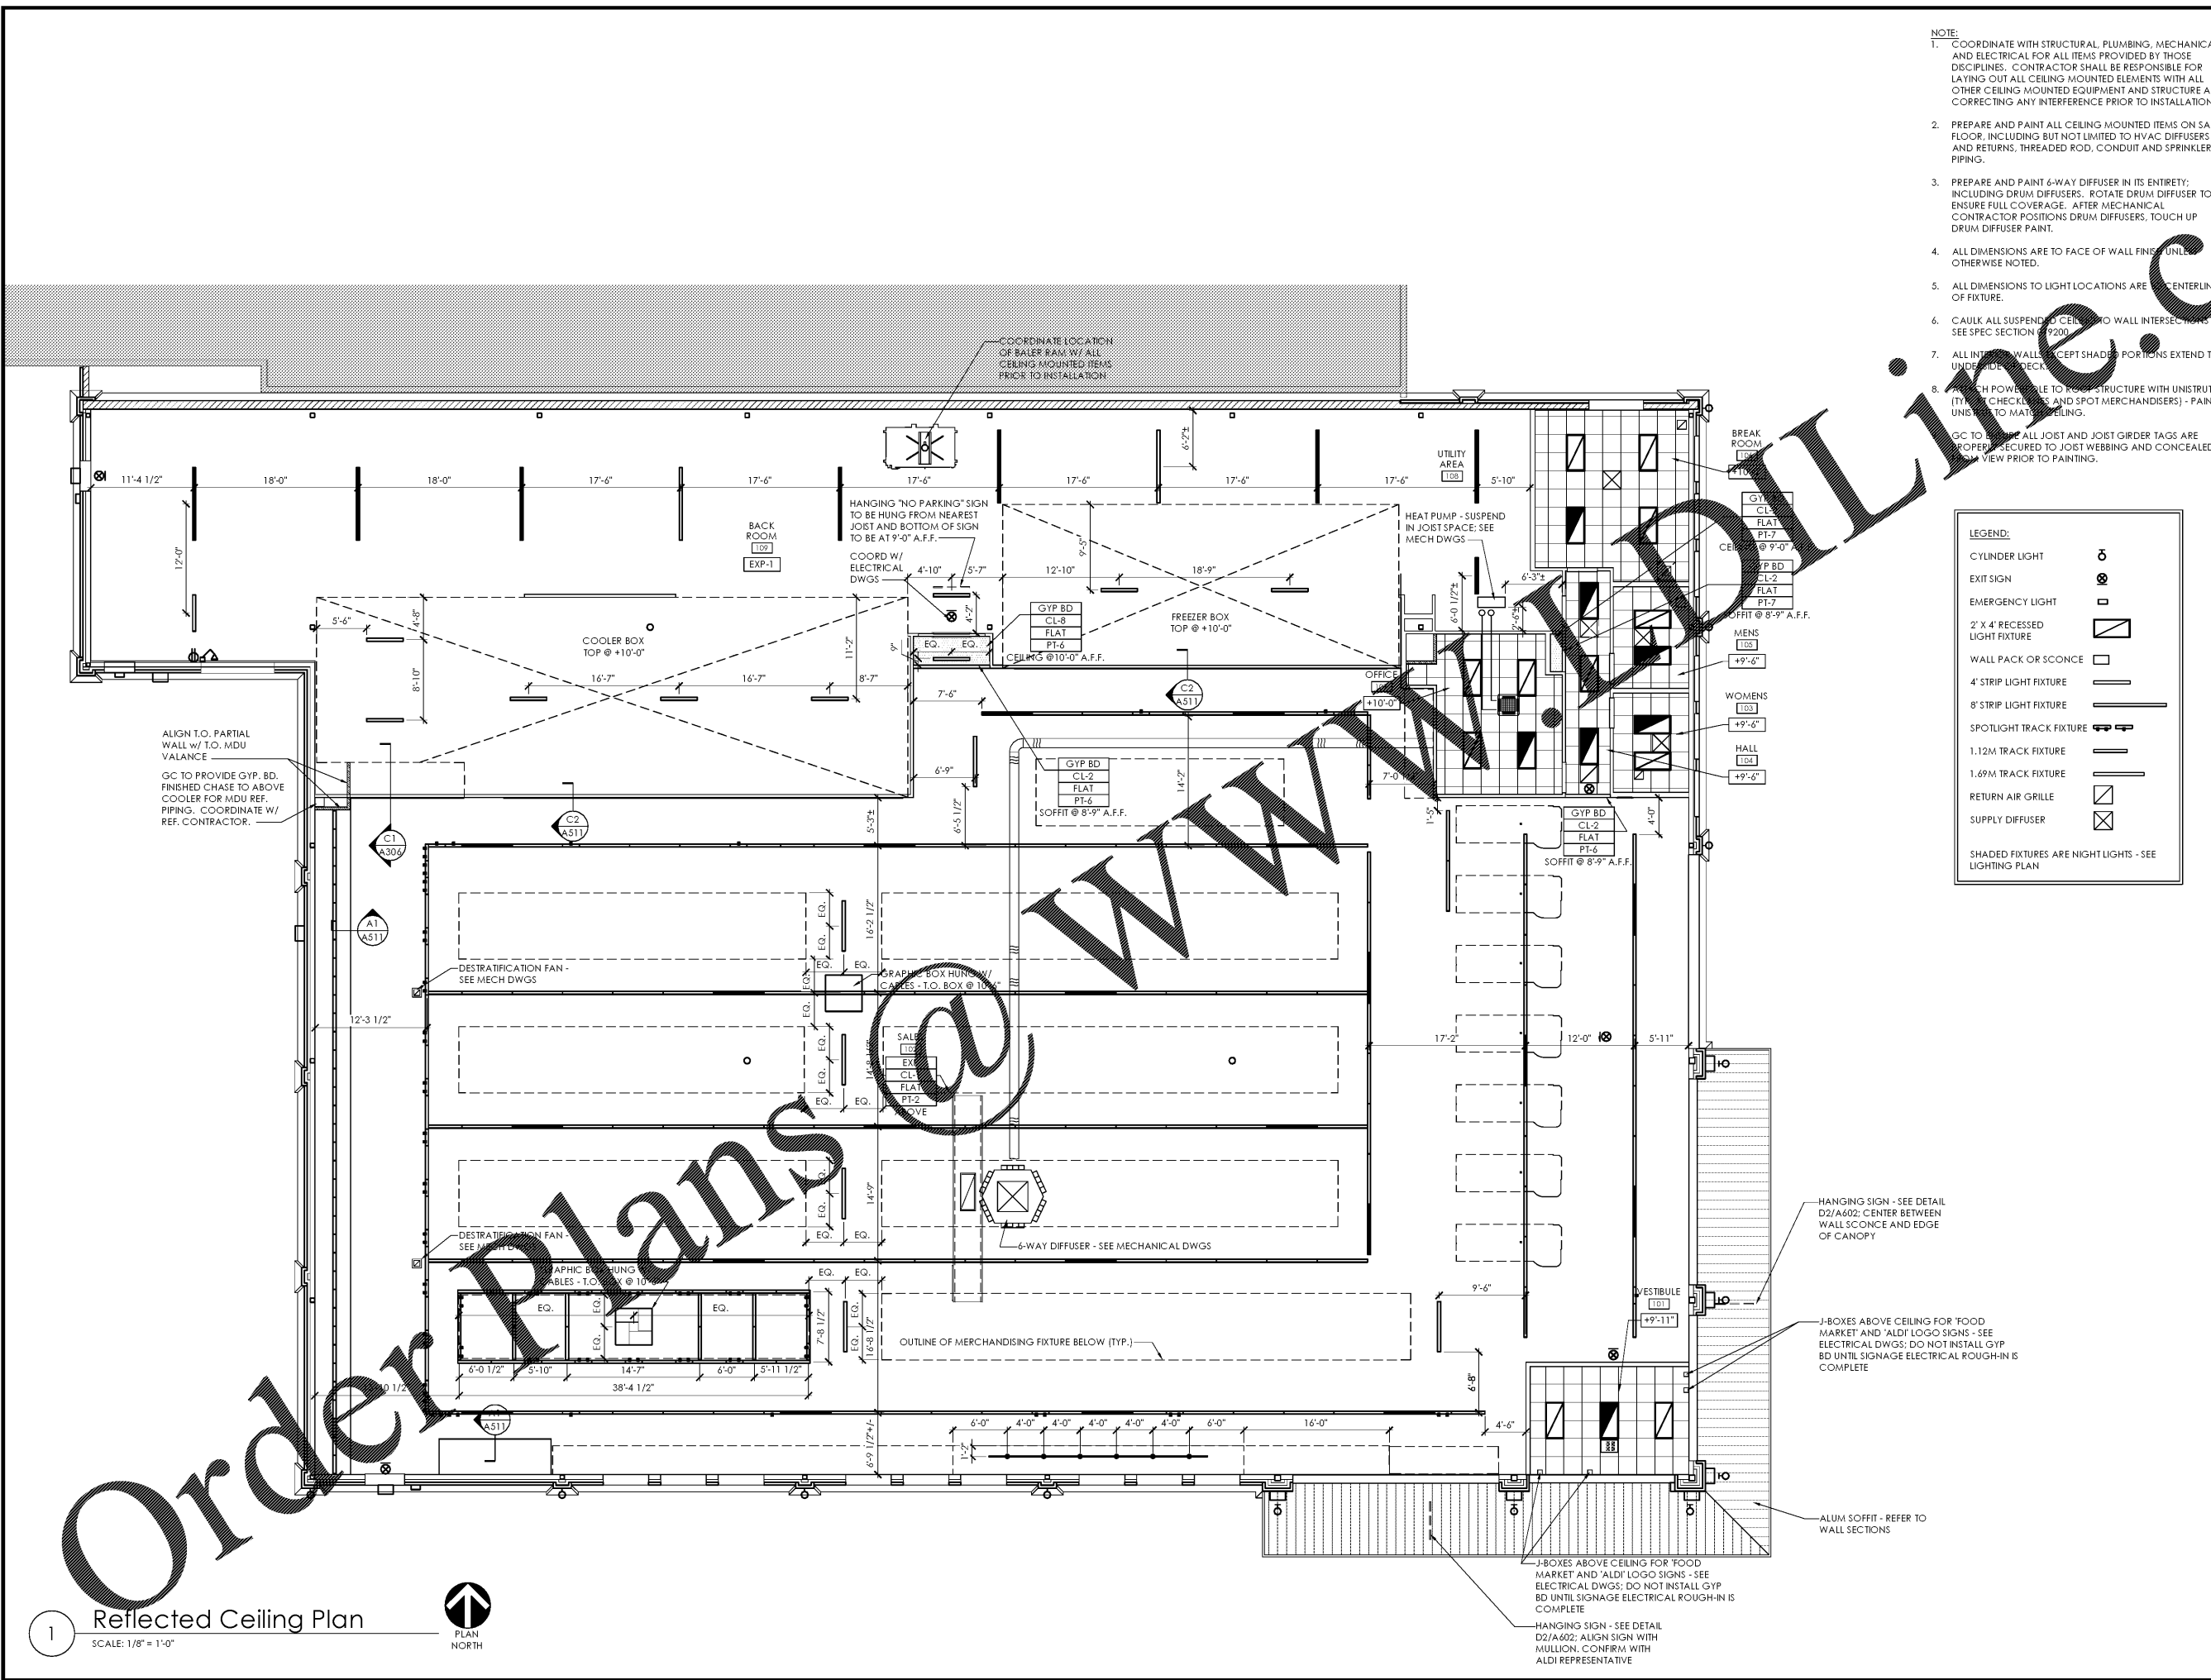

- NOTE:**
- COORDINATE WITH STRUCTURAL, PLUMBING, MECHANICAL AND ELECTRICAL FOR ALL ITEMS PROVIDED BY THOSE DISCIPLINES. CONTRACTOR SHALL BE RESPONSIBLE FOR LAYING OUT ALL CEILING MOUNTED ELEMENTS WITH ALL OTHER CEILING MOUNTED EQUIPMENT AND STRUCTURE AND CORRECTING ANY INTERFERENCE PRIOR TO INSTALLATION.
  - PREPARE AND PAINT ALL CEILING MOUNTED ITEMS ON SALES FLOOR, INCLUDING BUT NOT LIMITED TO HVAC DIFFUSERS AND RETURNS, THREADED ROD, CONDUIT AND SPRINKLER PIPING.
  - PREPARE AND PAINT 6-WAY DIFFUSER IN ITS ENTIRETY, INCLUDING DRUM DIFFUSERS. ROTATE DRUM DIFFUSER TO ENSURE FULL COVERAGE. AFTER MECHANICAL CONTRACTOR POSITIONS DRUM DIFFUSERS, TOUCH UP DRUM DIFFUSER PAINT.
  - ALL DIMENSIONS ARE TO FACE OF WALL FINISH UNLESS OTHERWISE NOTED.
  - ALL DIMENSIONS TO LIGHT LOCATIONS ARE TO CENTERLINE OF FIXTURE.
  - CAULK ALL SUSPENDED CEILING TO WALL INTERSECTIONS - SEE SPEC SECTION 9200.
  - ALL INTERIOR WALLS EXCEPT SHADED PORTIONS EXTEND TO UNDERLIE FLOOR DECK.
  - FINISH POWER POLE TO HANGS STRUCTURE WITH UNISTRUT (IT IS CHECKED AND SPOT MERCHANTISERS) - PAINT UNITS TO MATCH CEILING.
- GC TO VERIFY ALL JOIST AND JOIST GIRDER TAGS ARE PROPERLY SECURED TO JOIST WEBBING AND CONCEALED FROM VIEW PRIOR TO PAINTING.

**LEGEND:**

CYLINDER LIGHT	⊙
EXIT SIGN	⊕
EMERGENCY LIGHT	⊞
2' X 4' RECESSED LIGHT FIXTURE	⊞
WALL PACK OR SCONCE	⊞
4' STRIP LIGHT FIXTURE	—
8' STRIP LIGHT FIXTURE	—
SPOTLIGHT TRACK FIXTURE	—
1.12M TRACK FIXTURE	—
1.69M TRACK FIXTURE	—
RETURN AIR GRILLE	⊞
SUPPLY DIFFUSER	⊞

SHADED FIXTURES ARE NIGHT LIGHTS - SEE LIGHTING PLAN

Issued:	Date:
A Client Review Set	04/07/17
B Permit Set	04/07/17
C Bid Set	09/05/17
D	

Revisions:	Date:
1	
2	
3	
4	
5	
6	
7	
8	
9	

**DO NOT SCALE PLANS**

Copying, Printing, Software and other processes required to produce these prints on a screen or shrink the actual paper or layout. Therefore, scaling of this drawing may be inaccurate. Contact your consultants with any need for additional dimensions or clarifications.

**ms consultants, inc.**  
 engineers, architects, planners  
 2221 Schrock Road  
 Columbus, Ohio 43229-1547  
 phone 614.898.7100  
 fax 614.898.7570

DRAWN BY: MYG  
 REVIEWED BY: MJB/CLR

Seal

PROFESSIONAL OF RECORD:  
 ERIC ELIZONDO No. 0401016074  
 EXP. DATE: 06/30/2018

**ALDI Inc.**  
 1985 Old Union Church Road  
 Salisbury, NC 28146  
 (704) 642-0023  
 (704) 642-0078 fax

ALDI Inc. Store #: 161  
 VA Beach Blvd & Thalia  
 4220 Virginia Beach Blvd  
 Virginia Beach, VA 23452  
 Willis Wayside  
 Project Name & Location:

Reflected Ceiling Plan Drawing Name:	
Prototype Rls. 02/08/17	Project No. 40320-40
Type: RHSD-V7	
Scale: As Noted	Drawing No. A-111

1 Reflected Ceiling Plan  
 SCALE: 1/8" = 1'-0"  
 PLAN NORTH