

Issued:	Date:
A Client Review Set	04/07/17
B Permit Set	04/07/17
C Bid Set	09/05/17
D	


Revisions:	Date:
1	
2	
3	
4	
5	
6	
7	
8	
9	

**GENERAL LIGHTING NOTES:**

1. ALL HEIGHT DIMENSIONS (e.g. +8'-6") ARE FROM THE FINISHED FLOOR TO THE CENTERLINE OF THE DEVICE.
2. REFER TO ARCHITECTURAL REFLECTED CEILING PLAN FOR COORDINATING LUMINARIES WITH CEILING GRID.
3. REFER TO SHEET E-001 FOR THE ELECTRICAL MATERIAL LIST AND GENERAL INSTALLATION NOTES.
4. REFER TO DETAIL D1/E-102 FOR LIGHTING CONTROL AND WIRING DIAGRAM.
5. REFER TO SHEET E-401 FOR SCHEDULE OF FIXTURES FOR PANEL L1.
6. REFER TO DRAWINGS E-102 FOR LIGHTING FIXTURES AND WIRING SCHEDULE.
7. IN AREAS WHERE NO CEILING IS INSTALLED, CONDUIT SHALL BE RUN JUST BELOW ROOF DECK AT BOTTOM OF CHORD OF ROOF JOISTS.
8. EXIT LIGHTING FIXTURES SHALL BE CONNECTED TO THE NIGHT LIGHTING BRANCH CIRCUIT. FIXTURES SHALL NOT BE SWITCHED.
9. EMERGENCY FIXTURES (EM) HAVE EMERGENCY BATTERY BALLAST FACTORY INSTALLED. VERIFY FIXTURE COUNTS AND PLACEMENT OF EMERGENCY FIXTURES PRIOR TO INSTALLATION. NOTIFY ALDI REP OF ANY DISCREPANCIES.

**LIGHTING PLAN KEYNOTES:**

- 11 ROUTE CONDUIT FROM PANEL L1 TO EXTERIOR BUILDING SITE LIGHTING AND SIGN POWER BELOW SLAB. MINIMUM 1 1/2" CONDUIT SHALL BE USED AND CONDUIT SHALL HAVE PROPER LISTINGS FOR LOCATION ACCORDING TO ALL LOCAL CODES AND CURRENT EDITION OF N.E.C. REFER TO KEYNOTES L2 AND L3.
- 12 MINIMUM 1-1/2" SCHEDULE 40 PVC CONDUIT. INSTALL MINIMUM OF 24" BELOW GRADE TO MONUMENT/PYLON SIGN. REFER TO DETAIL FOR CONDUIT TERMINATION AT SIGN. FIELD VERIFY ENTRANCE LOCATION INTO BUILDING TO KEEP RUN AS SHORT AS POSSIBLE.
- 13 MINIMUM 1-1/2" SCHEDULE 40 PVC CONDUIT. INSTALL MINIMUM OF 24" BELOW GRADE TO NEW PARKING LOT LUMINARIES. REFER TO SITE ELECTRICAL PLAN FOR LOCATION. FIELD VERIFY ENTRANCE LOCATION INTO BUILDING TO KEEP RUN AS SHORT AS POSSIBLE.
- 14 VERIFY LOCATION OF CONNECTION TO DOOR LIGHTS WITH REFRIGERATION CONTRACTOR.
- 15 VERIFY LOCATION OF JUNCTION BOX WITH REFRIGERATION CONTRACTOR. CONDUIT AND WIRING CONNECTIONS AND INSTALLATION OF LUMINARIES INSIDE COOLER AND FREEZER BY REFRIGERATION CONTRACTOR. REFER TO KEYNOTE L6.
- 16 FIXTURES SHOWN IN WALK-IN COOLER AND FREEZER SHALL BE FURNISHED BY ELECTRICAL CONTRACTOR AND TURNED OVER TO REFRIGERATION CONTRACTOR FOR INSTALLATION. OCCUPANCY SENSORS FURNISHED AND INSTALLED BY REFRIGERATION CONTRACTOR.
- 17 ALL EMERGENCY LIGHTING FIXTURES (EM) SHALL BE SERVED BY TWO (2) LIGHTING BRANCH CIRCUITS ORIGINATING FROM SAME BRANCH CIRCUIT. FOR NORMAL OPERATION THE CIRCUIT SHALL BE CONNECTED TO THE INDICATED SWITCHED LIGHTING BRANCH CIRCUIT CONTROLLED BY THE CPC OR LOCAL SWITCHING SOURCE. FOR CODE REQUIRED EMERGENCY OPERATION THE CIRCUIT SHALL BE UNSWITCHED AND CONNECTED TO THE PANEL SUCH THAT IN THE EVENT OF A LOSS OF NORMAL POWER THE EMERGENCY BALLAST OPERATES FIXTURE.
- 18 INSTALL LUMINARIES, CONDUIT AND WIRING TO CLEAR OVERHEAD DOOR IN THE OPEN POSITION.
- 19 RECEPTACLE FOR DOCK LIGHT SHALL BE SWITCHED WITH BACKROOM LIGHTS. PROVIDE WOOD BLOCKING BETWEEN STUDS TO SECURELY MOUNT FIXTURE.
- 20 EXTEND CIRCUIT TO EXHAUST FAN EF-1. REFER TO E-301 FOR CONTINUATION.
- 21 CPC SYSTEM REFER TO DETAIL D1/E-102 FOR LIGHTING CONTROL DIAGRAM.
- 22 PROVIDE EXTERIOR EMERGENCY FIXTURE NEAR DOOR FOR EXIT DISCHARGE LIGHTING. REFER TO ARCHITECTURAL ELEVATIONS FOR LOCATIONS.
- 23 PROVIDE DUPLEX RECEPTACLES FOR LED BACKLIT GRAPHIC FRAMES. COORDINATE RECEPTACLE LOCATIONS WITH SIGN VENDOR, G.C. AND ALDI REP. PRIOR TO ROUGH-IN. RECEPTACLES SHALL BE CONNECTED TO CIRCUITS AS INDICATED. REFER TO LIGHTING CONTROL DIAGRAM D1/E-102.
- 24 INSTALL 2" LOW-PROFILE LINEAR COVE FIXTURES FACING UP TO LIGHT BACK WALL GRAPHICS ON TOP OF MDU. SECURE FIXTURES TO GC INSTALLED LIGHT GAUGE HAT CHANNEL WITH FURNISHED MOUNTING CLIPS. REFER TO ARCHITECTURAL SECTION DRAWINGS FOR FIXTURE PLACEMENT. VERIFY QUANTITY OF FIXTURES REQUIRED FOR CONTINUOUS ROW WALL TO WALL.
- 25 PROVIDE CONNECTION OF PRE-FABRICATED HANGING LIGHTED SIGNS TO SALES FLOOR LIGHTING BRANCH CIRCUIT AS INDICATED. COORDINATE LOCATION OF JUNCTION BOX WITH SIGN INSTALLER PRIOR TO ROUGH-IN.
- 26 PROVIDE RECEPTACLES AS NOTED FOR GONDOLA ACCENT LIGHTING. REFER TO ARCHITECTURAL INTERIOR ELEVATIONS FOR RECEPTACLE LOCATIONS AND COORDINATE WITH G.C. PRIOR TO ROUGH-IN. REFER TO LIGHTING CONTROL DIAGRAM D1/E-102.
- 27 MOUNT PRODUCE LIGHTING ASSEMBLY AT 12'-0" A.F.F. TO BUILDING STRUCTURE PER MANUFACTURERS INSTRUCTIONS USING SAMMYS SCREW AND AIRCRAFT CABLE SUPPORT KIT PROVIDED WITH FIXTURES. LIGHTING ASSEMBLY SHALL BE MOUNTED TO AVOID ALL OBSTRUCTIONS. REFER TO REFLECTED CEILING PLAN FOR LOCATIONS.
- 28 MOUNT WINE SALES AREA TRACK TO BOTTOM OF ROOF JOISTS PER MANUFACTURERS INSTRUCTIONS. TRACK SHALL BE MOUNTED TO AVOID ALL OBSTRUCTIONS. COORDINATE LOCATION OF WINE SALES AREA WITH OPERATIONS PLAN AND ALDI REP. PRIOR TO ROUGH-IN.

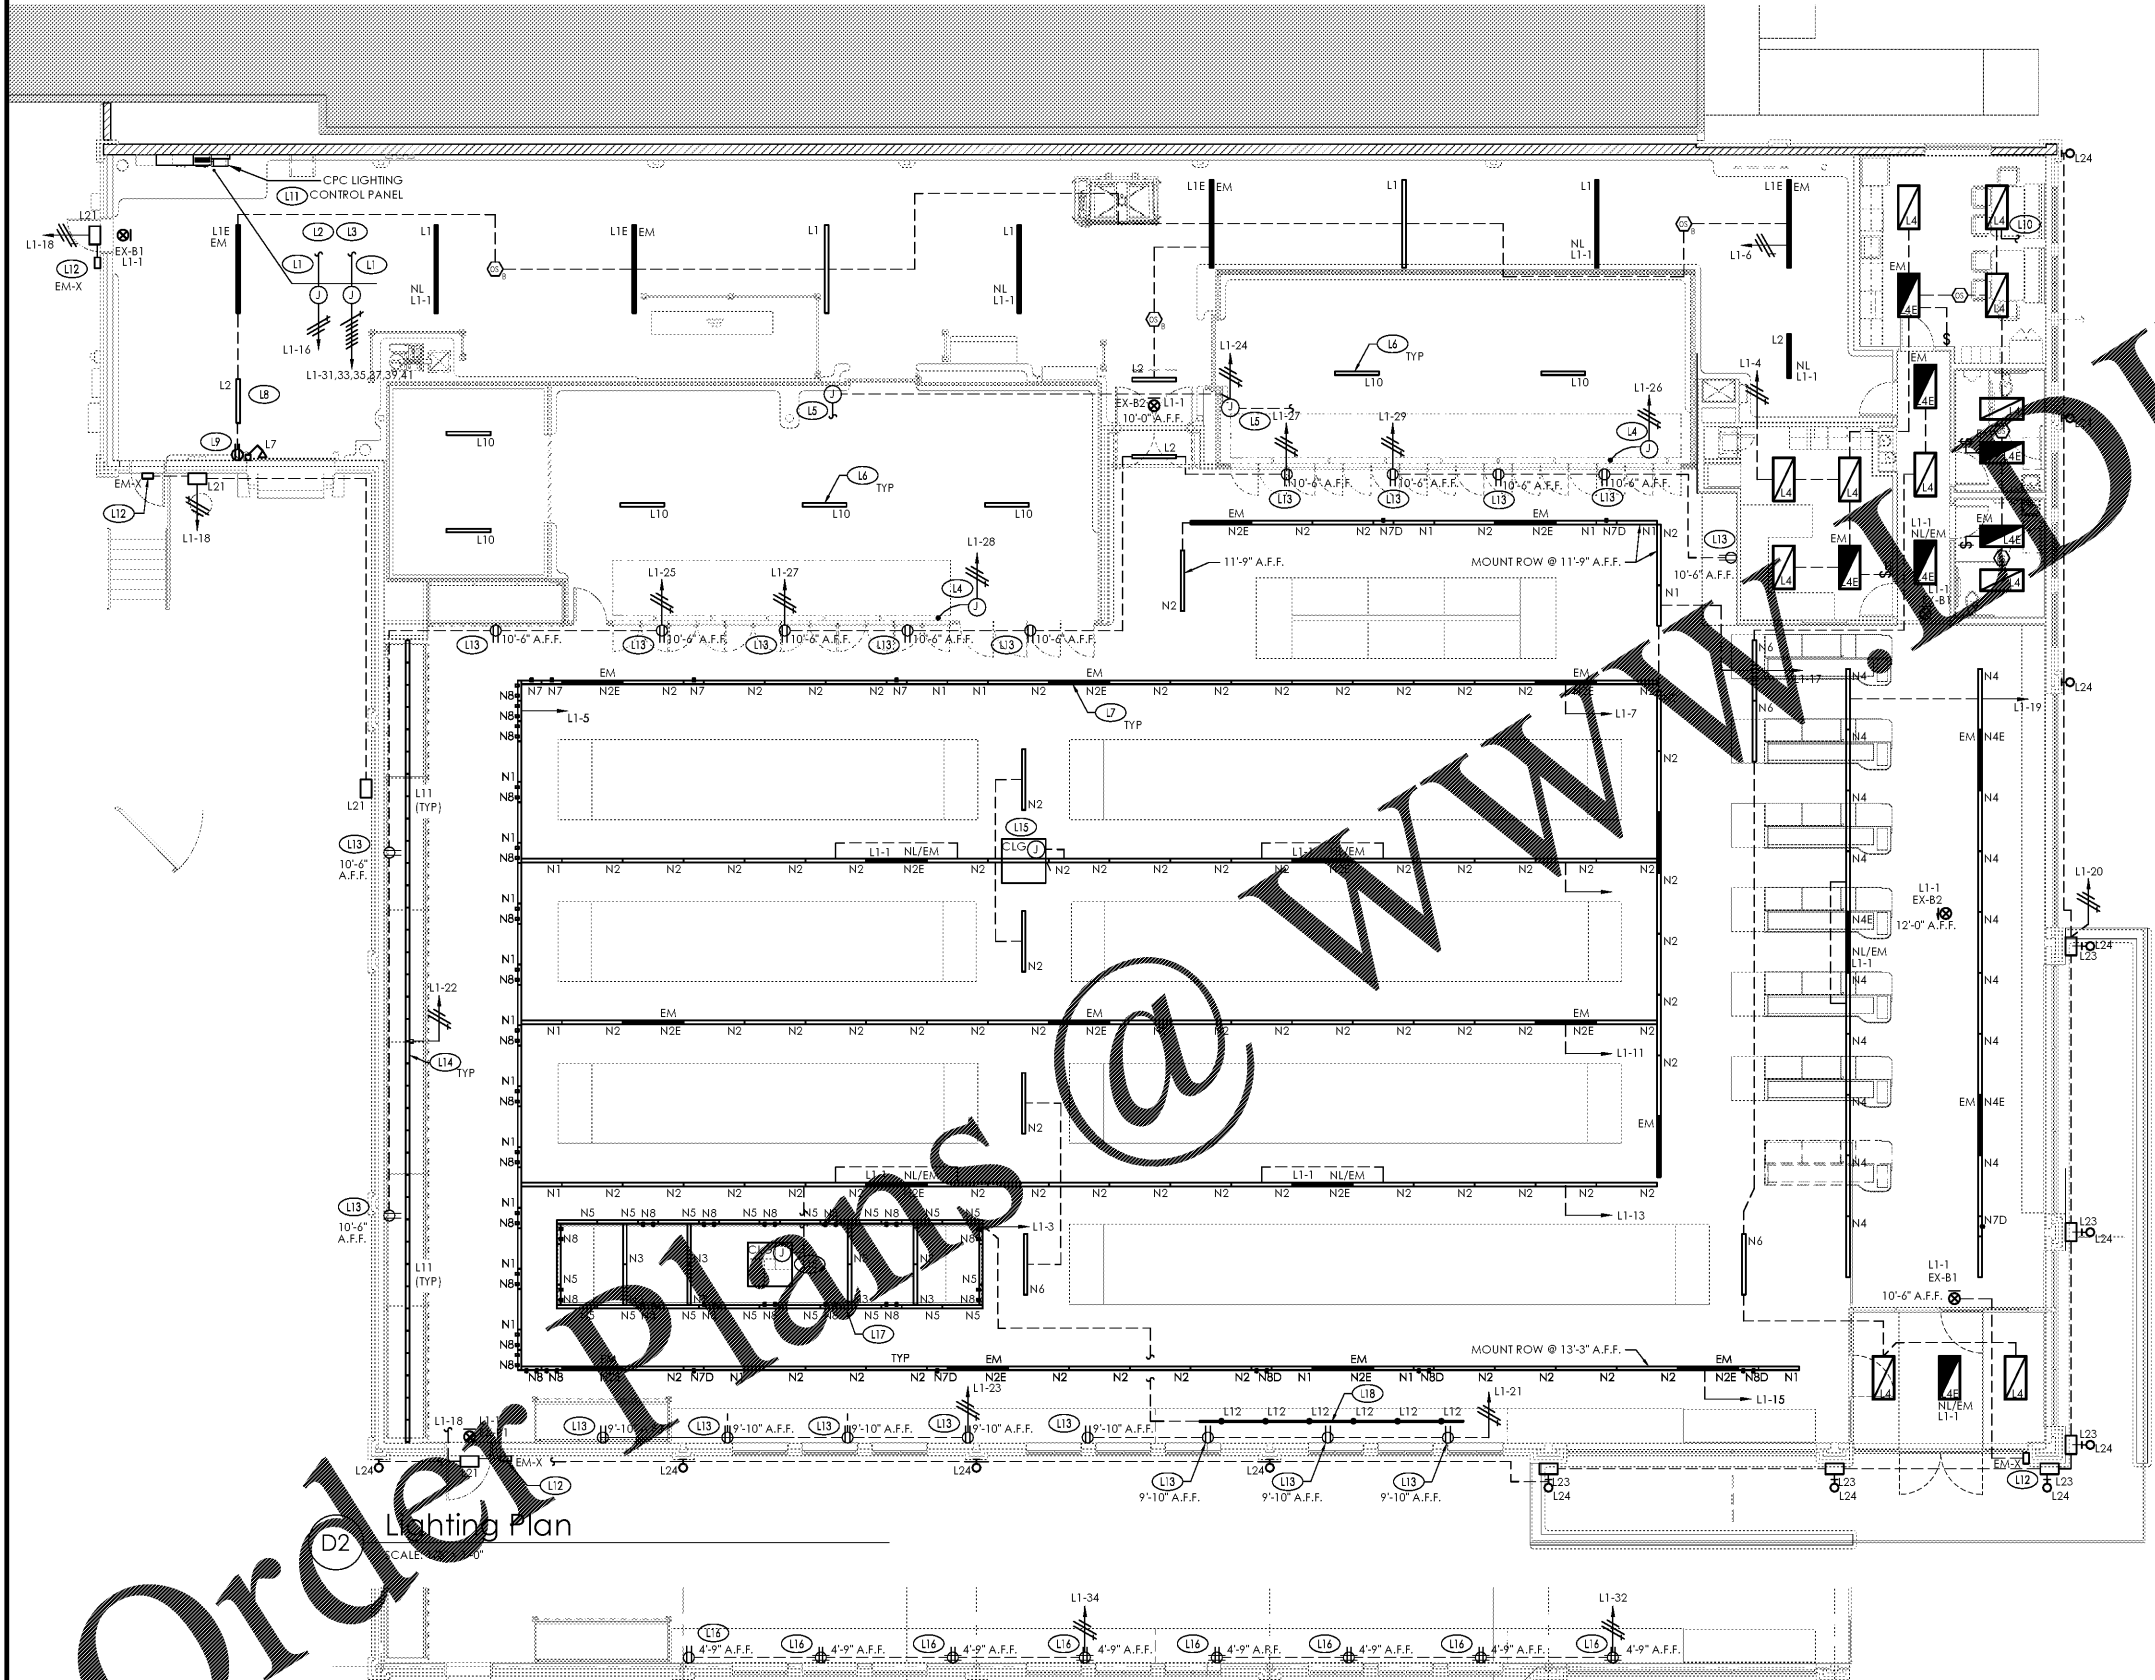

D2 Lighting Plan  
SCALE: 1/8" = 1'-0"

D1 Partial Plan (Gondola Lighting Receptacles)  
SCALE: 1/8" = 1'-0"



Order Plans @ WWW.ALDIline.com

PLOTTED: 9/1/2017 1:33 PM

**DO NOT SCALE PLANS**  
Copying, Printing, Software and other processes required to produce these prints on the job or shrink the actual paper or layout. Therefore, scaling of this drawing may be inaccurate. Contact us consultants with any need for additional dimensions or clarifications.

**ms consultants, inc.**  
engineers, architects, planners  
2221 Schrock Road  
Columbus, Ohio 43229-1547  
phone 614.898.7100  
fax 614.898.7570

DRAWN BY: ZRD  
REVIEWED BY: KFF/DED

Seal  
PROFESSIONAL OF RECORD:  
DANIEL E. DOWLER No. 0402054658  
EXP. DATE: 02/28/2019

**ALDI Inc.**  
1985 Old Union Church Road  
Salisbury, NC 28146  
(704) 642-0023  
(704) 642-0078 fax

ALDI Inc. Store #: 161  
VA Beach Blvd & Thalia  
4220 Virginia Beach Blvd  
Virginia Beach, VA 23452  
Willis Wayside  
Project Name & Location:

Lighting Plan	
Drawing Name:	
Prototype Rls. 02/08/17	Project No. 40320-40
Type: RHSD-V7	
	E-101
Scale: As Noted	Drawing No.