


Order Plans

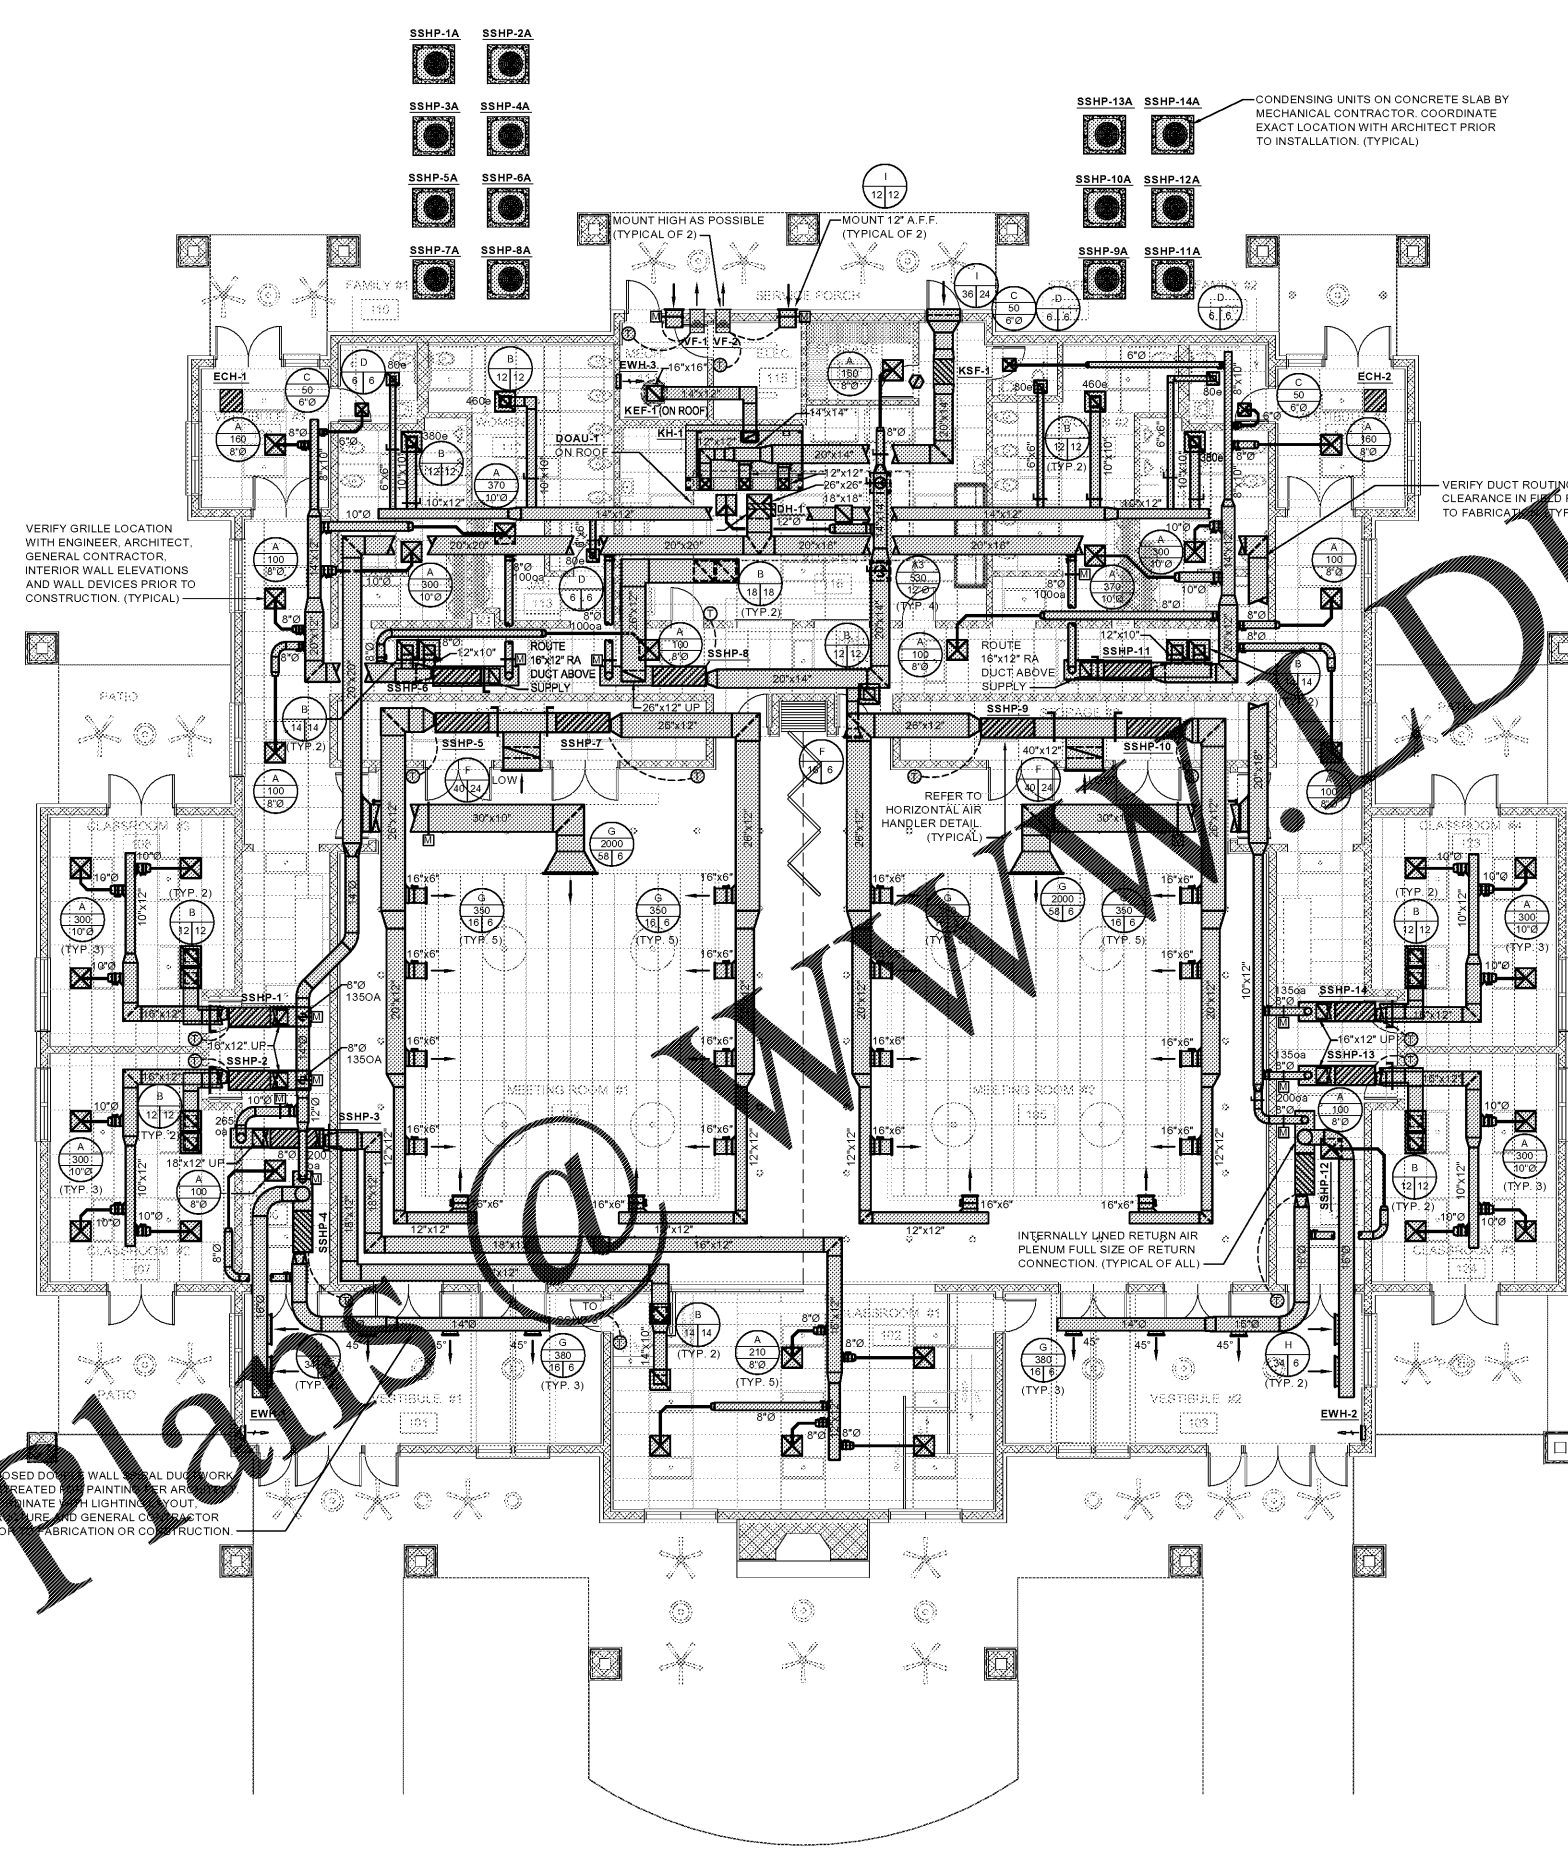



MECA
Mechanical Engineering
Consulting Associates, Inc.

Columbia Office
P.O. Box 50644
Columbia, South Carolina
Phone: (803) 722-1111

Charleston Office
1515 S. Green Lane
Wando, South Carolina
Phone: (803) 798-8866

Jacksonville Office
1725 Silver Street
Jacksonville, Florida 32206
Phone: (904) 494-6300

Designed: TAS
Approved: PPC
Job No.: 116226
Plot Date: 08/14/17

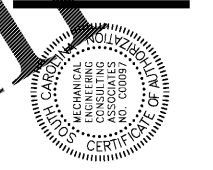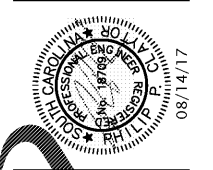

McCreech/Snow Architects, PA
Architects and Planners

1725 Silver Street
Columbia, SC 29206
Phone: (803) 771-2887
www.mccreech.com

Overall Mechanical Floor Plan
Pinewood Community Bldg.
Richland County
Old Garners Ferry Road
Columbia, SC 29209

Drawn: -	Checked: -
Revised: -	
File: -	Project No.: #####

1 Overall Mechanical Floor Plan
m1.1 Scale: 1/8" = 1' - 0"

