
 


Order Plans @

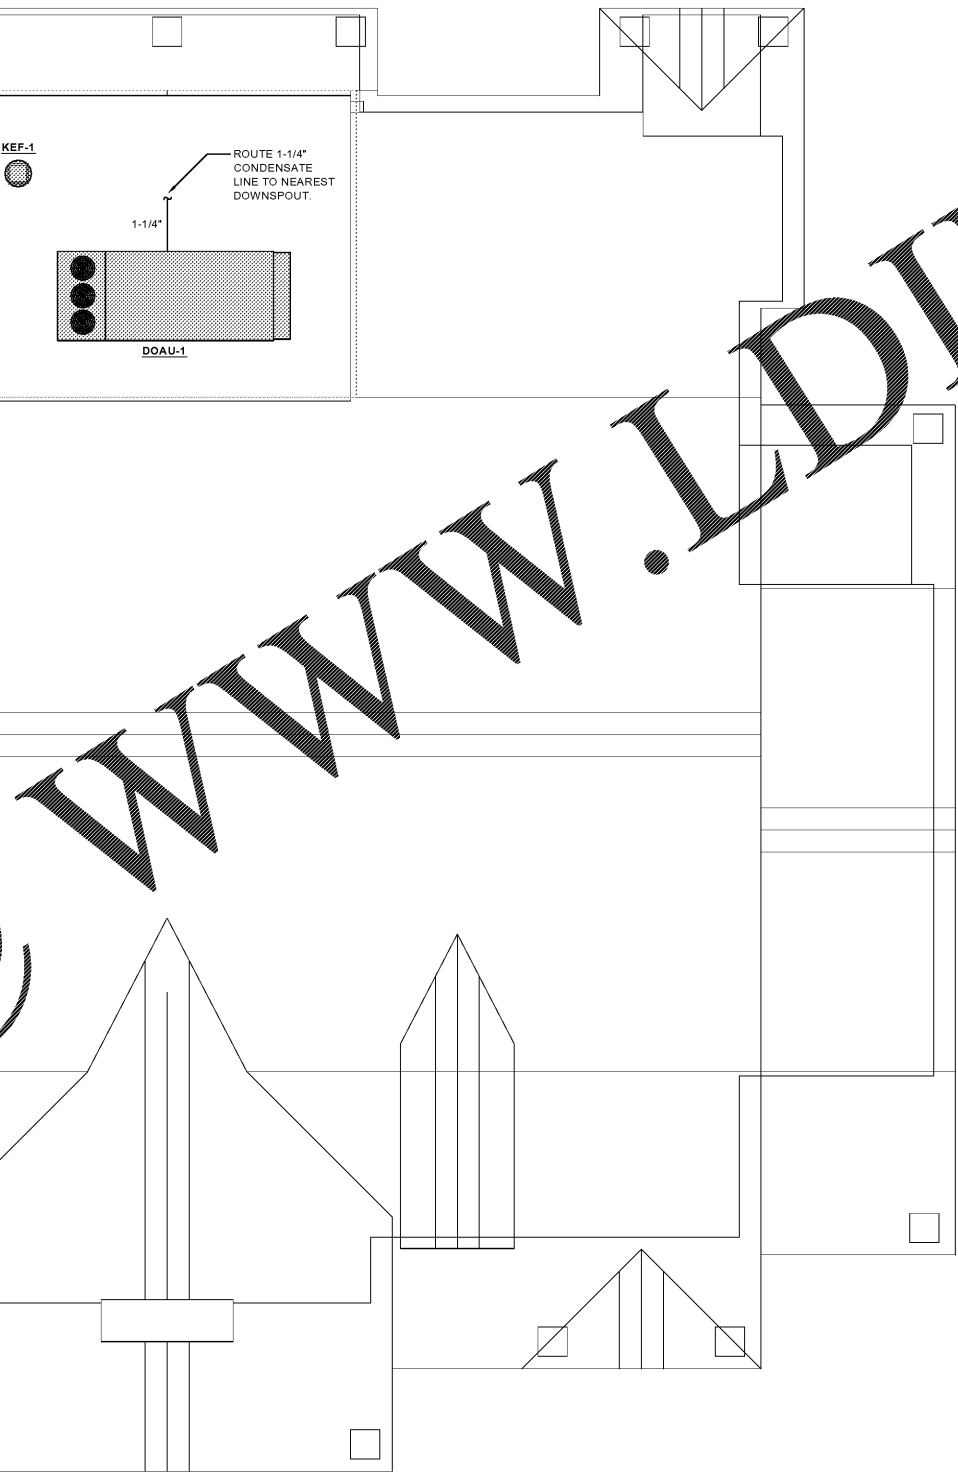

1 Overall Mechanical Roof Plan  
m1.2 Scale: 1/8" = 1' - 0"




**MECA**  
Mechanical Engineering  
Consulting Associates, Inc.

Columbia Office  
P.O. Box 50644  
Columbia, South Carolina  
Phone: (803) 762-1111

Charleston Office  
4515 Fessenden Lane  
Wando, South Carolina  
Phone: (803) 762-1111

Jacksonville Office  
1725 Silver Street  
Jacksonville, Florida 32206  
Phone: (904) 494-6300

Designed: TAS  
Approved: PPC  
Job No.: 116226  
Plot Date: 08/14/17

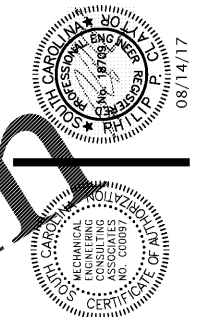

McCreary/Snow Architects, PA  
Architects and Planners  
P.O. Box 11143  
Columbia, South Carolina 29211  
803.771.2287  
csm@mcmech.com

Overall Mechanical Roof Plan  
Pinewood Community Bldg.  
Richland County  
Old Garners Ferry Road  
Columbia, SC 29209

File date: 8/14/2017

Construction Documents

Drawn: -	Checked: -
Revised: -	
File: -	Project No.: #####

m1.2  
Sheet Number  
February 6, 2017  
Date