




Columbia Office
 P.O. Box 50644
 Columbia, South Carolina
 Phone: (803) 732-3131

Charleston Office
 4515 Sassen Lane
 Wando, South Carolina
 Phone: (803) 732-3131

Jacksonville Office
 1725 Silver Street
 Jacksonville, Florida 32206
 Phone: (904) 494-6300

Designed: TAS
 Approved: PPC
 Job No.: 116226
 Plot Date: 08/14/17

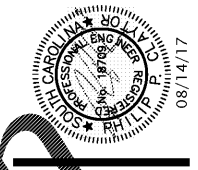


McCreech/Snow Architects, PA
 Architects and Planners
 11143 Old Highway 101, Suite 200
 Richland, SC 29211
 803.777.8287
 csm@mcmech.com

Overall Mechanical Piping Floor Plan
 Pinewood Community Bldg.
 Richland County
 Old Garners Ferry Road
 Columbia, SC 29209

Drawn: -
 Revised: -
 Checked: -
 File: -
 Project No.: #####

m1.3
 Sheet Number
 February 6, 2017
 Date

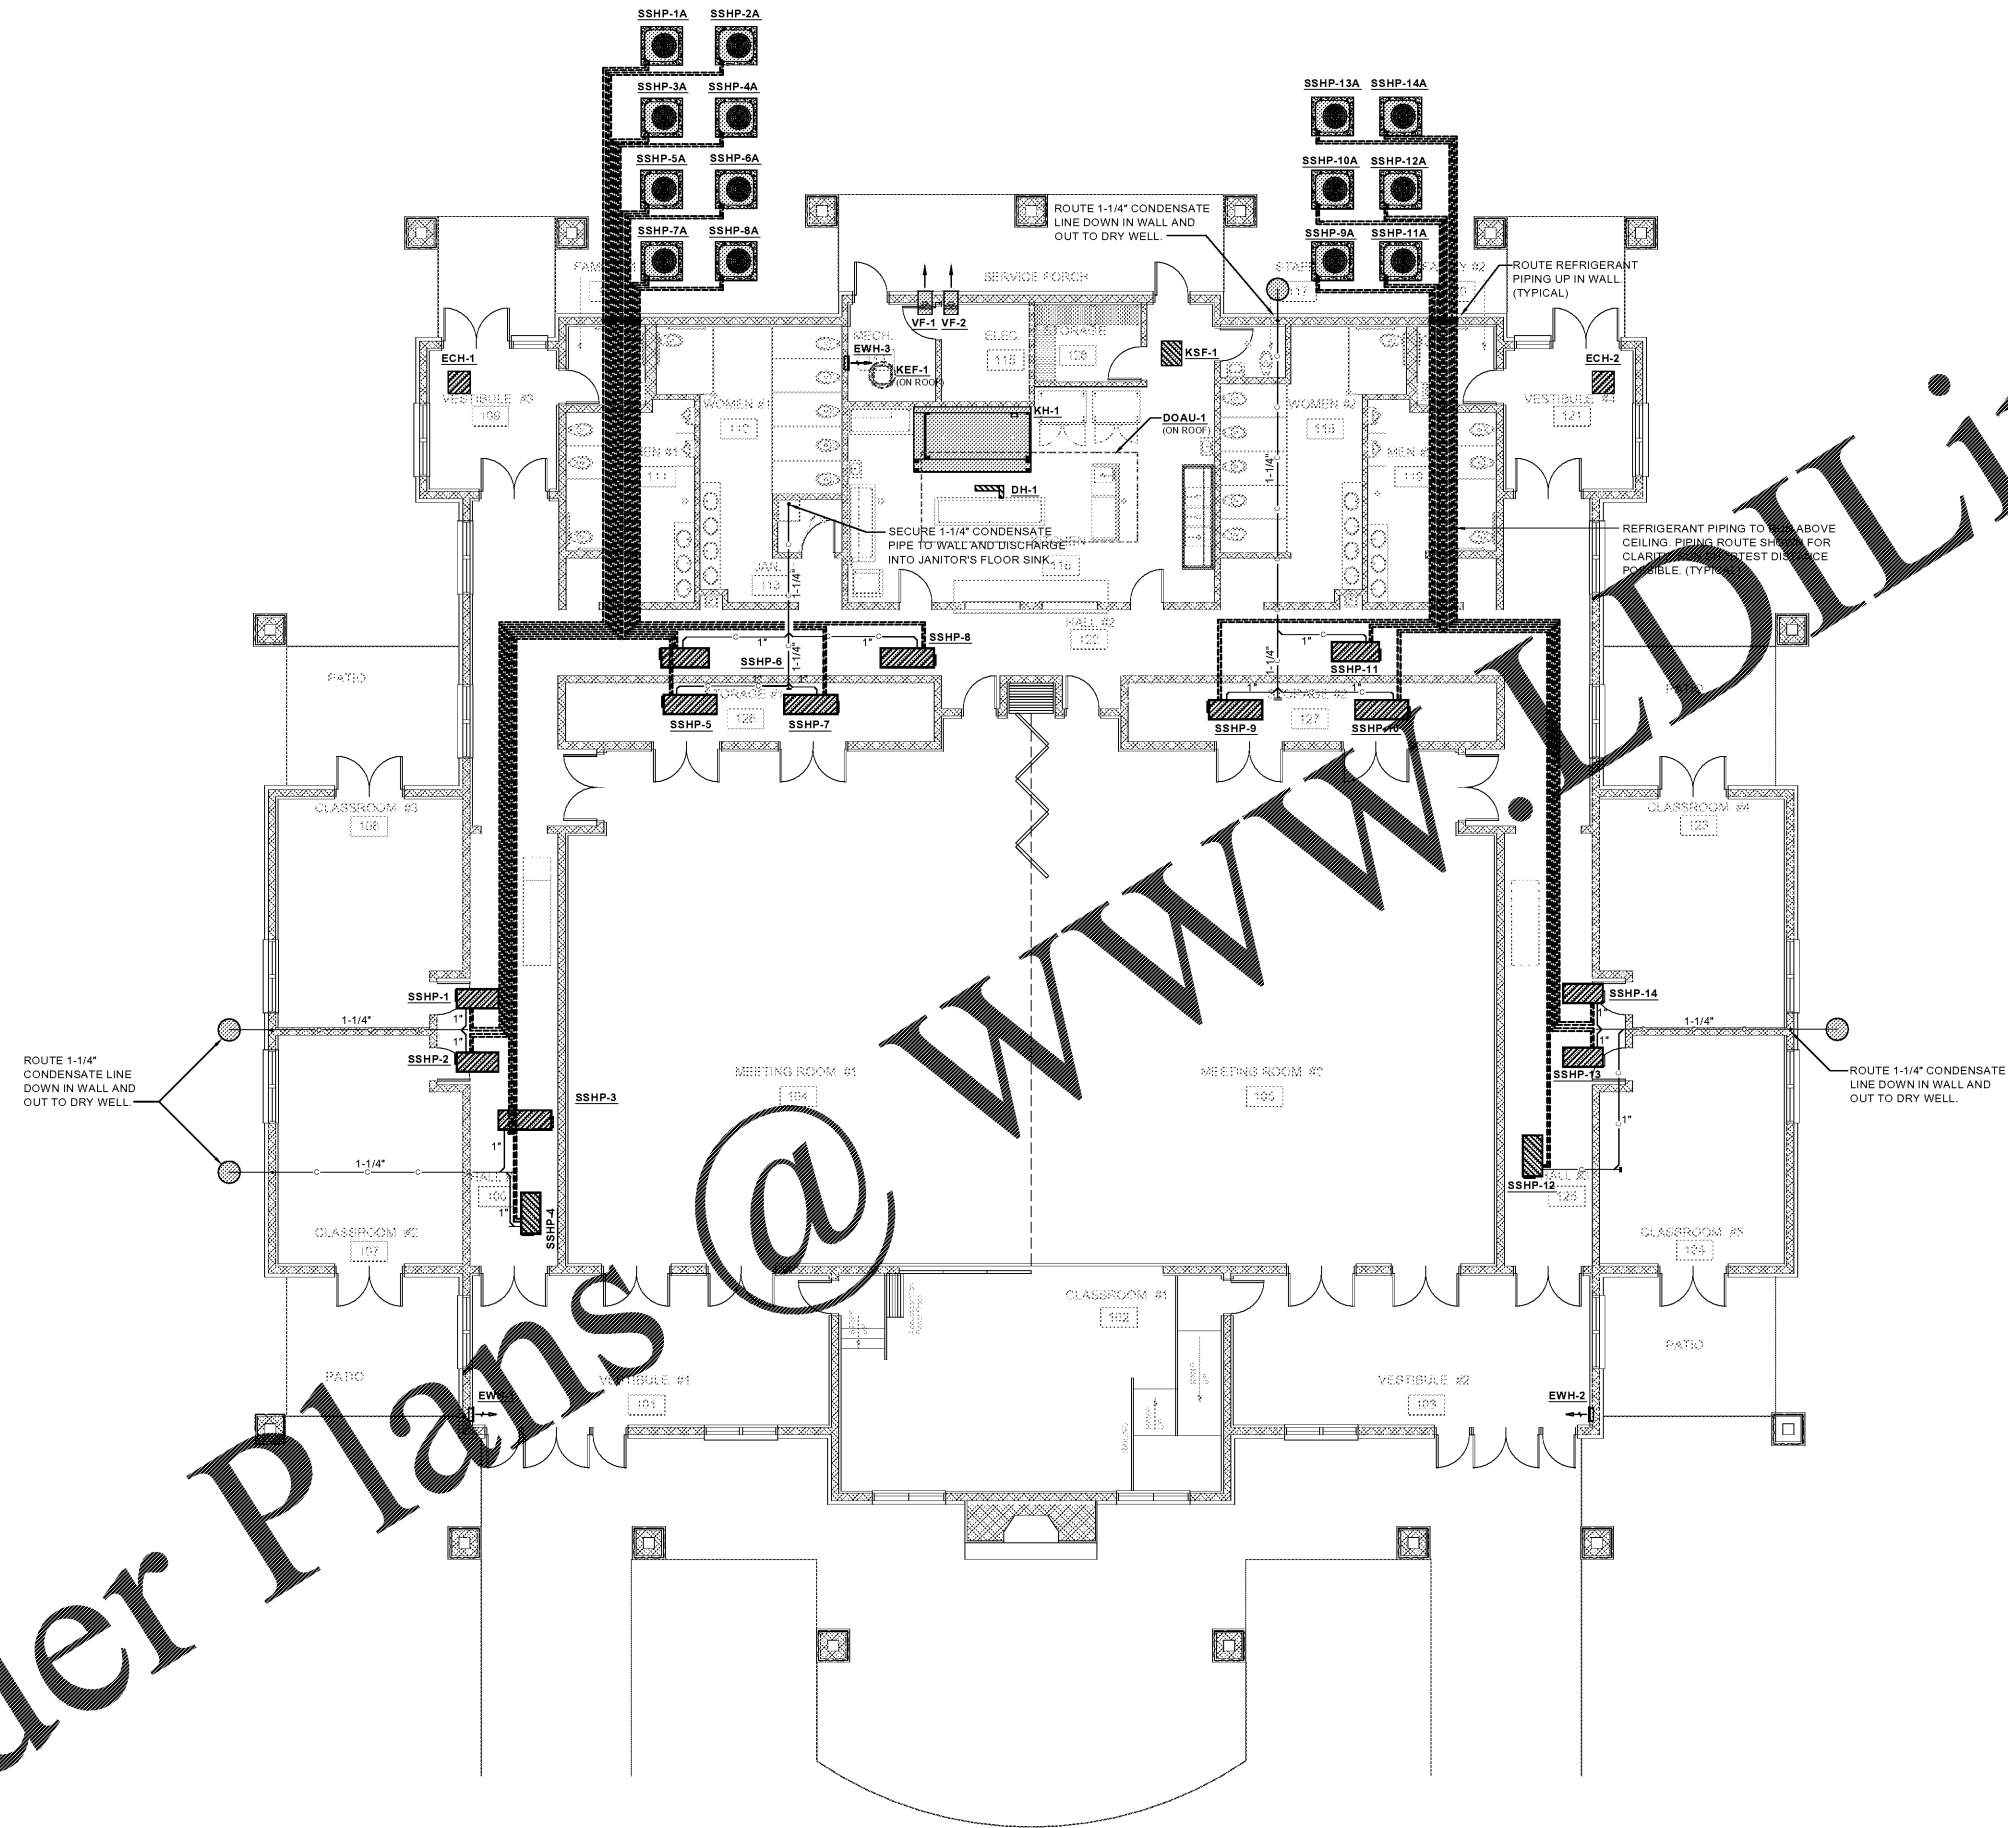

Order Plans @

WWW.LDILine.com

1 Overall Mechanical Piping Floor Plan
 m1.3 Scale: 1/8" = 1' - 0"

