




Columbia Office  
 P.O. Box 50644  
 Columbia, South Carolina  
 Phone: (803) 761-1111

Charleston Office  
 51-D Green Lane  
 Wando, South Carolina  
 Phone: (803) 761-1111

Jacksonville Office  
 175 Silver Street  
 Jacksonville, Florida 32206  
 Phone: (904) 494-6300

Designed: WMB  
 Approved: PPC  
 Job No.: 116226  
 Plot Date: 08/14/17

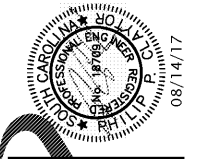


McCreech/Snow Architects, PA  
 Architects and Planners  
 2200 New 111<sup>th</sup> Street (29205)  
 Columbia, South Carolina 29211  
 csa@mcsmccreech.com

Overall Plumbing Floor Plan  
 Pinewood Community Bldg.  
 Richland County  
 Old Garners Ferry Road  
 Columbia, SC 29209

Drawn: -	Checked: -	Project No.: #####
Revised: -		
File: -		

**p1.1**  
 Sheet Number  
 February 6, 2017  
 Date

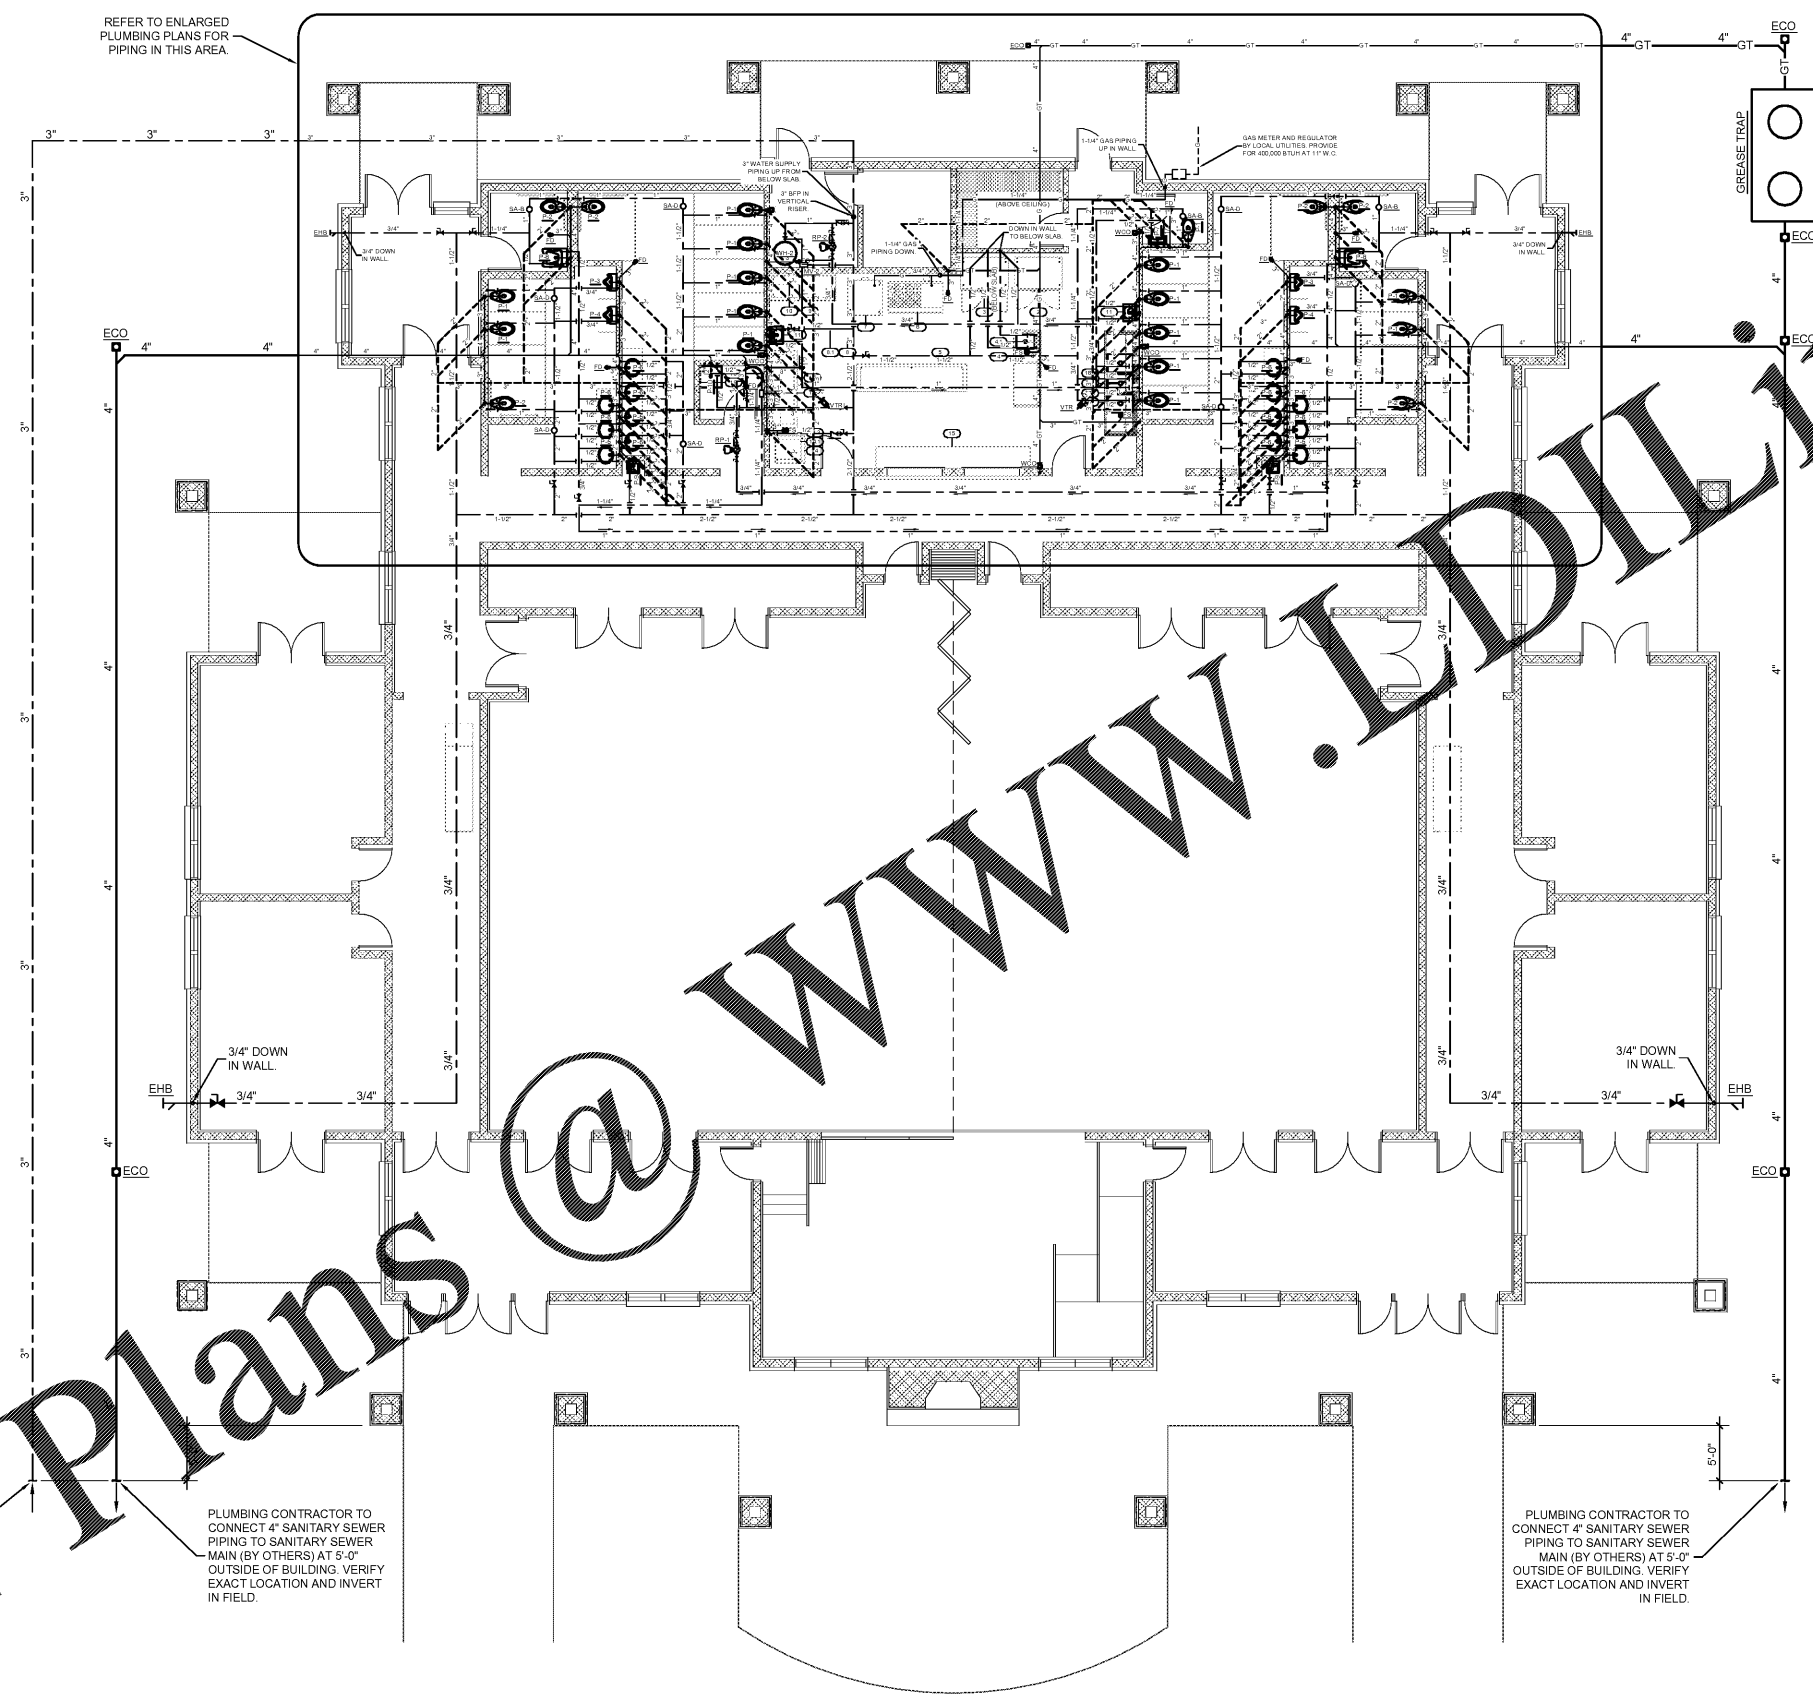


REFER TO ENLARGED PLUMBING PLANS FOR PIPING IN THIS AREA.

PLUMBING CONTRACTOR TO CONNECT 3\"/>

PLUMBING CONTRACTOR TO CONNECT 4\"/>

PLUMBING CONTRACTOR TO CONNECT 4\"/>

 **1 Overall Plumbing Floor Plan**  
 Scale: 1/8" = 1' - 0"



Construction Documents

Order Plans @ [www.ldline.com](http://www.ldline.com)

@

www.ldline.com

File date: 8/14/2017