


Order Plans @

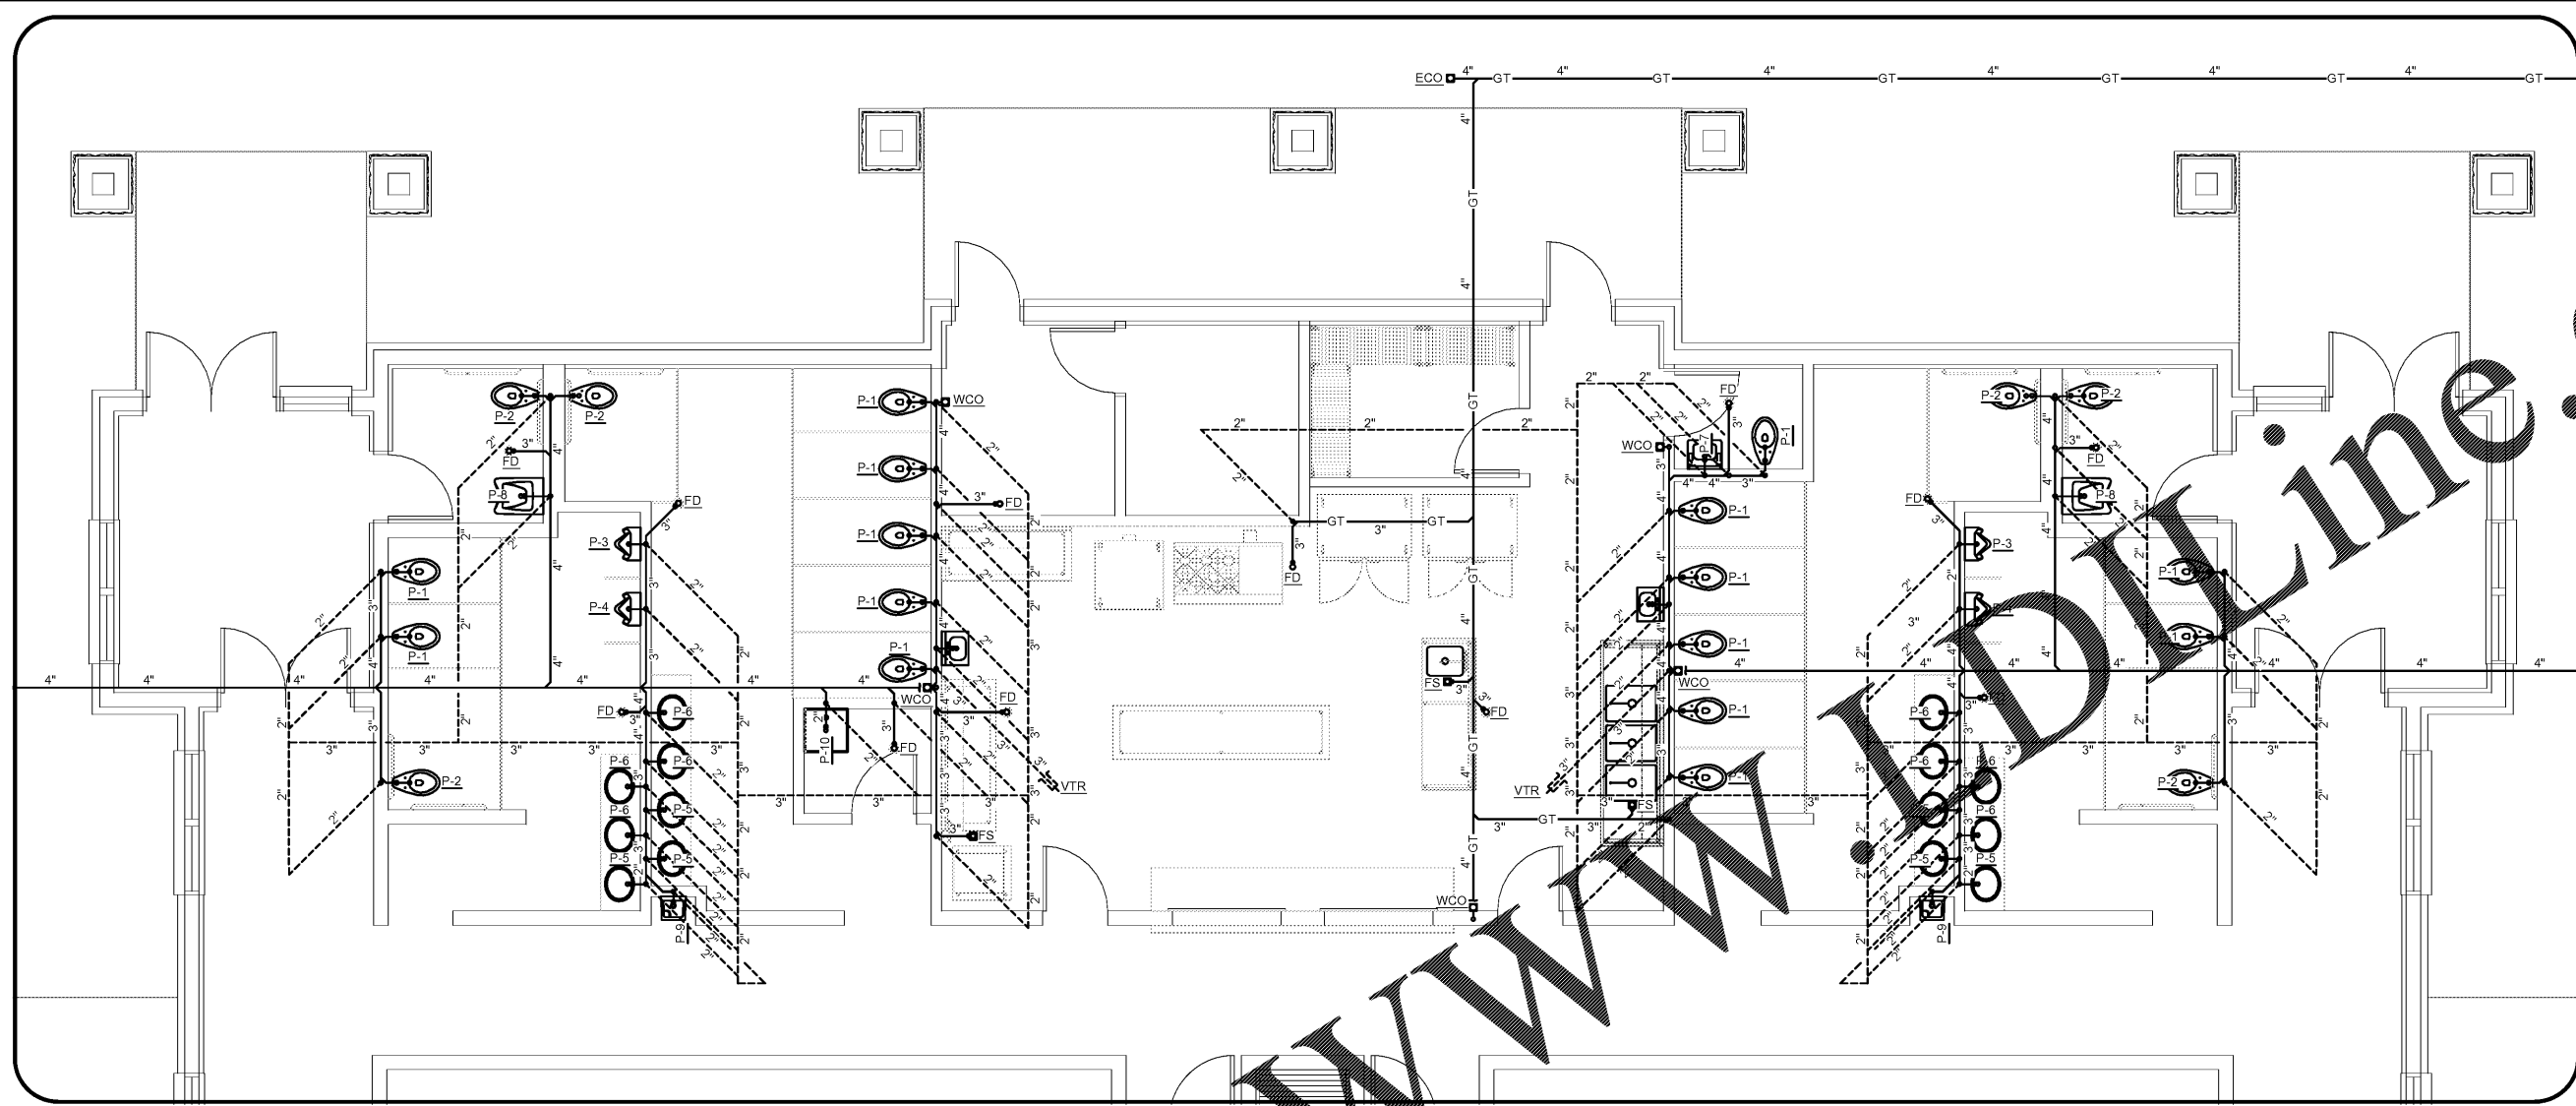

1
p2.1 Enlarged Plumbing Floor Plan - Waste And Vent
Scale: 1/4" = 1'-0"


MECA
Mechanical Engineering
Consulting Associates, Inc.

Columbia Office
P.O. Box 50644
Columbia, South Carolina
Phone: (803) 766-1111

Charleston Office
51-Durham Lane
Wando, South Carolina
Phone: (803) 766-1111

Jacksonville Office
175 Silver Street
Jacksonville, Florida 32206
Phone: (904) 494-6300

Designed: WMS
Approved: PPC
Job No.: 116226
Plot Date: 08/14/17

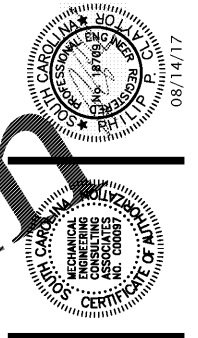


McCreary/Snow Architects, PA
Architects and Planners

200 New 111 St.
Columbia, South Carolina 29201
dmsnow@meccsa.com

Enlarged Plumbing Floor Plan
Pinewood Community Bldg.
Richland County
Old Garners Ferry Road
Columbia, SC 29209

File date: 8/14/2017

 Construction Documents



Drawn: -	Checked: -
Revised: -	
File: -	Project No.: #####

p2.1
Sheet Number
February 6, 2017
Date