


Order Plans @

 
WWW.LDLine.com

SPRINKLER CONTRACTOR TO BEGIN WORK AT APPROXIMATELY 1'-0" ABOVE FINISHED FLOOR AT THE APPROXIMATE LOCATION AS SHOWN ON THE PLANS. COORDINATE EXACT RUN-IN LOCATION AND PIPE SIZING WITH SITE UTILITY CONTRACTOR. THE FINAL PIPE SIZE FOR THE UNDERGROUND MAIN IS TO BE DETERMINED BY THE SPRINKLER CONTRACTOR BY HYDRAULIC CALCULATION AND THAT SIZING IS TO BE COORDINATED WITH THE GC AND SITE UTILITY CONTRACTOR PRIOR TO THE INSTALLATION OF THE UNDERGROUND FIRE MAIN.

FIRE PROTECTION CONTRACTOR TO CONNECT FIRE SPRINKLER RISER TO FIRE SPRINKLER MAIN (BY OTHERS) AT 12" ABOVE FINISHED FLOOR. VERIFY EXACT LOCATION IN FIELD.

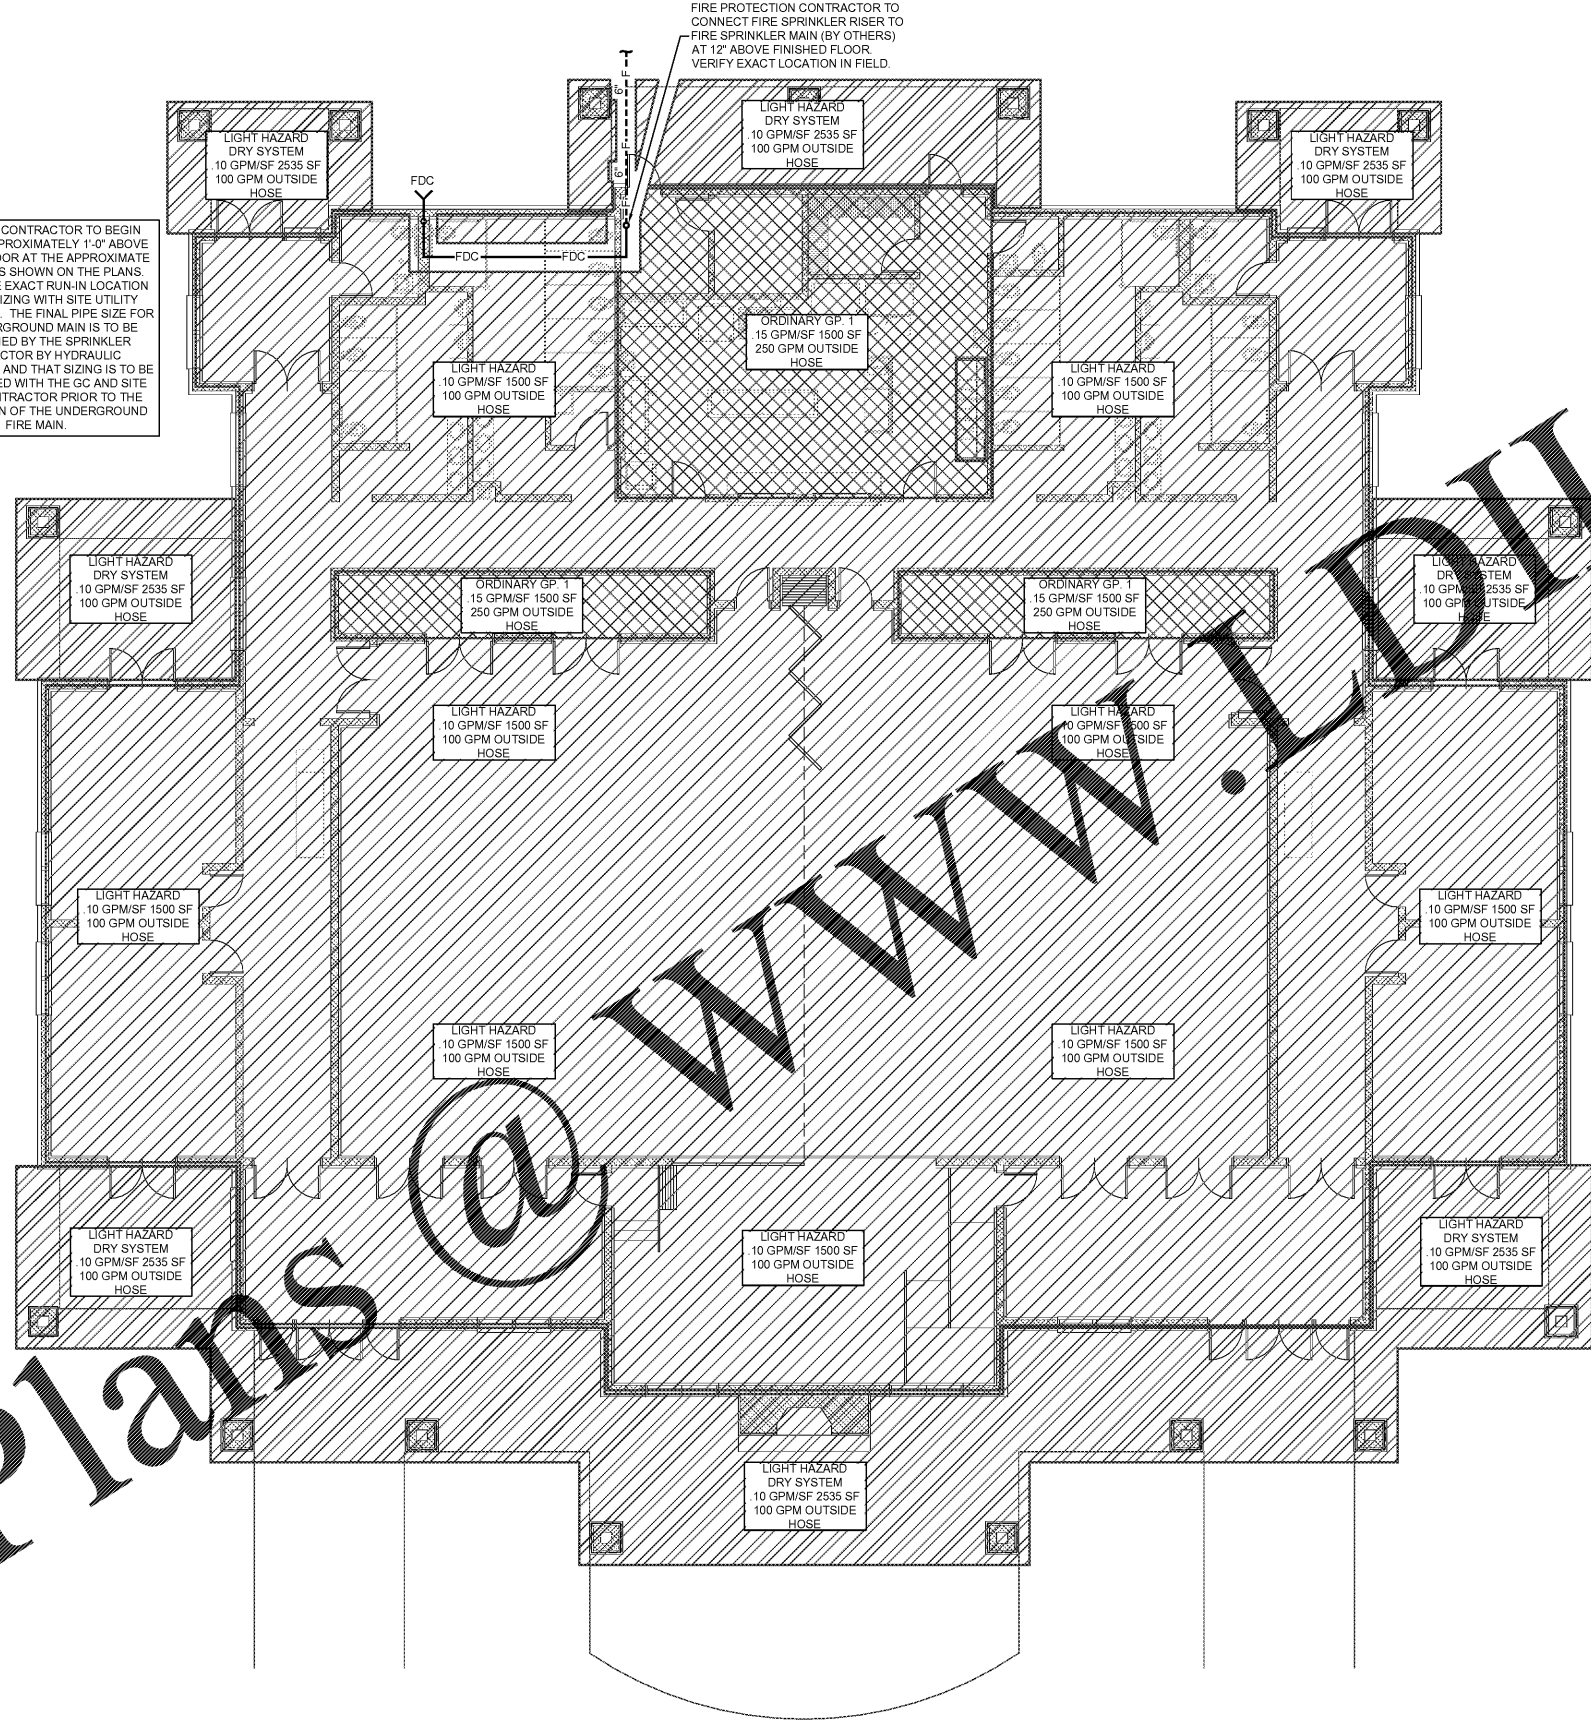

1 Overall Fire Protection Plan
p1.1 Scale: 1/8" = 1' - 0"




MECA
Mechanical Engineering
Consulting Associates, Inc.

Columbia Office
P.O. Box 50644
Columbia, SC 29205
Phone: (803) 762-1111

Charleston Office
51-D... Lane
Wando, SC 29486
Phone: (803) 762-1111

Jacksonville Office
175... Street
Jacksonville, Florida 32206
Phone: (904) 494-6300

Designed: WMS
Approved: PPC
Job No.: 116226
Plot Date: 08/14/17

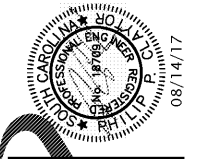

McCreary/Snow Architects, PA
Architects and Planners

250 New 111th St.
Columbia, South Carolina 29201
dsnow@mcarchi.com

File date: 8/14/2017

Construction Documents

Overall Fire Protection Plan
Pinewood Community Bldg.
Richland County
Old Garners Ferry Road
Columbia, SC 29209

Drawn: -	Checked: -
Revised: -	
File: -	Project No.: #####

fp1.1

Sheet Number
February 6, 2017
Date