
 


Order Plans

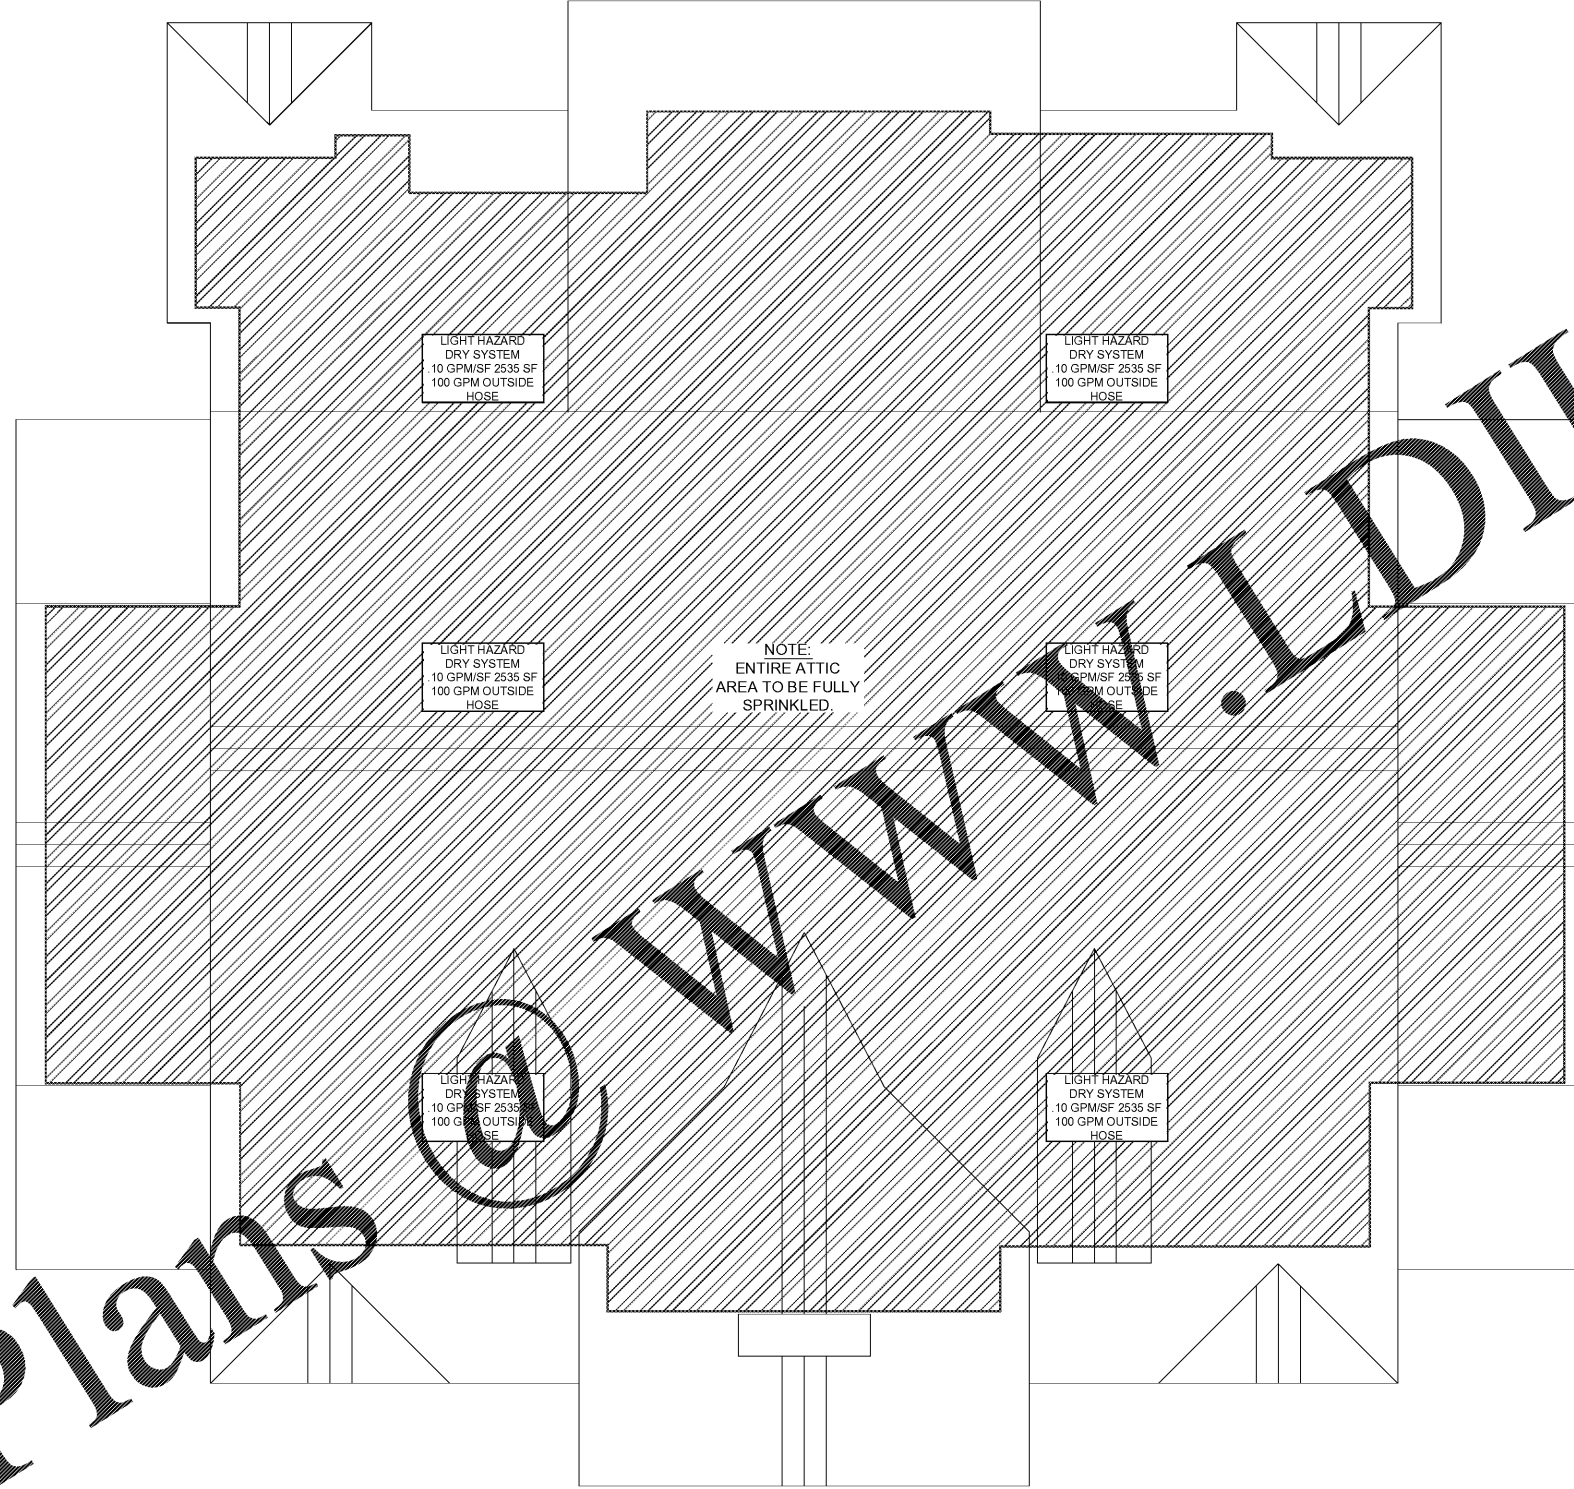

1 Attic Fire Protection Plan
 fp1.2 Scale: 1/8" = 1' - 0"



Construction Documents

File date: 8/14/2017

MECA
 Mechanical Engineering
 Consulting Associates, Inc.

Columbia Office
 P.O. Box 50644
 Columbia, South Carolina
 Phone: (803) 768-1011

Charleston Office
 51-D... Lane
 Charleston, South Carolina
 Phone: (803) 768-1011

Jacksonville Office
 175... Street
 Jacksonville, Florida 32206
 Phone: (904) 494-6300

Designed: WMS
 Approved: PPC
 Job No.: 116226
 Plot Date: 08/14/17

Attic Fire Protection Plan
 Pinewood Community Bldg.
 Richland County
 Old Garners Ferry Road
 Columbia, SC 29209

McCreary/Snow Architects, PA
 Architects and Planners

200 Low... Street (29205)
 Columbia, South Carolina 29211
 mc@msa.com

Professional Engineer Seal
 State of South Carolina
 License No. 10009
 Date: 08/14/17

Drawn: -	Checked: -
Revised: -	
File: -	Project No.: #####