


Electrical Plan
 Pinewood Community Bldg.
 Richland County
 Old Garners Ferry Road
 Columbia, SC 29209


Drawn: - MRD/CJA Checked: - SDO
 Revised: -
 Project No.: #####
 File: -

E100
 Sheet Number
 August 22, 2017
 Date

Pricing set only - NOT FOR CONSTRUCTION

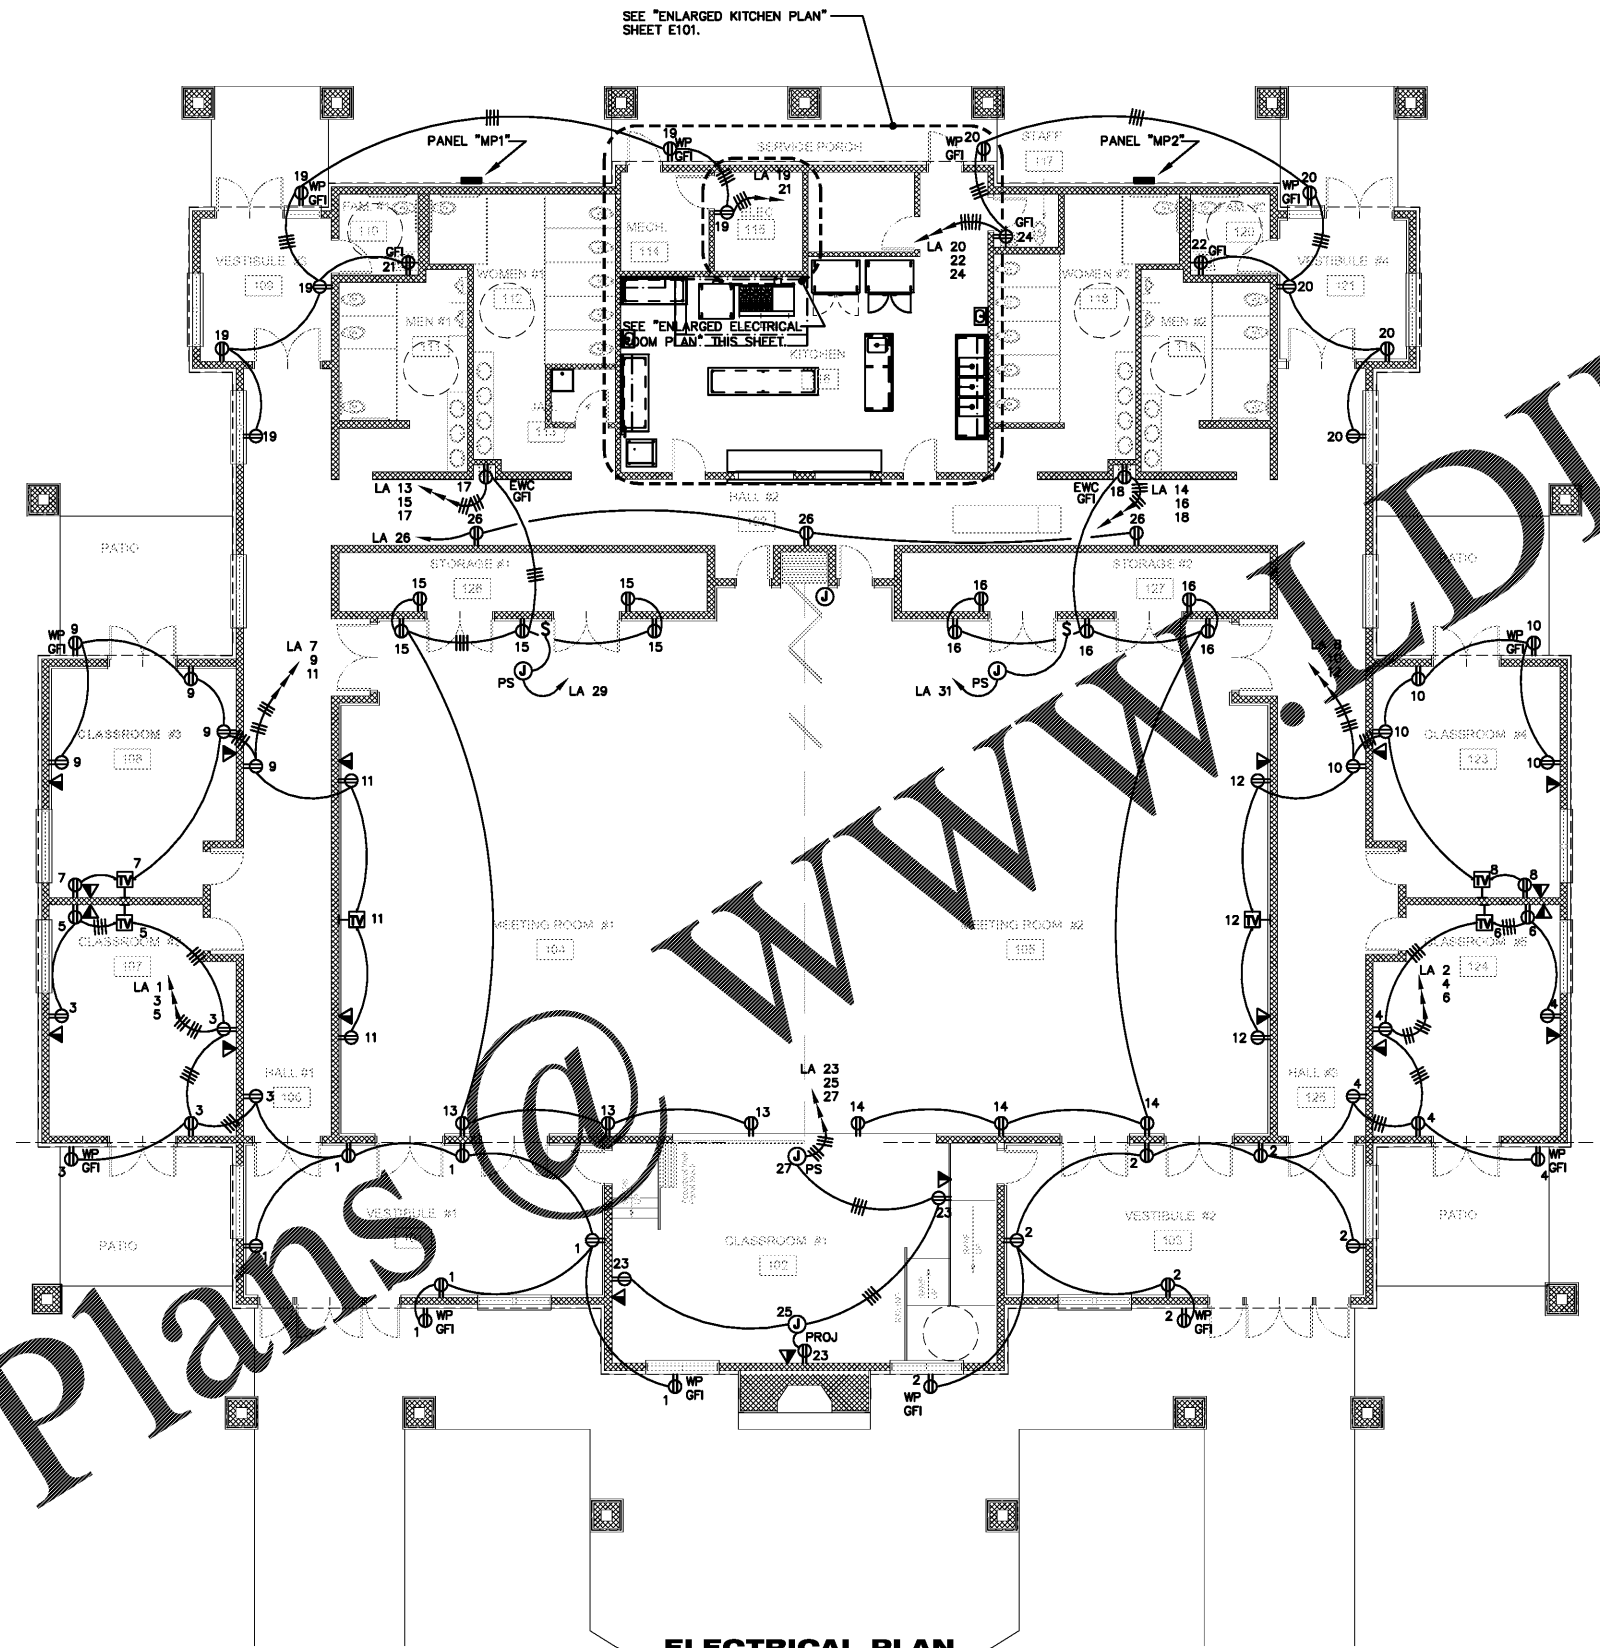

ELECTRICAL PLAN
 SCALE: 1/8" = 1'-0"

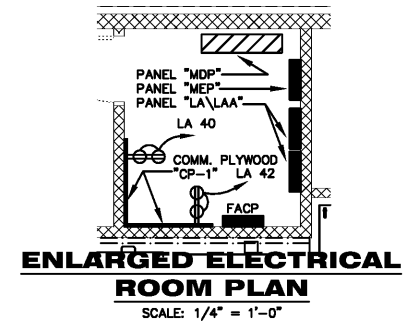

ENLARGED ELECTRICAL ROOM PLAN
 SCALE: 1/4" = 1'-0"

Order Plans @ www.DLine.com

GWA inc. Electrical Engineers
 Midlands Office - Main
 168 Laurelhurst Avenue
 Columbia, SC 29210
 (803)252-6919
 Fax (803)799-5494
 gwa@gwainc.net
 http://www.gwainc.net

ALL RIGHTS RESERVED. THE DRAWING AND ALL OTHER CONTENT IS CONSIDERED TO BE PROPRIETARY TO THE FIRM OF GWA INC. ANY REPRODUCTION OR DISTRIBUTION OF THIS DRAWING OR ANY PART OF THE DRAWING WITHOUT THE WRITTEN PERMISSION OF GWA INC. IS STRICTLY PROHIBITED.