


Order Plans

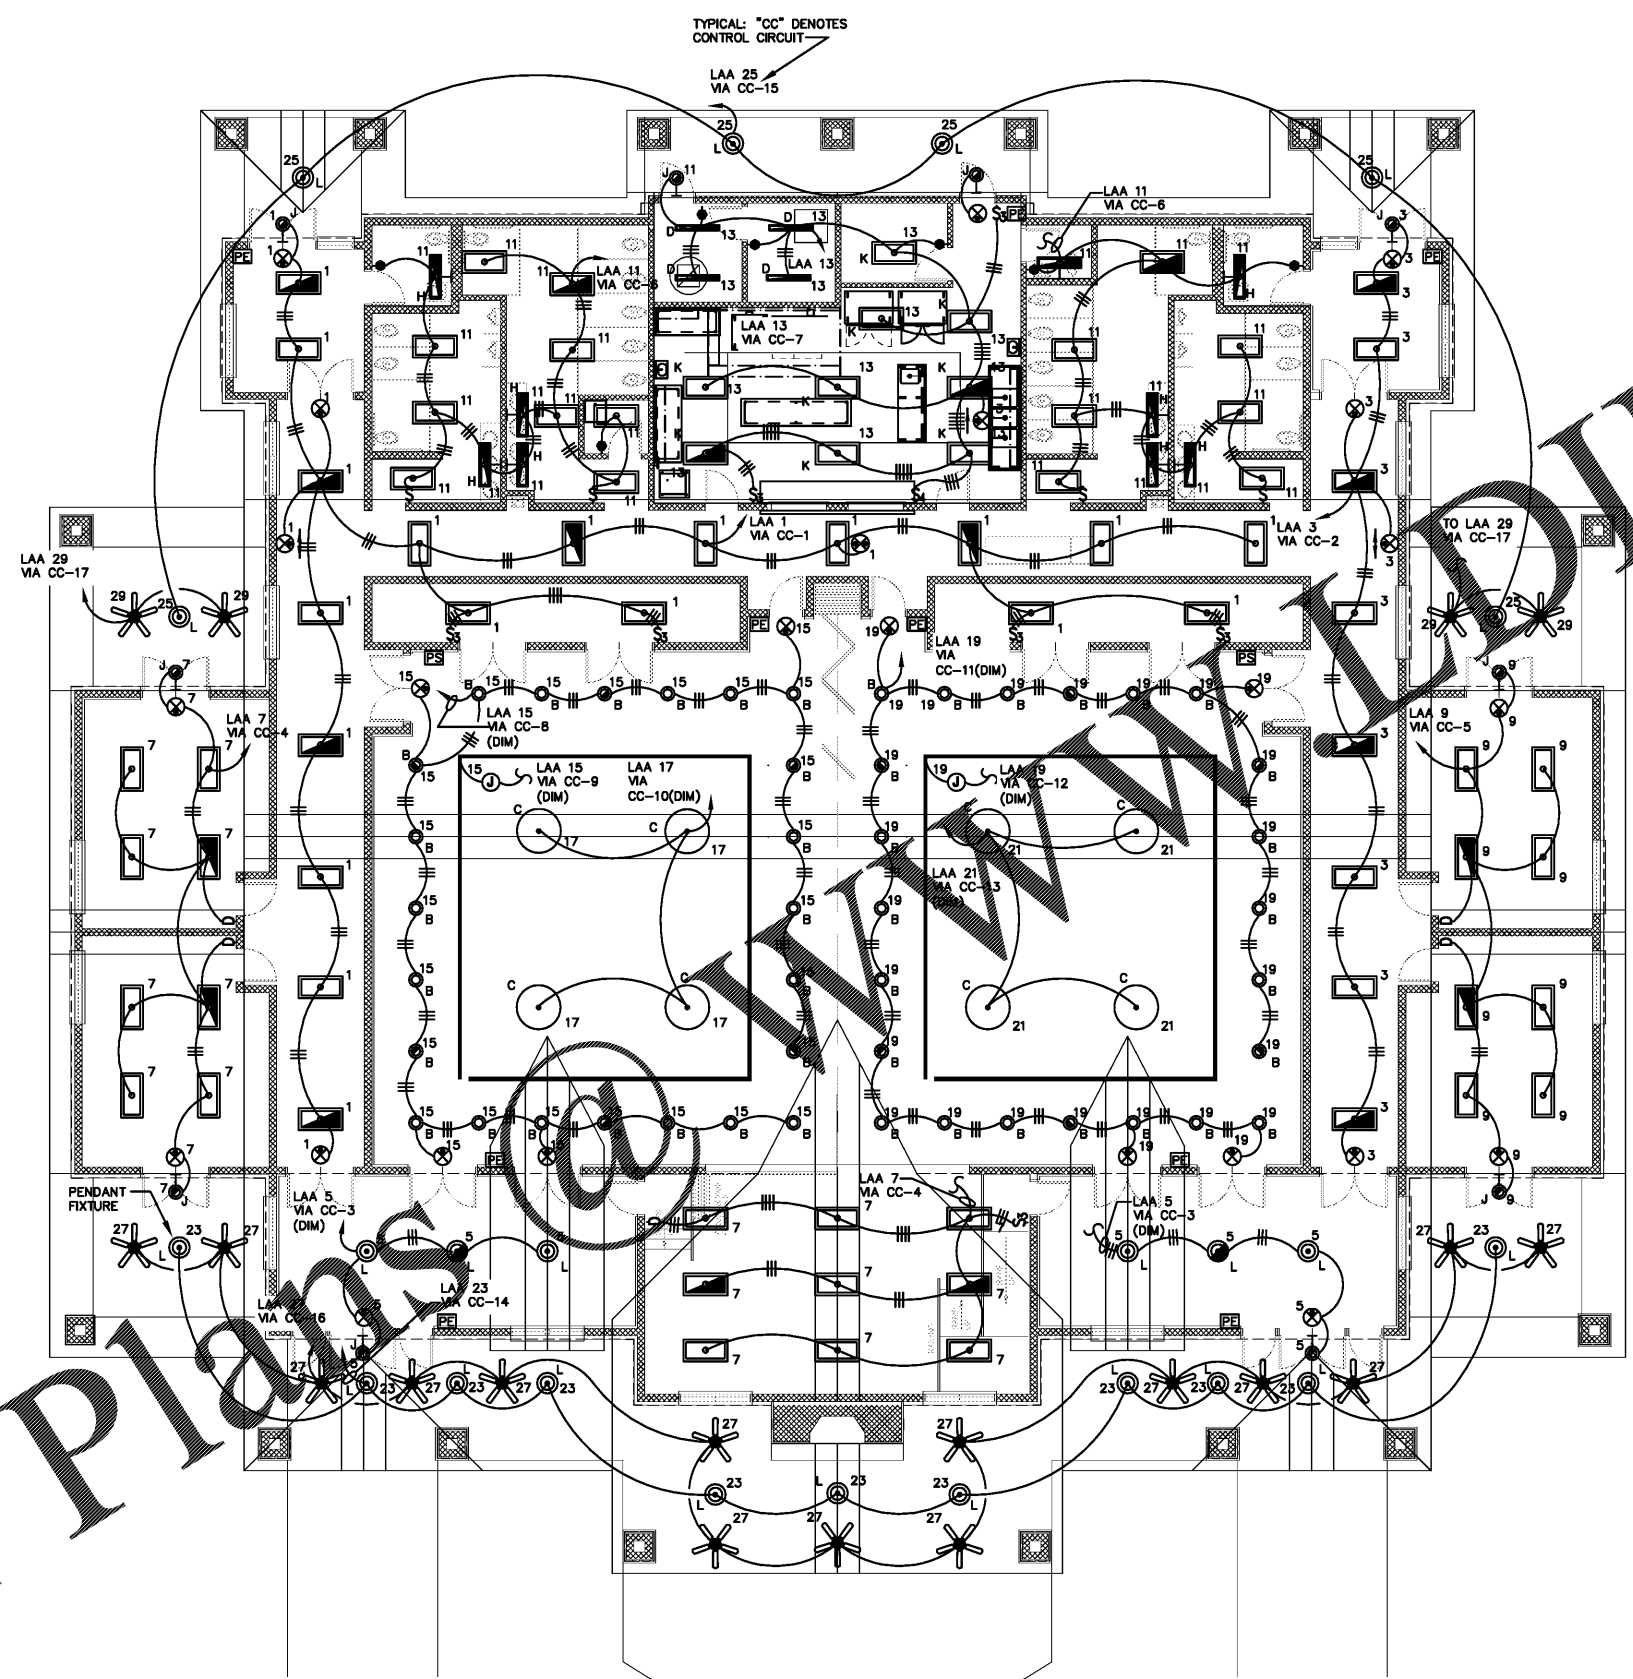


NOTE: PROVIDE UNSWITCHED (RELAY BYPASS) CONDUCTOR IN HOMERUNS AND CIRCUITS SERVING EMERGENCY FIXTURES TO ALLOW FOR PROPER BATTERY OPERATION.

ALL FIXTURES SHALL BE TYPE "A" UNLESS NOTED OTHERWISE

LIGHTING PLAN
SCALE: 1/8" = 1'-0"

Order Plans

Online.com

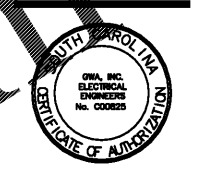

Lighting Plan
Pinewood Community Bldg.
Richland County
Old Garners Ferry Road
Columbia, SC 29209

Pricing set only - NOT FOR CONSTRUCTION

Drawn: - MIRD/CJA Checked: - SDO
Revised: -
Project No. : #####
File: -

GWA inc. Electrical Engineers
Midlands Office - Main
168 Laurelhurst Avenue
Columbia, SC 29210
(803)252-6919
Fax (803)799-5494
gwa@gwainc.net
http://www.gwainc.net

E200
Sheet Number
August 22, 2017
Date