


Order Plans @

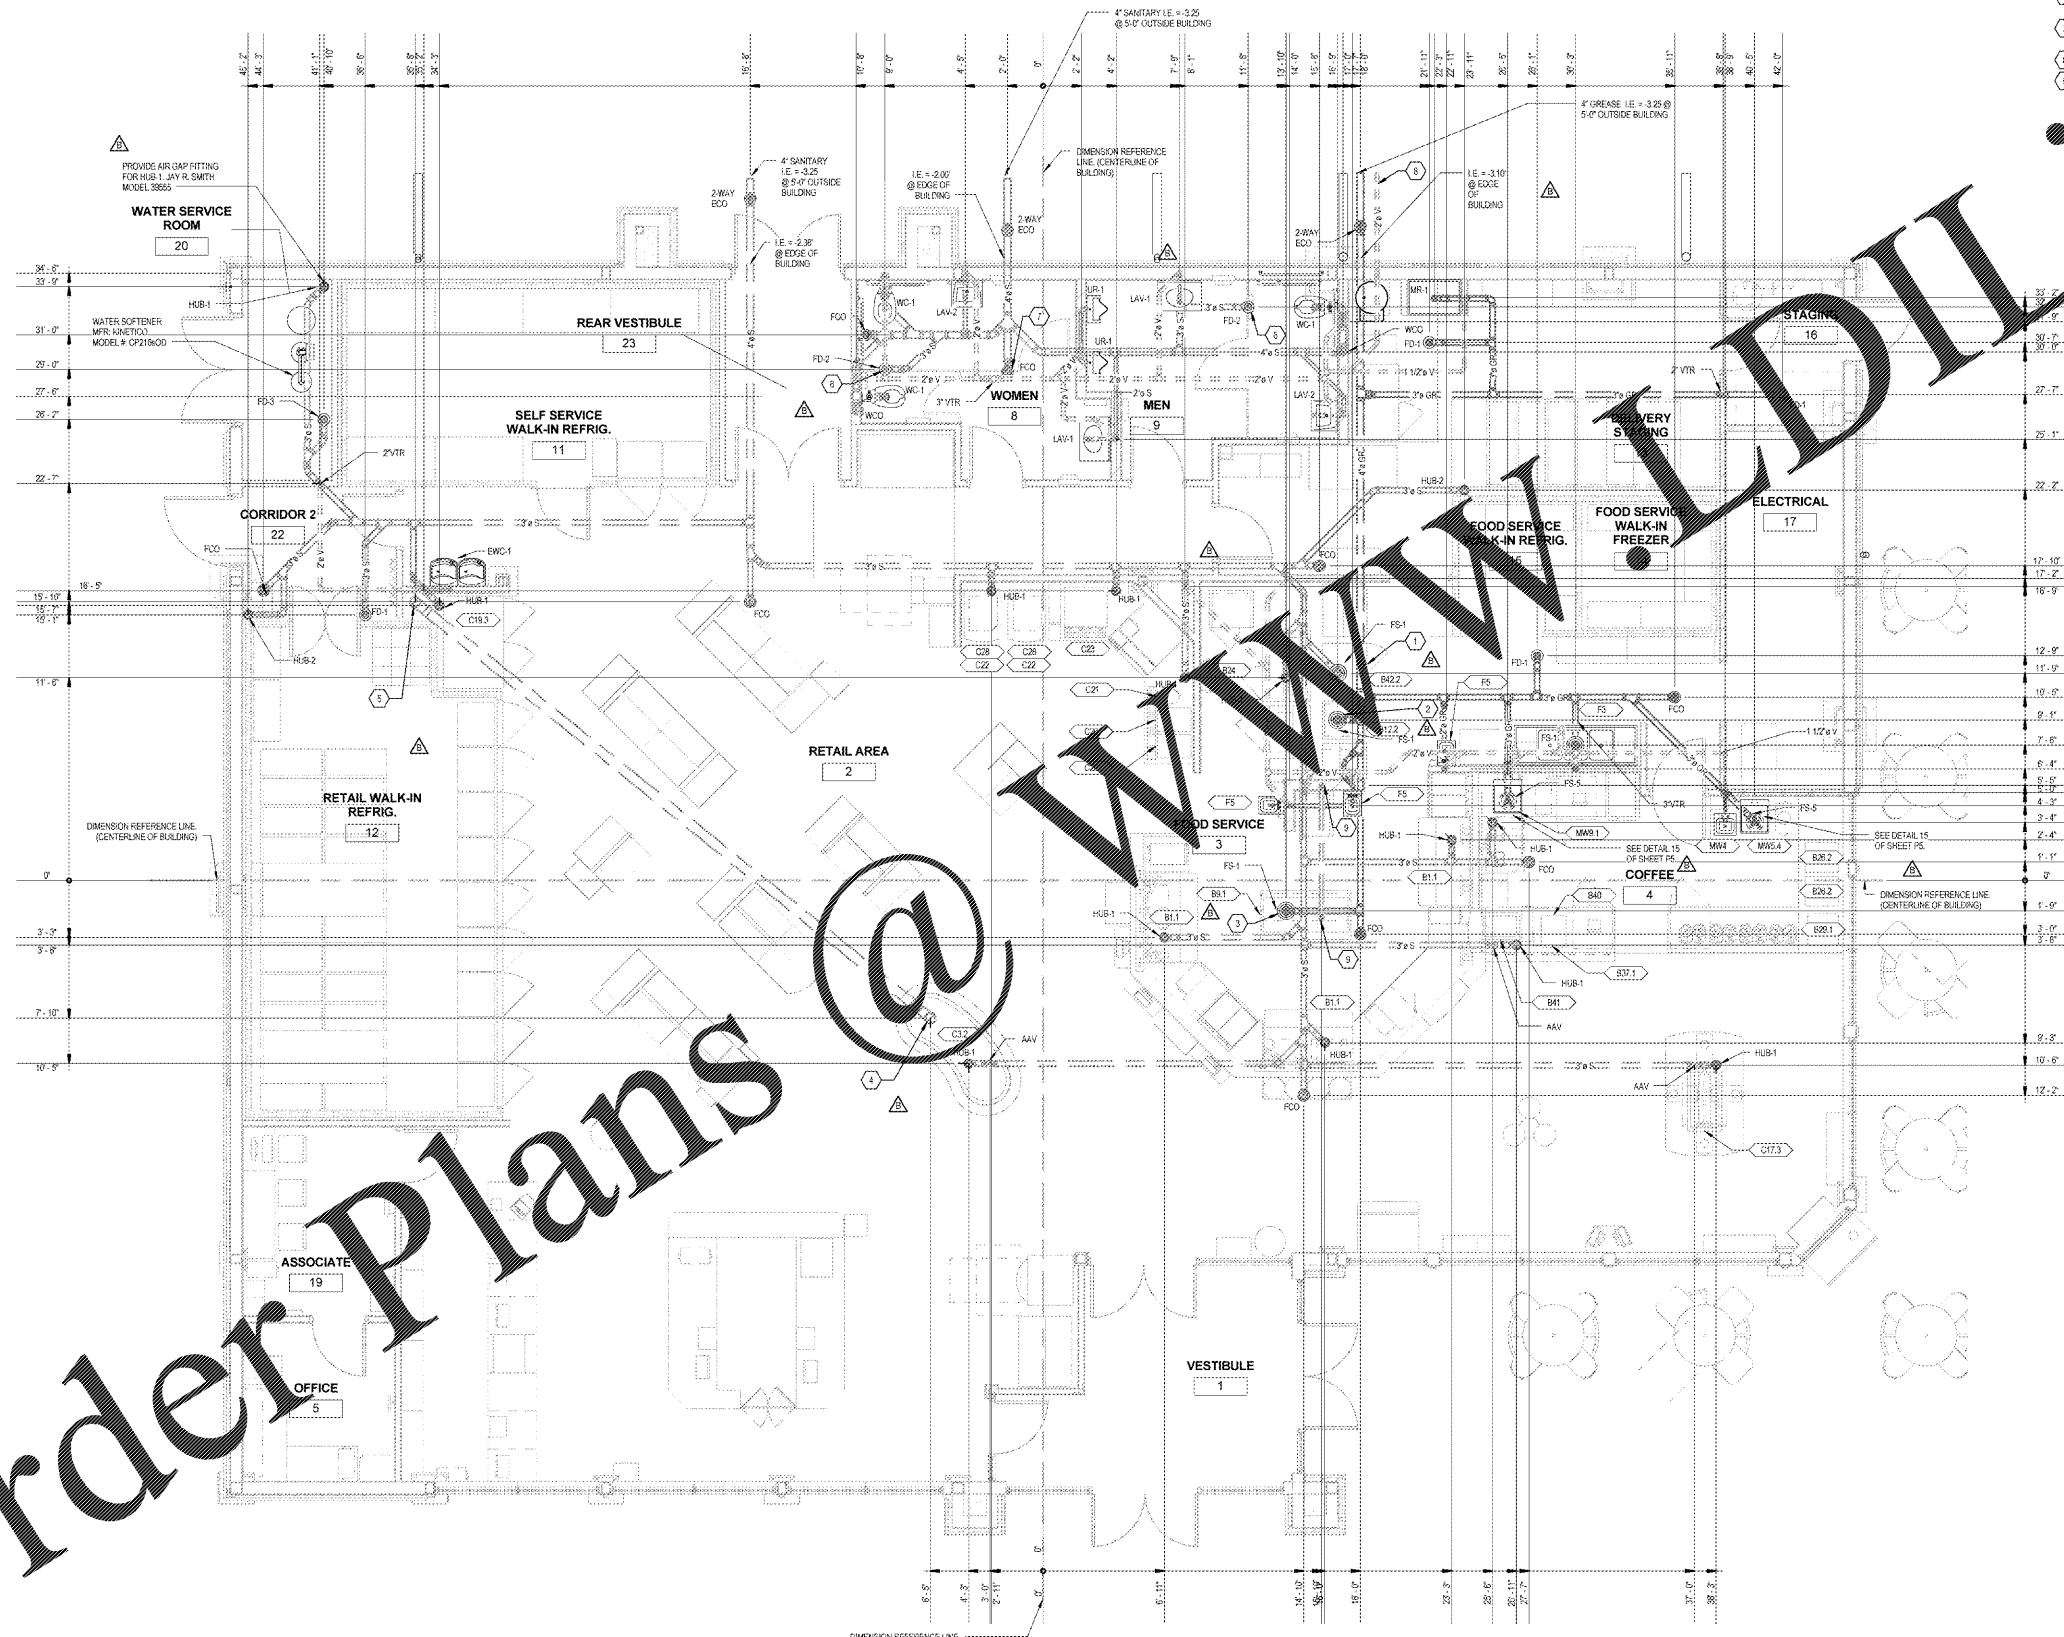

SANITARY INVERT NOTE
 3.25' I.E. AT 5'-0" OUTSIDE BUILDING IS A COMMON ELEVATION FOR REFERENCE. COORDINATE ACTUAL ELEVATIONS WITH SITE CONTRACTOR WITH REGARDS TO SITE SANITARY MAIN INVERT.

- PLUMBING KEYNOTES**
- 2" COPPER PIPING FITTINGS TO ADAPT TO UNIT AND EXTEND TO THE FLOOR DRAIN.
 - MAKE THE FIRST 12" OF GREASE PIPING FROM FLOOR SINK AT THE B102 REHEAT/SEALER CAST IRON INSTEAD OF PVC.
 - MAKE THE FIRST 12" OF GREASE PIPING FROM FLOOR SINK AT THE B01 HOT FOOD TABLE CAST IRON INSTEAD OF PVC.
 - 6" SCHEDULE 40 ELECTRICAL PVC W/ LONG SWEEP ELBOWS SHALL BE USED FOR REFRIGERANT LINE CHASE. STUB UP 2" A.F.F. BY PLUMBING CONTRACTOR.
 - RUN REFRIGERATION PIPE DOWN IN WALL THRU 6" SCHEDULE 40 ELECTRICAL PVC PIPE W/ LONG SWEEP ELBOWS (STUB UP).
 - FLOOR DRAIN GRATE TO BE SET FLUSH WITH TOP OF CONCRETE AND CENTERED UNDER PARTITIONS.
 - FLOOR CLEANOUT TOP TO BE SET FLUSH WITH TOP OF CONCRETE AND CENTERED UNDER PARTITIONS.
 - 2" VENT TO BE CONNECTED WITH 1/2" GREASE INTERCEPTOR AT THE INLET AND 1/2" 1-1/2" PVC BELOW FLOOR FOR 1/2" HW LINE TO B01.

ROOF DRAIN LINE PROVIDE 1/2" DIA. 1/2" PVC AND 1/2" DIA. OUTLET PIPE ROUTE TO DOWNSPOUT AND INTO CLEANOUT. SEE SHEET P3 FOR ROOF PLAN AND DETAIL. SEE SHEET ALL FOR DRAIN AND PIPING INSTALLATION.

Wawa & Peterson
 Architects
 Planners
 Engineers
 10000 W. 11th Ave.
 Suite 100
 Overland Park, KS 66211
 Phone: (913) 241-1100
 Fax: (913) 241-1101
 www.wawapeterson.com

CLIENT NAME
WAWA
 260 WEST BALTIMORE PIKE
 WAWA, PENNSYLVANIA 19063

PROJECT NAME
WAWA F85FB 2017.01 STORE #5254-OKE
 OKEECHOBEE RD & JENKINS RD.
 FT. PIERCE, FLORIDA

SHEET TITLE
WASTE PIPING PLAN

No.	Description	Date
1	PRELIMINARY	04/24/2017
2	REVISED	07/26/2017
3	PRE-BID REVIEW SET	07/26/2017
4	BID SET	08/30/2017

PROJECT NO.
210503

DATE
08/30/2017

DESIGNER
BRIAN WILSON

CHECKED
[Signature]

P1