


Order Plans @

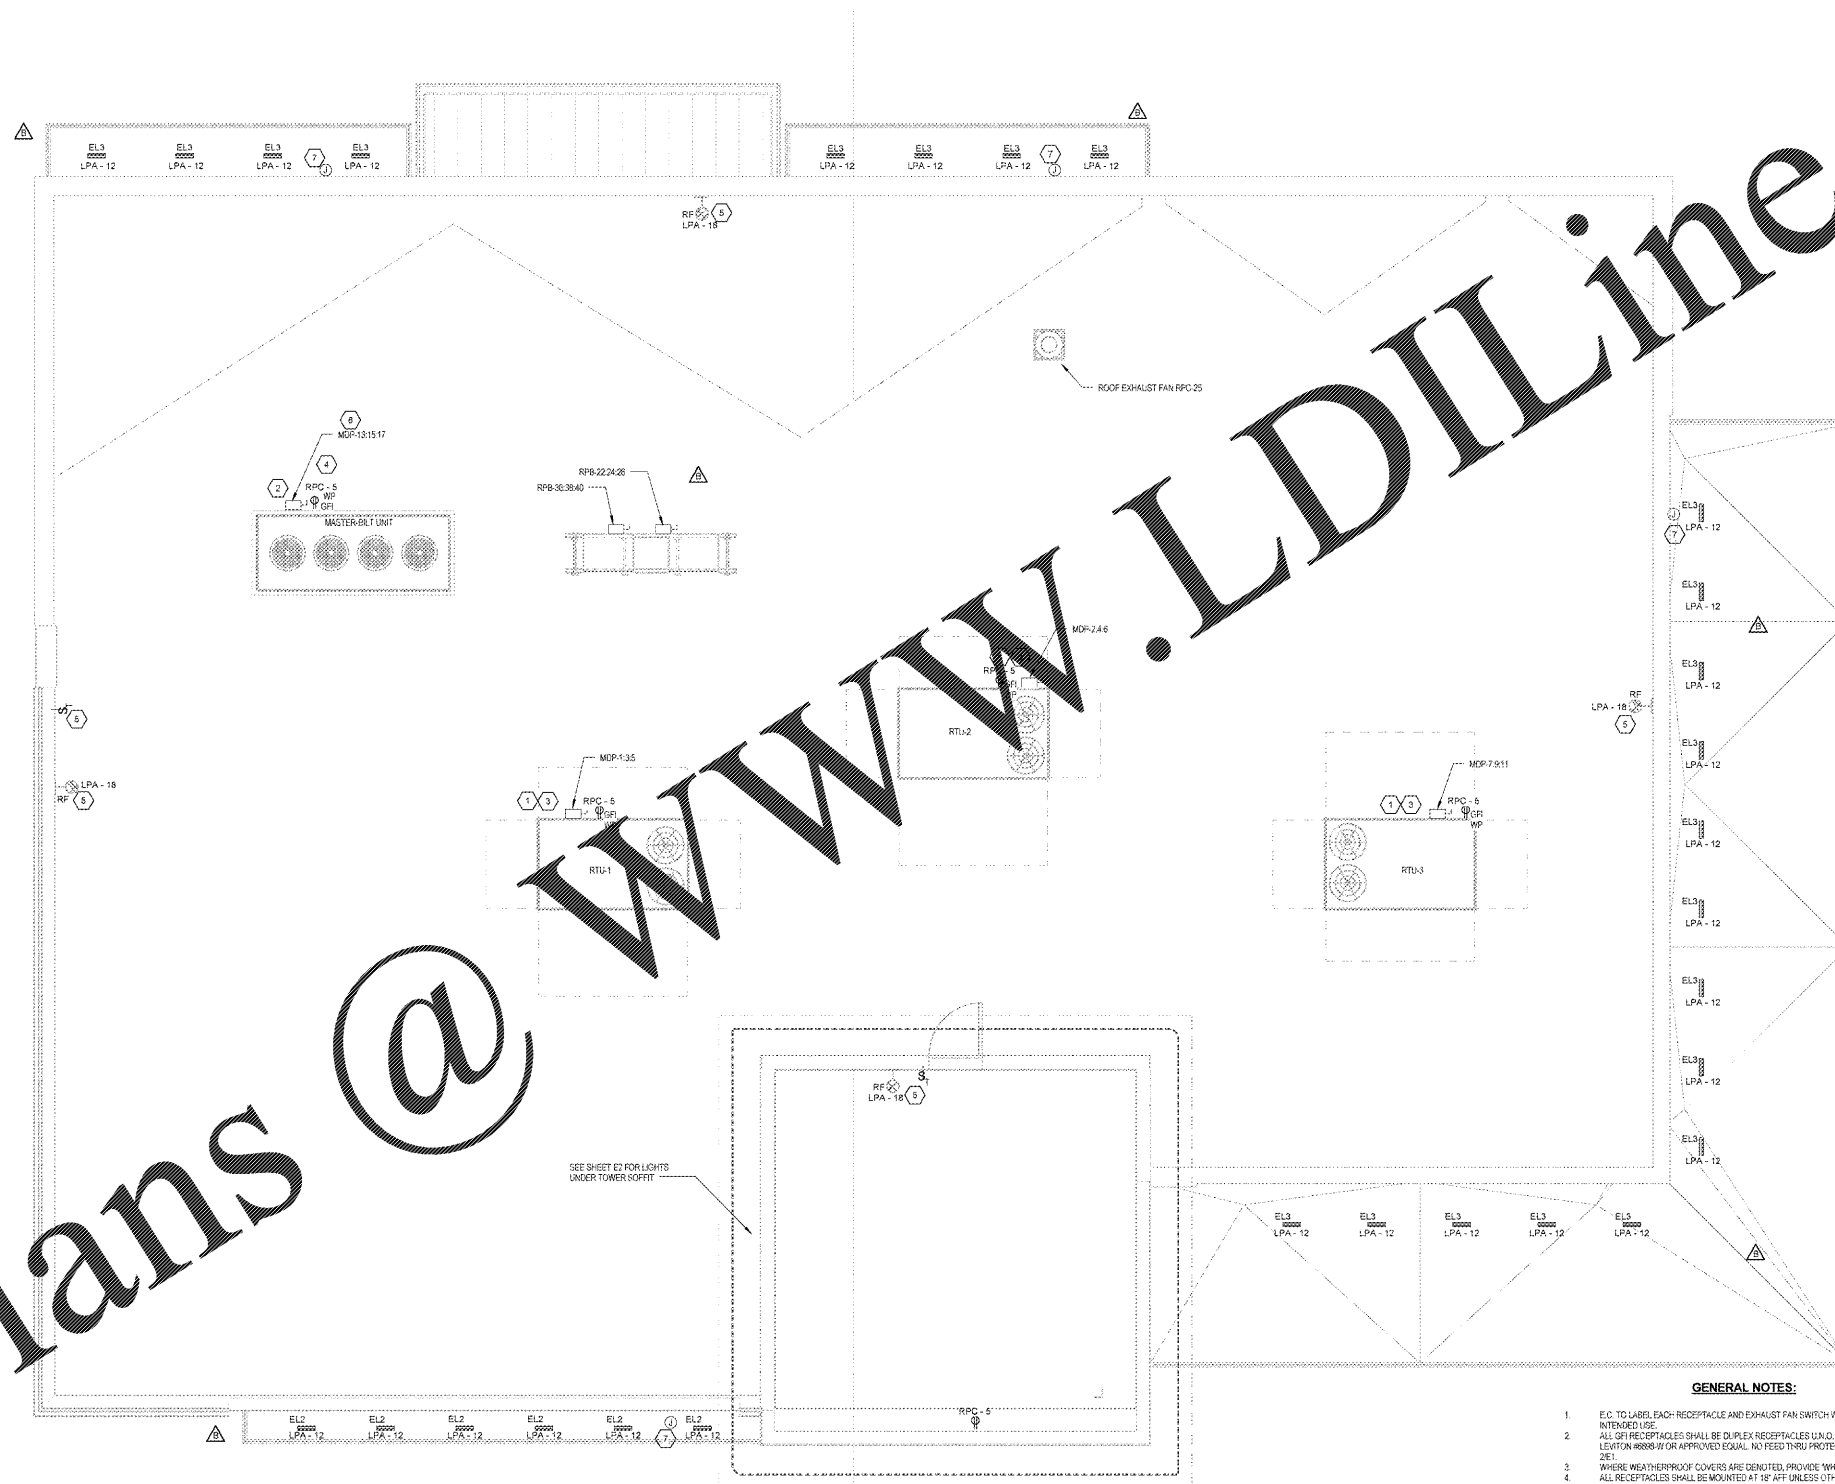

1 ELECTRICAL ROOF PLAN  
1/4" = 1'-0"

GENERAL NOTES:

1. E.C. TO LABEL EACH RECEPTACLE AND EXHAUST FAN SWITCH WITH CIRCUIT NUMBER AND INTENDED USE.
2. ALL 120V RECEPTACLES SHALL BE DUPLEX RECEPTACLES (U.I.D. WITH LED INDICATOR LIGHT, LEVITON 88888) OR APPROVED EQUAL. NO FEED THRU PROTECTION PERMITTED. SEE DETAIL 2E1.
3. WHERE WEATHERPROOF COVERS ARE DENOTED, PROVIDE "WIRE-IN-USE" COVERS.
4. ALL RECEPTACLES SHALL BE MOUNTED AT 18" AFF UNLESS OTHERWISE NOTED.
5. E.C. TO COORDINATE INSTALLATION OF ALL ROOF LIGHTING FIXTURES WITH ROOFING CONTRACTOR TO PROVIDE A STRUCTURALLY SOUND AND WEATHERPROOF "LEAK FREE" INSTALLATION. RUN CONDUITS IN PARAPET WALL, NO EXPOSED CONDUITS OR EXTRA ROOF PENETRATIONS.

KEYNOTES:

1. MAIN DISCONNECT PROVIDED WITH UNIT. POWERED CONVENIENCE OUTLET PROVIDED WITH UNIT.
2. E.C. SHALL PROVIDE COMPLETE CONDUIT/CONDUCTOR SYSTEM FROM MDP TO UNIT VIA DISCONNECT.
3. E.C. SHALL PROVIDE COMPLETE CONDUIT/CONDUCTOR SYSTEM FROM MDP TO SINGLE POINT CONNECTION AT UNIT.
4. PROVIDE SUPPORT HOOK ATTACHED TO UNIT AS REQUIRED TO MOUNT ELECTRICAL EQUIPMENT.
5. E.C. SHALL PROVIDE IN LIGHTING FIXTURE (BASES OF FIXTURES - WHOLEY PRINCIPAL) PROVIDE WEATHERPROOF SWITCH WITH TIMER NEAR ACCESS LADDER AND DOOR. EXHAUSTERS AND SWITCHES TO BE SURFACE MOUNTED 8" BELOW TOP OF WALL OR 48" ABOVE FLOOR IN TOWER. PROVIDE COMPLETE CONDUIT/CONDUCTOR SYSTEM FOR FIXTURES AND SWITCHES BACK TO POWER PANEL IN ELECTRICAL ROOM.
6. NOT USED.
7. WALL MOUNTED WEATHERPROOF J-BOX TO SERVE 'EL2' AND 'EL3' LIGHTS ON TOP OF CANOPY ELECTRICAL POWER TO MASTER BELT UNIT TO RUN THROUGH PROVIDED GOOSENECK NEXT TO UNIT. DO NOT CREATE SEPARATE ROOF PENETRATIONS.

**www.LDILine.com**  
**44**

**Curry & Peterson**  
 Engineers Planners  
 Architects  
 10000 Westchase Blvd, Suite 1000  
 Houston, TX 77036  
 Phone: 281.416.1100  
 Fax: 281.416.1101  
 Email: info@curryandpeterson.com

CLIENT NAME: **WAWA**  
 PROJECT NAME: **WAWA F85FB 2017.01 STORE #5254-OKE**  
 PROJECT ADDRESS: **260 WEST BALTIMORE PIKE, WAWA, PENNSYLVANIA 19063**  
 PROJECT ADDRESS: **OREECHOBEE RD & JENKINS RD, FT. PIERCE, FLORIDA**

SHEET TITLE: **ROOF LIGHTING AND POWER PLAN**

Revision	Description	Date
1	ISSUED FOR PERMIT	08/30/2017
2	REVISED	07/28/2017
3	IFPE-BID REVIEW SET	07/26/2017
4	BID SET	08/30/2017

PROJECT NO.: 210503  
 DATE: 08/30/2017  
 DRAWN: JPM  
 CHECKED: JPM

**E3**