

SYMBOL INFORMATION

3 DETAIL
SCALE: 1/4" = 1'-0"
DRAWING NUMBER
DRAWING SUBTITLE

DETAIL MARKS
DETAIL NUMBER
DRAWING NUMBER
ELEVATION MARK


SECTION MARKS
SECTION NUMBER
DRAWING NUMBER
SECTION MARKS

ROOM TAG
ROOM NAME
ROOM NUMBER
ROOM TAG

ELEVATION REFERENCE
SLAB
ELEVATION HEIGHT
ELEVATION DATUM
CEILING TYPE
CEILING HEIGHT
CEILING TAG
DOOR NUMBER
EQUIPMENT
WALL TYPES
WINDOW TAG
FINISH TAG
NOTES TAG

PROJECT TEAM DIRECTORY

ARCHITECT:	NATIONAL RESTAURANT DESIGNERS Glen R. Lettman 3177 3005 CARRINGTON MILL BLVD SUITE 150 MORRISVILLE, NC 27560 PH: (919) 544-0087 x129 FAX: (919) 544-9399
CIVIL ENGINEER:	TRANGLE SITE DESIGN, PLLC 4004 BARRIE DR. STE 101 RALEIGH, NC 27609 PH: (919) 553-6370
STRUCTURAL ENGINEER:	BRITTY PETERS AND ASSOCIATES INC. BRET UNDERWOOD 030467 993 WATERSIDE DRIVE SUITE 2202 WORWICK, VA 23510 PH: (257) 965-9710
MECHANICAL ENGINEER:	NATIONAL RESTAURANT DESIGNERS JOSEPH MORGAN 040760 3005 CARRINGTON MILL BLVD SUITE 150 MORRISVILLE, NC 27560 PH: (919) 544-0087 x129 FAX: (919) 544-9399
ELECTRICAL ENGINEER:	NATIONAL RESTAURANT DESIGNERS DOUGLAS R. STOCKS 040760 3005 CARRINGTON MILL BLVD SUITE 150 MORRISVILLE, NC 27560 PH: (919) 544-0087 x129 FAX: (919) 544-9399
PUMPING ENGINEER:	NATIONAL RESTAURANT DESIGNERS SHAWN D. SLYTER 32076 3005 CARRINGTON MILL BLVD SUITE 150 MORRISVILLE, NC 27560 PH: (919) 544-0087 x129 FAX: (919) 544-9399

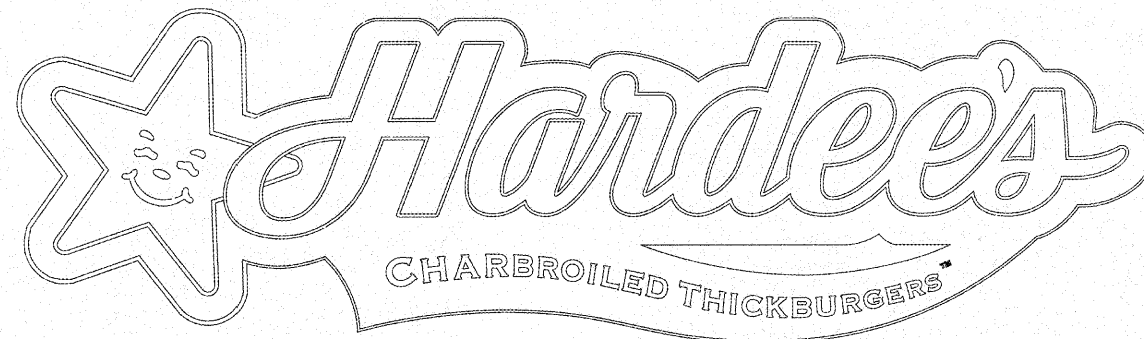

BNE WOOD PROTOTYPE REVERSE W/ BRICK VENEER

HARDEE'S
500 US-117, BURGAW, NC 28425

SHEET INDEX

TITLE	REVISION
T-1 TITLE SHEET	
T-2 OCCUPANCY PLAN AND LIFE SAFETY PLANS	
T-3 APPENDIX B	
T-4 ADDENDUM LIST	
CIVIL	
COVER COVER SHEET	
CE-01 EXISTING CONDITIONS	
CE-02 DEMOLITION PLAN	
CE-03 SITE PLAN	8/11/17
CE-04 UTILITY PLAN	8/11/17
CE-05 GRADING AND DRAINAGE PLAN	8/11/17
CE-06 LANDSCAPE PLAN	
CE-07 EROSION CONTROL PLAN	
D-01 EROSION CONTROL DETAILS	
D-02 SITE NOTES	
D-03 SITE DETAILS	
D-04 NDOT DETAILS	
STRUCTURAL	
S-1 FOUNDATION PLAN	
S-2 ROOF FRAMING PLAN	
S-3 FOUNDATION DETAILS	
S-4 FRAMING DETAILS	
S-5 FRAMING DETAILS	
S-6 STRUCTURAL DETAILS & FRAMING ELEVATIONS	
S-7 STRUCTURAL NOTES	
ARCHITECTURAL	
A-0 CONSTRUCTION PLAN/DETAILS	
A-1.1 FINISHES PLAN, INTER. FIN. SCHED. & DOOR/WINDOWS SCHED.	
A-2.0 REFLECTED CEILING PLAN	
A-3.0 ROOF PLAN/DETAILS	
A-4.0 EXTERIOR ELEVATIONS/EXTERIOR FINISHES SCHEDULE	
A-4.1 EXTERIOR ELEVATIONS/EXTERIOR FINISHES SCHEDULE	
A-5.0 INTERIOR ELEVATIONS/SECTIONS	
A-5.1 INTERIOR ELEVATIONS/SECTIONS	
A-5.2 INTERIOR ELEVATIONS	
A-6.0 WALL SECTIONS	
A-6.1 WALL SECTIONS	
A-6.2 WALL SECTIONS/DETAILS	
A-7.0 ENLARGED RESTROOM PLAN & DETAILS	
A-7.1 RESTROOM ELEVATIONS & DETAILS	
A-8.0 MISCELLANEOUS DETAILS	
A-8.1 DRIVE-THRU DETAILS	
A-8.1.1 DRIVE-THRU DETAILS	
A-8.2 DUMPSTER ENCLOSURE & ROOF LADDER DETAILS	
A-8.3 SHED ENCLOSURE	
REF-1, REF-2 & REF-3 E.F.I.S. MANUFACTURER'S DTLS. (FOR REF.)	
KITCHEN EQUIPMENT (FOR REFERENCE)	
QF001 FOOD SERVICE GENERAL NOTES, SHEET INDEX	
QF002 FOOD SERVICE EQUIPMENT SCHEDULES	
QF003 FOOD SERVICE EQUIPMENT LAYOUT	
QF201 IN-SLAB PLUMBING ROUGH-INS	
QF202 ABOVE SLAB PLUMBING ROUGH-INS	
QF301 ELECTRICAL ROUGH-IN PLAN	
QF401 SPECIAL CONDITIONS	
QF501 FOOD SERVICE NOTES & DETAILS	
QF601 ELEVATIONS	
QF602 ELEVATIONS	
QF701 MANUFACTURER HOOD DRAWING	
QF702 MANUFACTURER HOOD DRAWING	
QF703 MANUFACTURER WALK-IN COOLER DRAWING	
PLUMBING	
P-1 WASTE AND VENT PLAN	
P-2 WATER PLAN	
P-3 PLUMBING ISOMETRIC & DETAILS	
P-4 ROOF PLAN & DETAILS	
MECHANICAL	
M-1 HVAC PLAN	
M-2 MECHANICAL DETAILS	
ELECTRICAL	
E-1 ELECTRICAL POWER PLAN	
E-1.1 C/R SYSTEM PLAN	
E-2 LIGHTING PLAN	
E-3 SCHEDULE/ELECTRICAL DISTRIBUTION	
E-4 ROOF POWER PLAN	
E-5 ELECTRICAL SITE LIGHTING PLAN	
E-6 RISER DIAGRAM	
CPI - CONTROL + ENERGY MANAGEMENT INFO. (FOR REFERENCE)	
CPI-0.1 CHECK LIST	
CPI-1.0 ELEVATIONS, DETAILS & PANEL SCHEDULES	
CPI-1.1 CONNECTION INFO.	
CPI-1.2 C.T. DETAILS	
CPI-2.0 SCHEMATICS	
CPI-2.1 SCHEMATICS	
CPI-2.2 SCHEMATICS	
CPI-2.3 SCHEMATICS	

ABBREVIATIONS

Ø DIAMETER	JT. JOINT
□ SQUARE FOOT/FEET	LAM. LAMINATED
△ CENTERLINE	LAV. LAVATORY
⊕ POUND OR NUMBER	LT. LIGHT
⊖ EXISTING	MAX. MAXIMUM
(N) NEW	M.B. MACHINE BOLT
A.B. ANCHOR BOLT	MET. MECHANICAL
A.C. AIR CONDITIONING	MFR. MANUFACTURER
ACOUS. ACOUSTICAL	M.I. MINIMUM
AF. ABOVE FINISH FLOOR	MISC. MISCELLANEOUS
ALUM. ALUMINUM	M.O. MASONRY OPENING
APPROX. APPROXIMATE	M.T.D. MULLION
ARCH. ARCHITECTURAL	M.U. MULLION
A.S.R. AUTOMATIC SPRINKLER SYSTEM	
BD. BOARD	N. NORTH
BLDG. BUILDING	N.C. NOT IN CONTRACT
BLK. BLOCK	N.O. NUMBER
BLKG. BLOCKING	NOM. NOMINAL
	N.T.S. NOT TO SCALE
CJ. CEILING JOIST	O.A. OVERALL
CL. CEILING	OC. ON CENTER
CLR. CLEAR	OD. OUTSIDE DIAMETER
C.M. CONSTRUCTION	OD. OVERFLOW DRAIN
MANAGER	OFF. OPPOSITE
C.M.U. CONCRETE MASONRY UNIT	OFF. OFFSET
CONC. CONCRETE	PART. PARTITION
CONN. CONNECTION	P.L. PROPERTY LINE
CONSTR. CONSTRUCTION	PL. PLASTER
CONT. CONTINUOUS	PLCB. PLUMBING
CONTR. CONTRACTOR	PLYWD. PLYWOOD
	P.T. PRESSURE TREATED
DBL. DOUBLE	Q.T. QUARRY TILE
DEPT. DEPARTMENT	
DET. DETAIL	R. RISER
D.F. DRINKING FOUNTAIN	RAD. RADIUS
DI. DIAMETER	R.D. ROOF DRAIN
DM. DIMENSION	REF. REFERENCE
DS. DOWN SPOUT	REFR. REFRIGERATOR
DWG. DRAWING	REIN. REINFORCED
	REQD. REQUIRED
E. EAST	RES. RESILIENT
EA. EACH	RM. ROOM
ELEC. ELECTRICAL	R.O. ROUGH OPENING
EL. ELEVATION	R.O.W. RIGHT OF WAY
E.P. ELECTRICAL PANEL	
EQ. EQUAL	S. SOUTH
EQUIP. EQUIPMENT	S.A.N. SCALE AS NOTED
E.W. EACH WAY	S.A.T. SUSPENDED
EXT. EXTERIOR	S.C. SOLID CORE
	SCHED. SCHEDULE
F.F. FINISH FLOOR	SECT. SECTION
FIN. FINISH	SHT. SHEET
FIX. FIXTURE	SHTG. SHEATHING
FLOOR. FLOOR	SIM. SIMILAR
F.L. FLOW LINE	SPEC. SPECIFICATION
FLUOR. FLUORESCENT	SQ. SQUARE
F.H. FIRE HYDRANT	SS. SERVICE SINK
F.O.F. FACE OF FINISH	SS. STAINLESS STEEL
F.O.M. FACE OF MASONRY	STD. STANDARD
F.O.S. FACE OF STUD	ST. STEEL
F.S. FLOOR SINK	STR. STRUCTURE
F.S.R. FIRE SPRINKLER	SYMM. SYMMETRICAL
	T. TOP
FT. FOOT/FEET	T.O.P. TOP OF FINISH
FTG. FOOTING	T.O.P. TOP OF GRADE
FUT. FUTURE	T.O.P. TOP OF PARALLEL
	T.O.S. TOP OF SCHEDULED
GAL. GAUGE	TYP. TYPE
GALV. GALVANIZED	
G.C. GENERAL CONTRACTOR	U.C. UNIFORM BUILDING CODE
G.I. GALVANIZED IRON	U.O.N. UNLESS OTHERWISE NOTED
GL. GLASS	
GND. GROUND	V.B. VINYL BASE
	VERT. VERTICAL
	V.C.T. VINYL COMPOSITION TILE
	V.T.R. VENT THROUGH ROOF
	W. WEST
	W. WITH
	W.C. WATER CLOSET
	WD. WOOD
	W.H. WATER HEATER
	WO. WITHOUT
	W.R. WATER RESISTANT

ENERGY CODE SUMMARY

2012 NORTH CAROLINA ENERGY CONSERVATION CODE


SEE T-3 FOR CODE SUMMARY

BUILDING CODE SUMMARY

2014 NORTH CAROLINA BUILDING CODE, 2014 NORTH CAROLINA FIRE PREVENTION CODE, 2014 NORTH CAROLINA MECHANICAL CODE, 2014 NATIONAL ELECTRICAL CODE, 2014 NORTH CAROLINA PLUMBING CODE, 2014 NORTH CAROLINA GAS CODE

SEE T-3 FOR CODE SUMMARY

VICINITY MAP

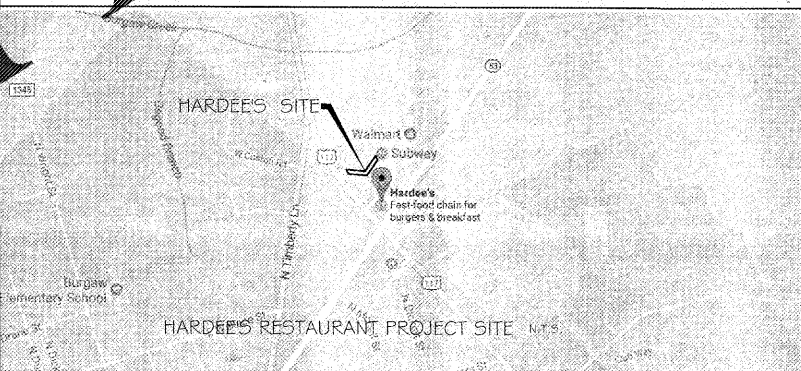

NRO Project # 17113

national restaurant designers
ARCHITECTS & ENGINEERS
3005 CARRINGTON MILL BLVD SUITE 150
MORRISVILLE, NC 27560
PH: (919) 544-0087
FAX: (919) 544-9399
A. DIVISION OF L.M.S.T., A. 000000168

ASSOCIATES P.A.
CERT. NO. 178
L.M.S.T. ARCHITECTS & ENGINEERS
3177
3005 CARRINGTON MILL BLVD SUITE 150
MORRISVILLE, NC 27560
PH: (919) 544-0087
FAX: (919) 544-9399

Hardee's
HARDEE'S REVERSE PROTOTYPE
500 US-117
BURGAW, NC 28425

OWNER:
BODDIE-NOELL ENTERPRISES, INC.
P.O. BOX 1908
ROCKY MOUNT, NC 27802-1908
(252) 937-2800

NO.	REVISIONS	DESCRIPTION	DATE

TITLE SHEET

DATE: 6-23-17

SHEET NUMBER: T-1

Order Plans @