



 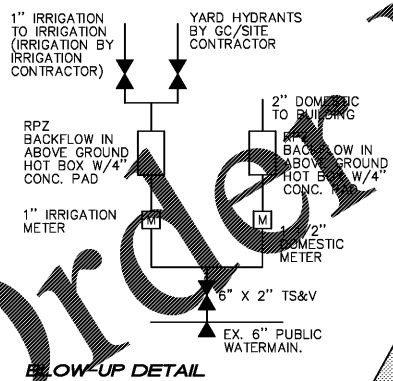


EXISTING UTILITIES

NO.	DESCRIPTION	DEPTH

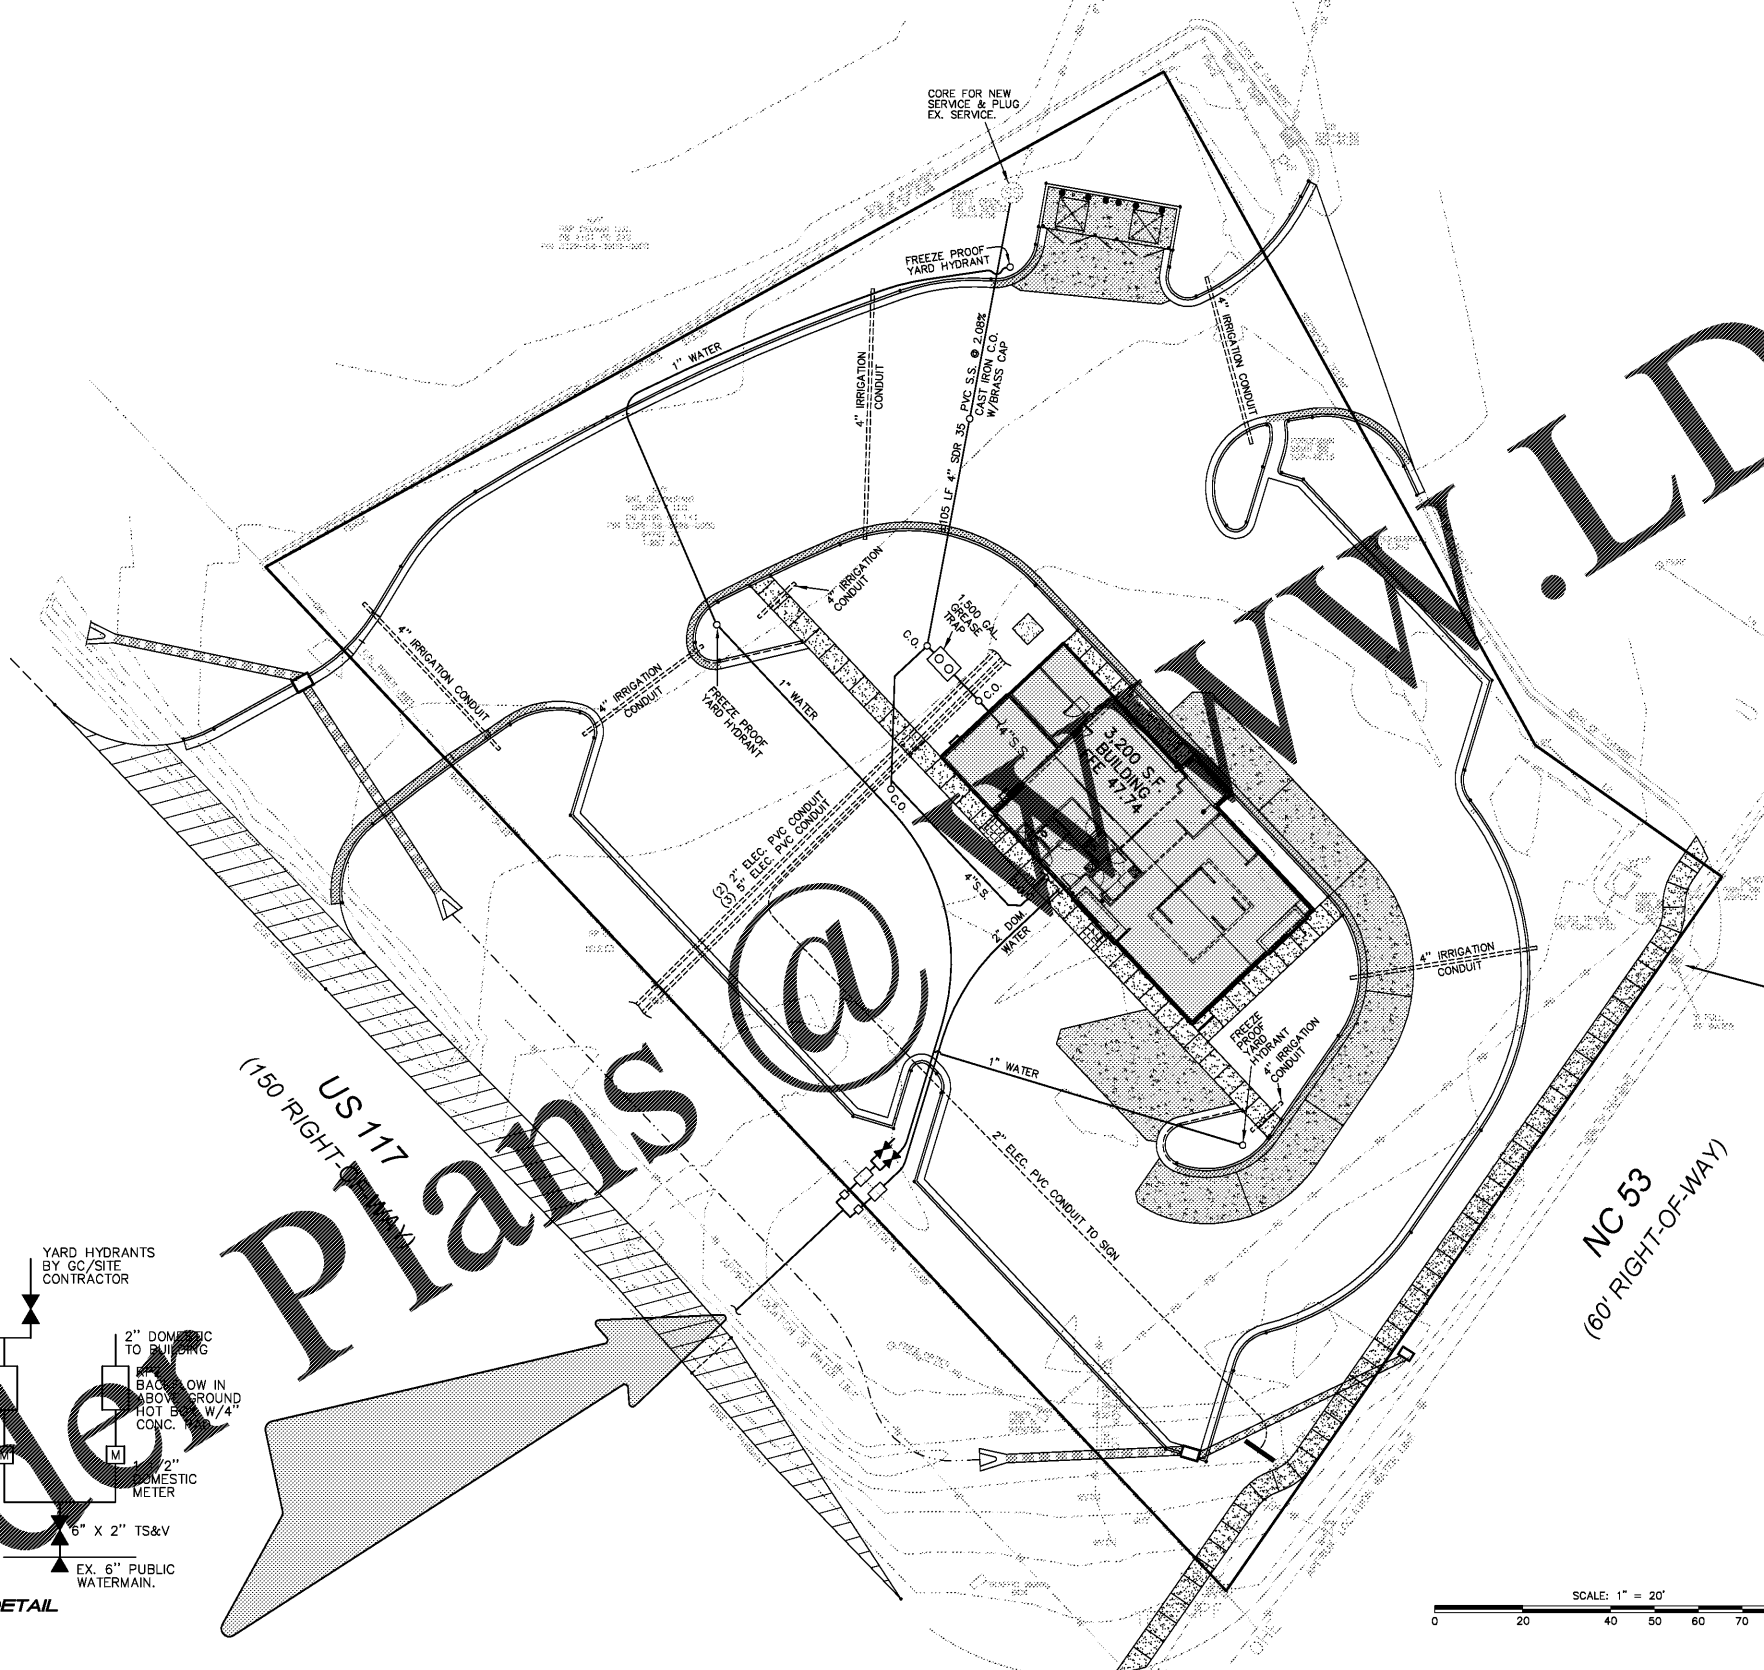

Blow-up Detail
NOT TO SCALE



Order Plans

NC GRID NORTH NAD 83/2011

CONTRACTOR TO CHECK FUNCTIONALITY OF EXISTING YARD INLET
ONCE DRAINAGE IMPROVEMENTS HAVE BEEN MADE TO ENSURE
YARD INLET IS DRAINING PROPERLY.

www.LDILine.com

STOCKS ENGINEERING
801 EAST WASHINGTON STREET
NASHVILLE, N.C. 27856
P.O. BOX 1108
PHONE: (252) 459-8196
WWW.STOCKSENGINEERING.COM

BLN-C-1874
Hardees
ROCKY MOUNT, N.C.
27602-9008
(252) 387-2800

ENC
HARDEES at
U.S. 117 & N.C. 53
BURGAW, N.C.

SEAL
19843
ENGINEER
MICHAEL STOCKS
7/14/17

UTILITY PLAN

REVISIONS
8/11/2017 BURGAW

FILE NO: 2017-013
HORIZ. SCALE: 1"=20'
VERT. SCALE: NONE

CE-04