


BODDIE NOELL  
ENTERPRISES, INC.  
P.O. BOX 1908  
ROCKY MOUNT, N.C.  
27802-1908  
(252) 937-2800

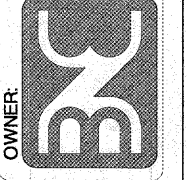


NO.	DESCRIPTION	DATE

DRAWN BY: \_\_\_\_\_ CHECKED BY: \_\_\_\_\_

**ROOF POWER PLAN**


DATE: 6-23-17

SHEET NUMBER:  
**E4**

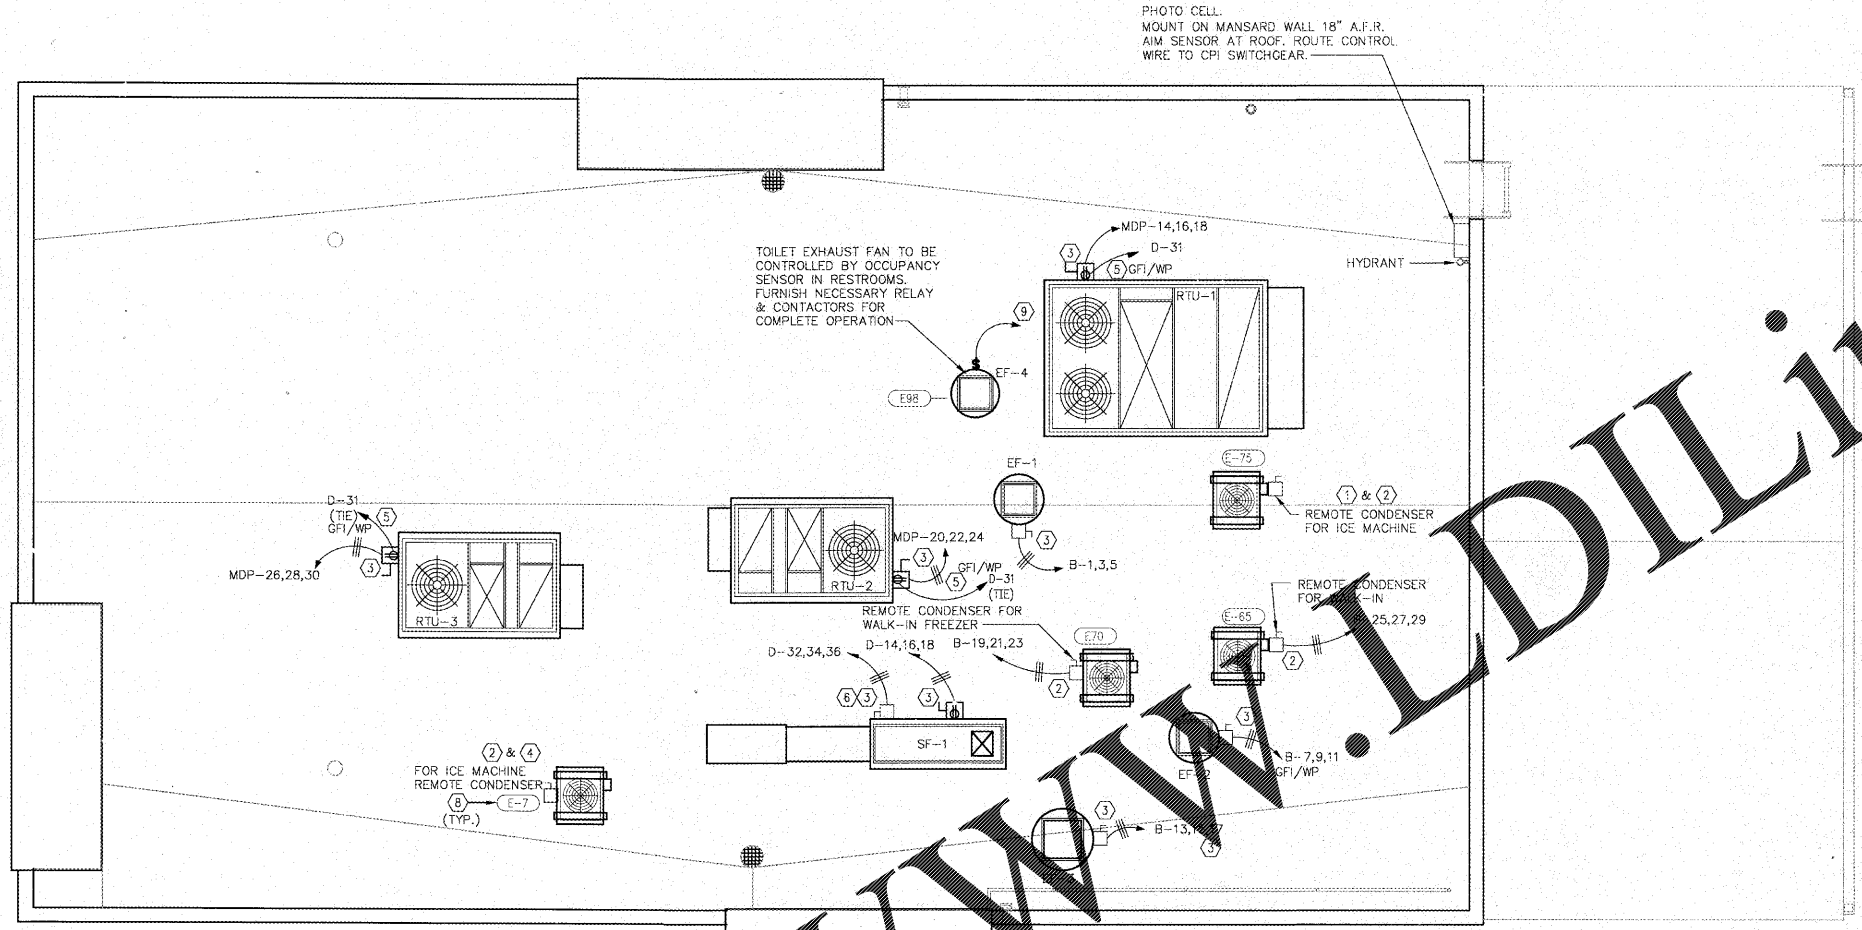

ROOF POWER PLAN

SCALE: 1/4" = 1'-0" 1

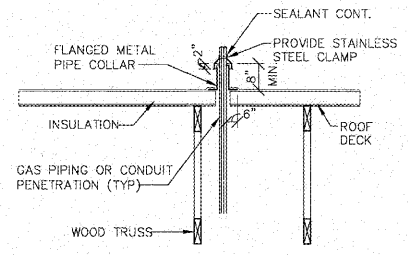

PIPE SEAL THRU ROOF

N.T.S. 3 SHEET NOTES

NOTE: SEE SHEETS CPI-1.0 THRU CPI-2.3 FOR CPI INFORMATION RELATED TO WIRING OF CONTROLS & ENERGY MANAGEMENT.

**NOTES:**

- 1 ICE MACHINE CONDENSER POWERED IS FROM ICE MACHINE IN KITCHEN.
- 2 E.C. TO FURNISH & INSTALL NEMA 3R WEATHERPROOF DISCONNECT.
- 3 NEMA 3R DISCONNECT SWITCH FURNISHED W/ EQUIPMENT.
- 4 ICE MACHINE CONDENSER POWER IS FROM ICE MACHINE ON BEVERAGE TOWER AT SELF SERVE BAR.
- 5 WP/ GFCI: 20A DUPLEX FACTORY INSTALLED W/ RTU, E.C. TO PROVIDE WIRING.
- 6 FOR MUA ELECTRICAL HEATER, VERIFY WIRING WITH MFG.
- 7 NOT USED.
- 8 EQUIPMENT TAGS, SEE QF100 & QF300 FOR ADDITIONAL INFORMATION
- 9 CIRCUIT TO RESTROOM LIGHTING CIRCUIT SEE SHEET E2.0.

**GENERAL NOTE:**

- SEE SHEET E6 FOR "CONDUIT CONDUCTOR SCHEDULE" IF WIRING IS NOT INDICATED.
- ROOFTOP RECEPTACLES REQUIRED WITHIN 25' OF MECHANICAL EQUIPMENT.