


Luminaire Schedule								
Symbol	Qty	Label	Arrangement	Lumens/Lamp	LLF	Lum. Watts	Description	BUG Rating
	14	N	SINGLE	2722	1.000	25	XSPW-A-O-3-M-G-U-T	B1-U0-G1
	4	PL	SINGLE	11648	1.000	86	OSQ-A-NM-4ME-B-57K-UL-BK + OSQ-DABK	B2-U0-G2

Calculation Summary; LLF=1.00					
Label	Avg	Max	Min	Avg/Min	Max/Min
Calc Pts	2.25	8.2	0.5	4.50	16.40

FIXTURE MOUNTING HEIGHTS:  
 N MOUNTED - 10' AFG  
 PL MOUNTED - 25' AFG

ADDITIONAL EQUIPMENT REQUIRED:  
 (4) CL-SSP-4011-25-D1-BK (25' x 4"sq STEEL POLE, SINGLE MOUNT)  
 (4) OSQ-DABK DIRECT ARM MOUNT

\*\*\*ALL FIXTURES ARE FULL CUTOFF (UPLIGHT=0)

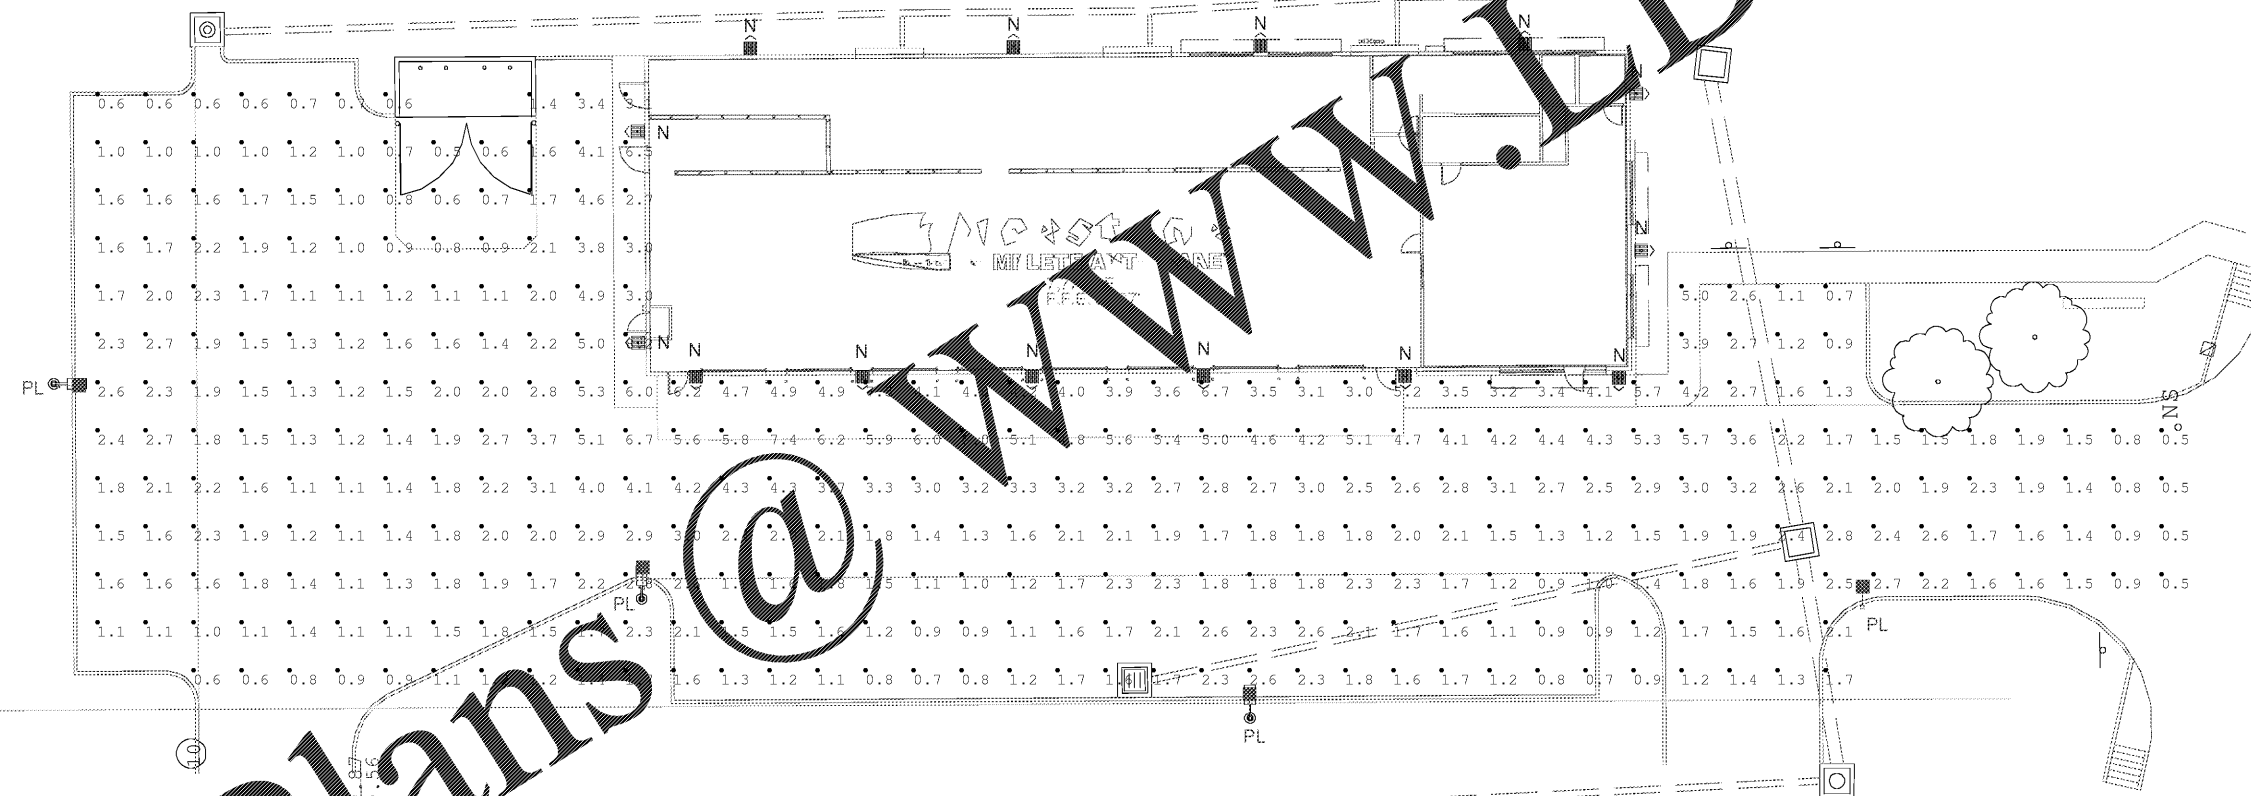

Order Plans @

Customer responsible to verify ordering information/  
 catalogue number prior to placing order.



1200 92nd Street - Sturtevant, WI 53177  
 www.cree.com - (800) 236-6800

Project Name: Firestone- Williamsburg, VA

SR: 25002

Date: 8/7/2017

Scale: 1"=30'

Footcandles calculated at grade

Filename: FRS-170727WIVAABMR1.AGI

Layout by: Amy McIntosh

illumination results shown on this lighting design are based on project parameters provided to Cree, Inc. used in conjunction with luminaire test procedures conducted under laboratory conditions. Actual project conditions differing from these design parameters may affect field results. The customer is responsible for verifying dimensional accuracy along with compliance with any applicable electrical, lighting, or energy code.

