


SITE LIGHTING PLAN GENERAL NOTES

1. CONTRACTOR TO PROVIDE AND INSTALL ALL CONDUIT, WIRE AND DEVICES REQUIRED FOR MONUMENT SIGN. VERIFY LOCATION AND REQUIREMENTS WITH SIGN MANUFACTURER PRIOR TO ROUGH-IN.
2. PROVIDE ALL GROUNDING FOR MONUMENT SIGN PER MANUFACTURER'S AND LOCAL CODE REQUIREMENTS.
3. REFER TO SHEET E1 FOR BUILDING MOUNTED LIGHT FIXTURE LOCATIONS AND DESIGNATIONS.
4. REFER TO SHEET E3 FOR LIGHT FIXTURE SCHEDULE.
5. ALL LIGHTING FIXTURES SHALL BE FULL CUT OFF (UPLIGHT = 0).

Ⓢ SITE LIGHTING PLAN KEY NOTES

1. REFERENCE SHEET E5 FOR CONTACTOR DIAGRAM AND PANELBOARD SCHEDULES.
2. LIGHT FIXTURE AND POLE BASE BY OTHERS.

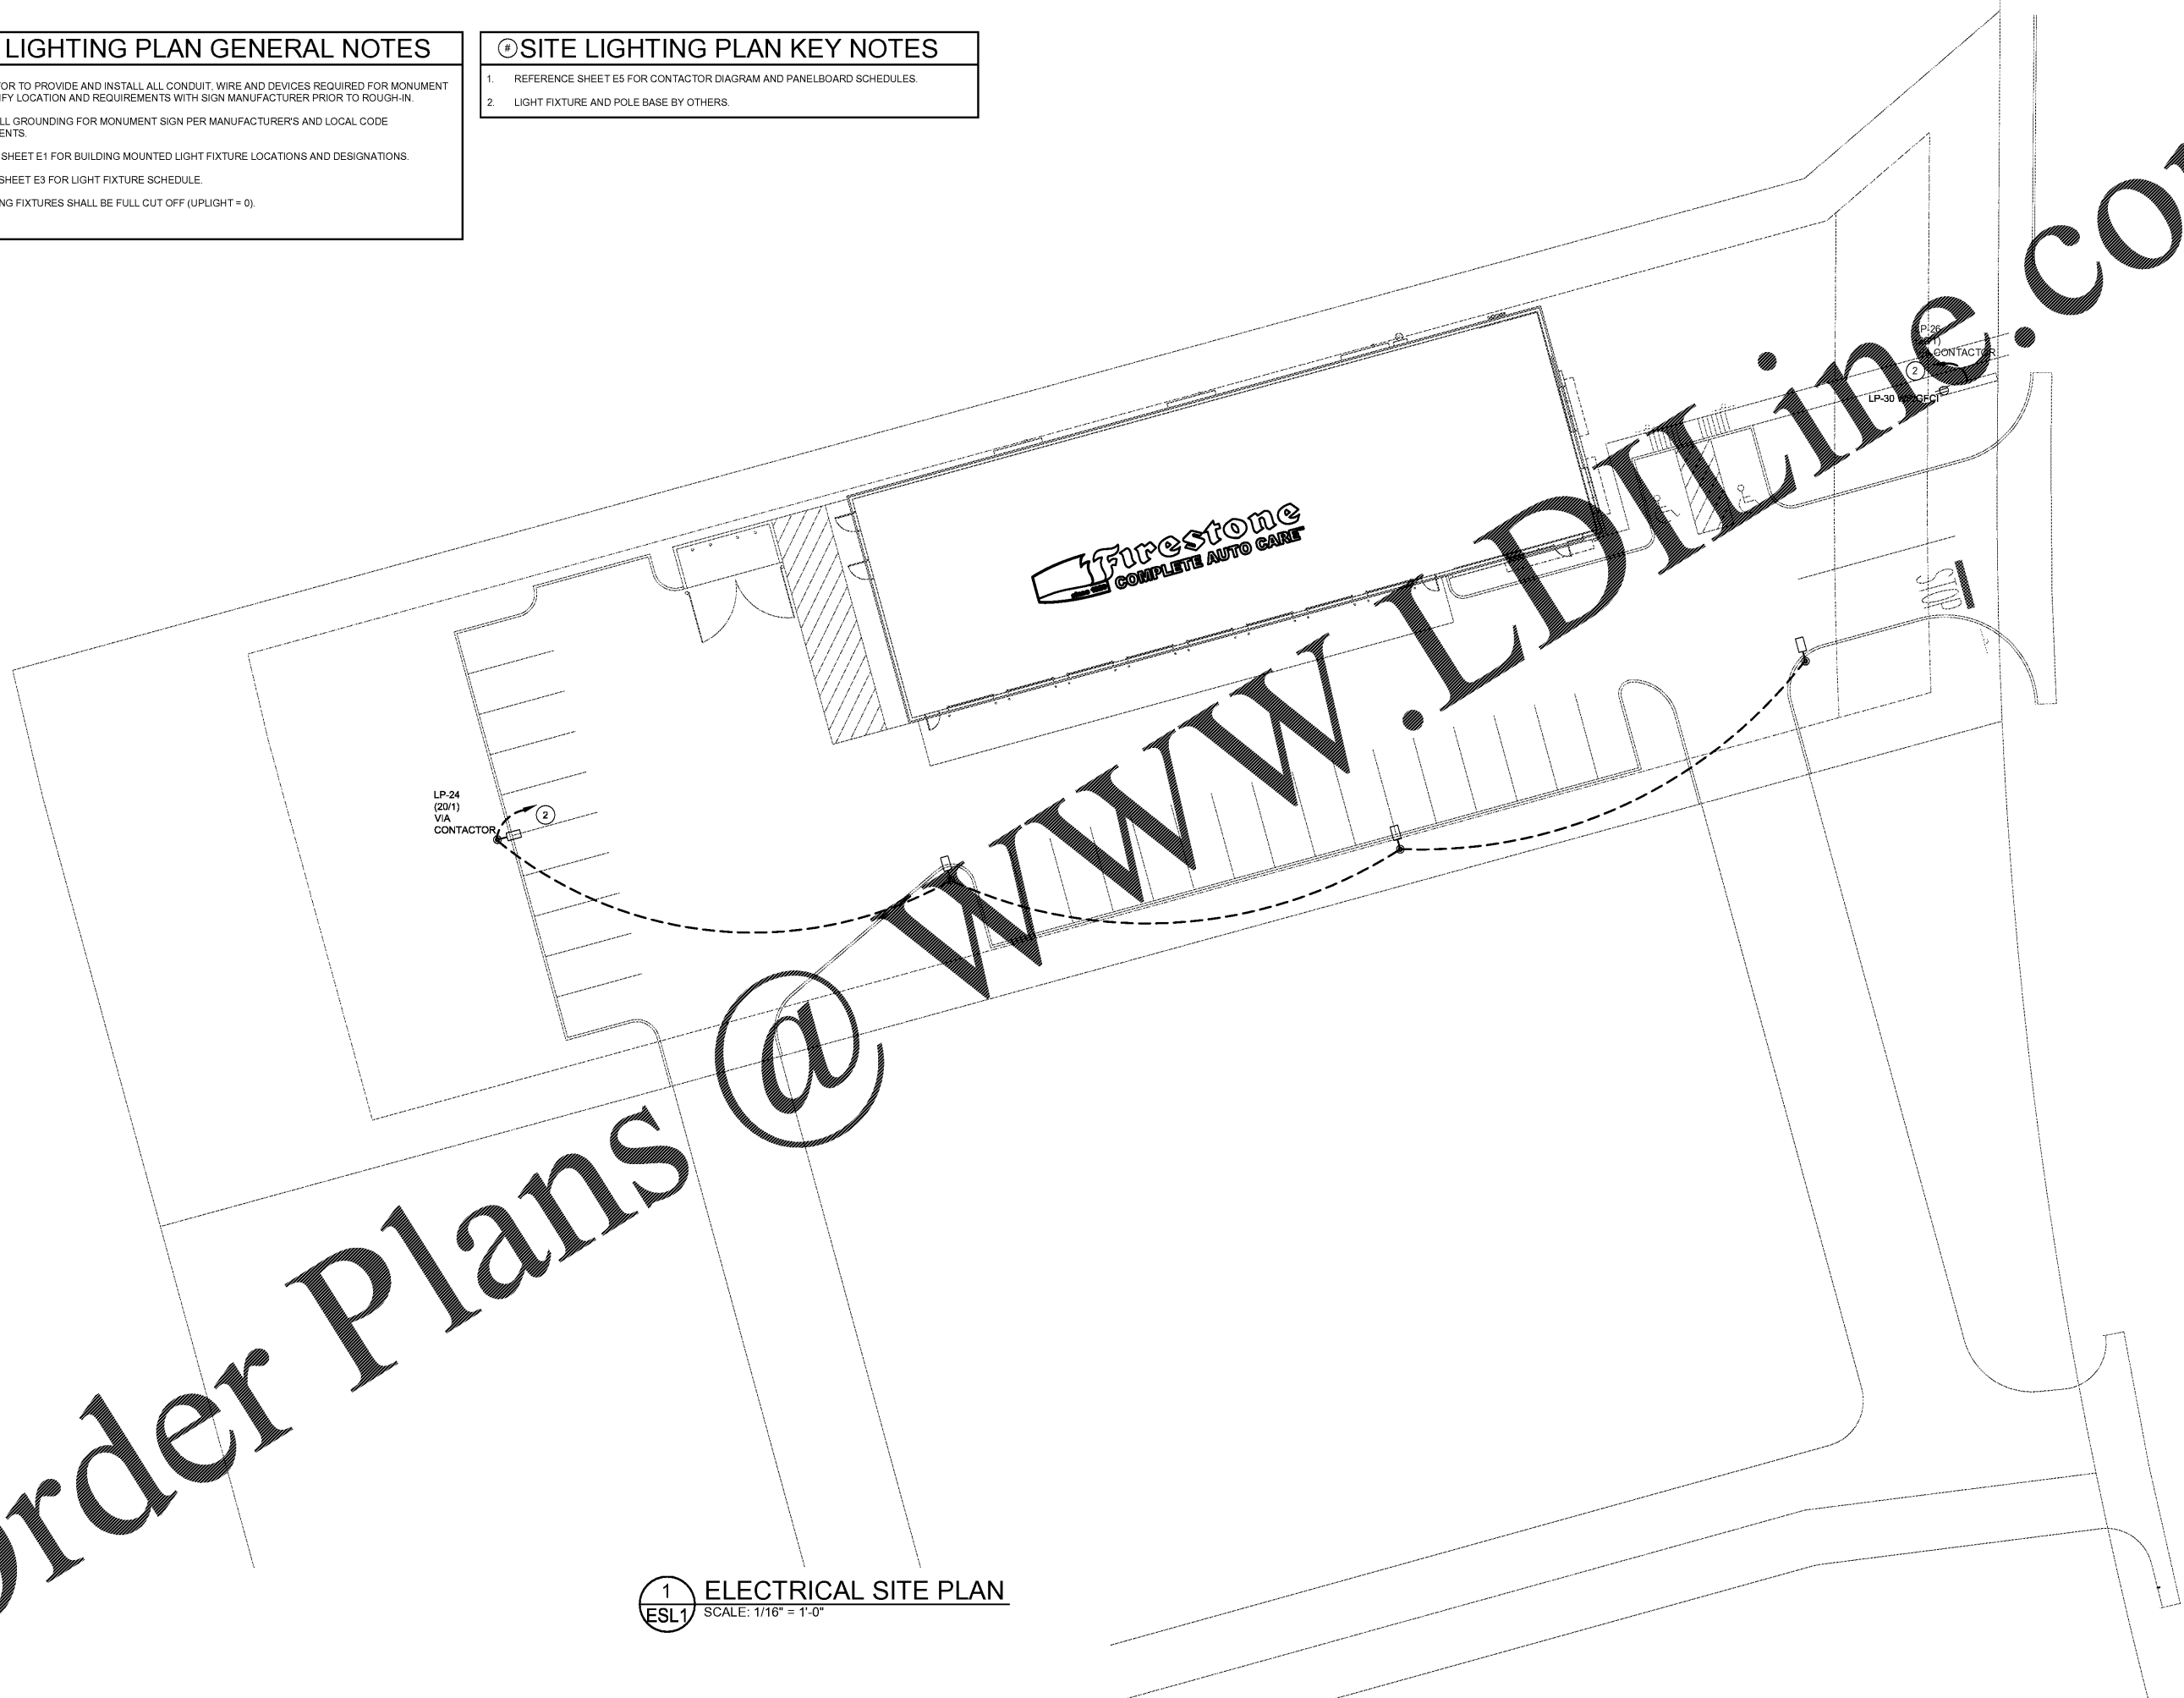

Aug. 08, 2017 - 3:37pm - USER: ryannc@wvnc.com - S:\Bridgestone-Firestone\Engineering\1720255-BRRO - Williamsburg, VA\Sheets\ESI - Site Lighting Plan.dwg

Order Plans @

1 ELECTRICAL SITE PLAN
ESL1 SCALE: 1/16" = 1'-0"


PEP Engineer of Record
Randall Nelson, P. E.
148 West 95th Street
Lenexa, Kansas 66215
Phone 913 322 5150



THIS DRAWING IS THE PROPERTY OF BRIDGESTONE RETAIL OPERATIONS, LLC AND IS LOANED TO THE EXPRESS COVENANT THAT IT IS NOT TO BE USED IN ANY WAY DELEGATED TO THE INTERESTS OF BRIDGESTONE RETAIL OPERATIONS, LLC. THE ACCEPTANCE OF THIS DRAWING WILL BE CONSIDERED AS AN ACCEPTANCE OF THE FOREGOING CONDITION AND AS JURISDICTION TO THE BRIDGESTONE COMPLETE AUTO CARE, LLC.

REPRODUCTION OF THIS DRAWING FOR ANY OTHER PROJECT WITHOUT THE WRITTEN PERMISSION OF THE ENGINEER IS STRICTLY PROHIBITED. THIS DRAWING IS NOT TO BE USED FOR ANY OTHER PROJECT WITHOUT THE WRITTEN PERMISSION OF THE ENGINEER. THE USE OF THIS DRAWING FOR ANY OTHER PROJECT WITHOUT THE WRITTEN PERMISSION OF THE ENGINEER IS STRICTLY PROHIBITED. THE ENGINEER AND ARCHITECT ASSUME NO RESPONSIBILITY FOR THE PRODUCTION OF THIS DRAWING FOR ANY OTHER PROJECT IF NOT AUTHORIZED AND MAY BE CONSIDERED AS AN ACCEPTANCE OF THE FOREGOING CONDITION AND AS JURISDICTION TO THE BRIDGESTONE COMPLETE AUTO CARE, LLC.

NEW FCAC STORE
2015 - JUNE - ER - RIGHT
1900 RICHMOND ROAD
WILLIAMSBURG, VA

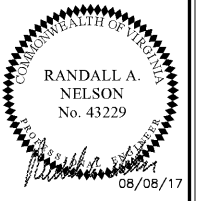

ISSUE BLOCK	

PROPERTY NO.: 167739
6 DIGIT NO.: 785533
4 DIGIT NO.: 6868
AOR PROJECT NUMBER: 1655B14
TO PERMIT: DATE: 08/10/17
TO BID: DATE: TBD
DRAWN BY: ZS,MJ,RC
CHECKED BY: CF,AR

SHEET TITLE:
SITE LIGHTING PLAN
SHEET NUMBER:
ESL1