



19

20


21

22

23

24

25

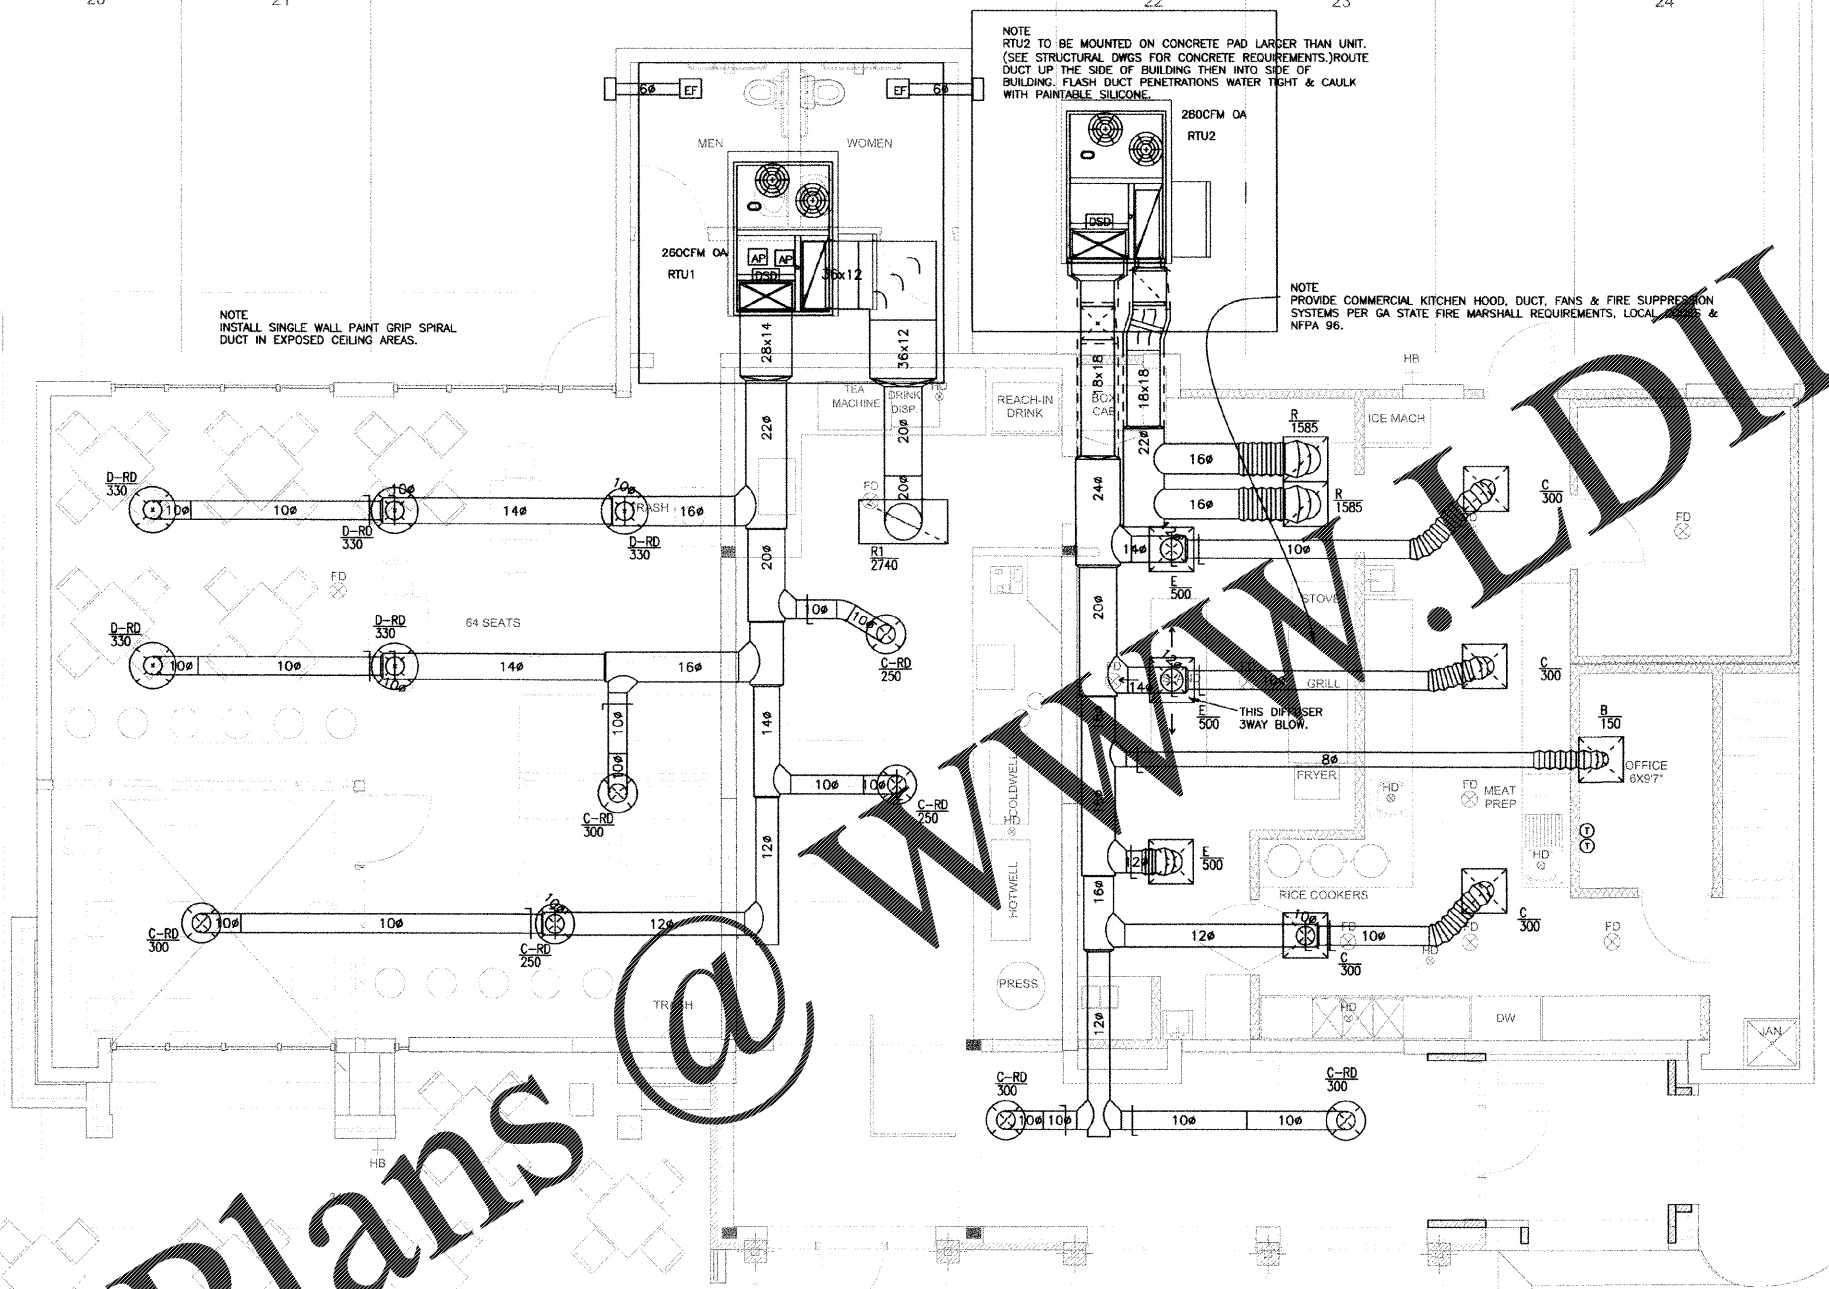

NOTE  
 INSTALL SINGLE WALL PAINT GRIP SPIRAL  
 DUCT IN EXPOSED CEILING AREAS.

NOTE  
 RTU2 TO BE MOUNTED ON CONCRETE PAD LARGER THAN UNIT.  
 (SEE STRUCTURAL DWGS FOR CONCRETE REQUIREMENTS).ROUTE  
 DUCT UP THE SIDE OF BUILDING THEN INTO SIDE OF  
 BUILDING. FLASH DUCT PENETRATIONS WATER TIGHT & CAULK  
 WITH PAINTABLE SILICONE.

NOTE  
 PROVIDE COMMERCIAL KITCHEN HOOD, DUCT, FANS & FIRE SUPPRESSION  
 SYSTEMS PER GA STATE FIRE MARSHALL REQUIREMENTS, LOCAL CODES &  
 NFPA 96.

WWW.LDLine.com

Order Plans @

**HVAC PLAN**

SCALE: 1/4" = 1'-0"

DIABLOS SOUTHWESTERN GRILLE  
 3102 Washington Rd.  
 Martinez, GA 30907

Print Record  
 11-19-15  
 Drawn By:  
 Checked by:  
 Date: 3/18/16

Revisions

Sheet Title  
**HVAC PLAN**

Sheet No.

**M-1**

Scale:  
 4/13/2016 5:51:28 PM