



Order Plans @

WWW.DIline.com

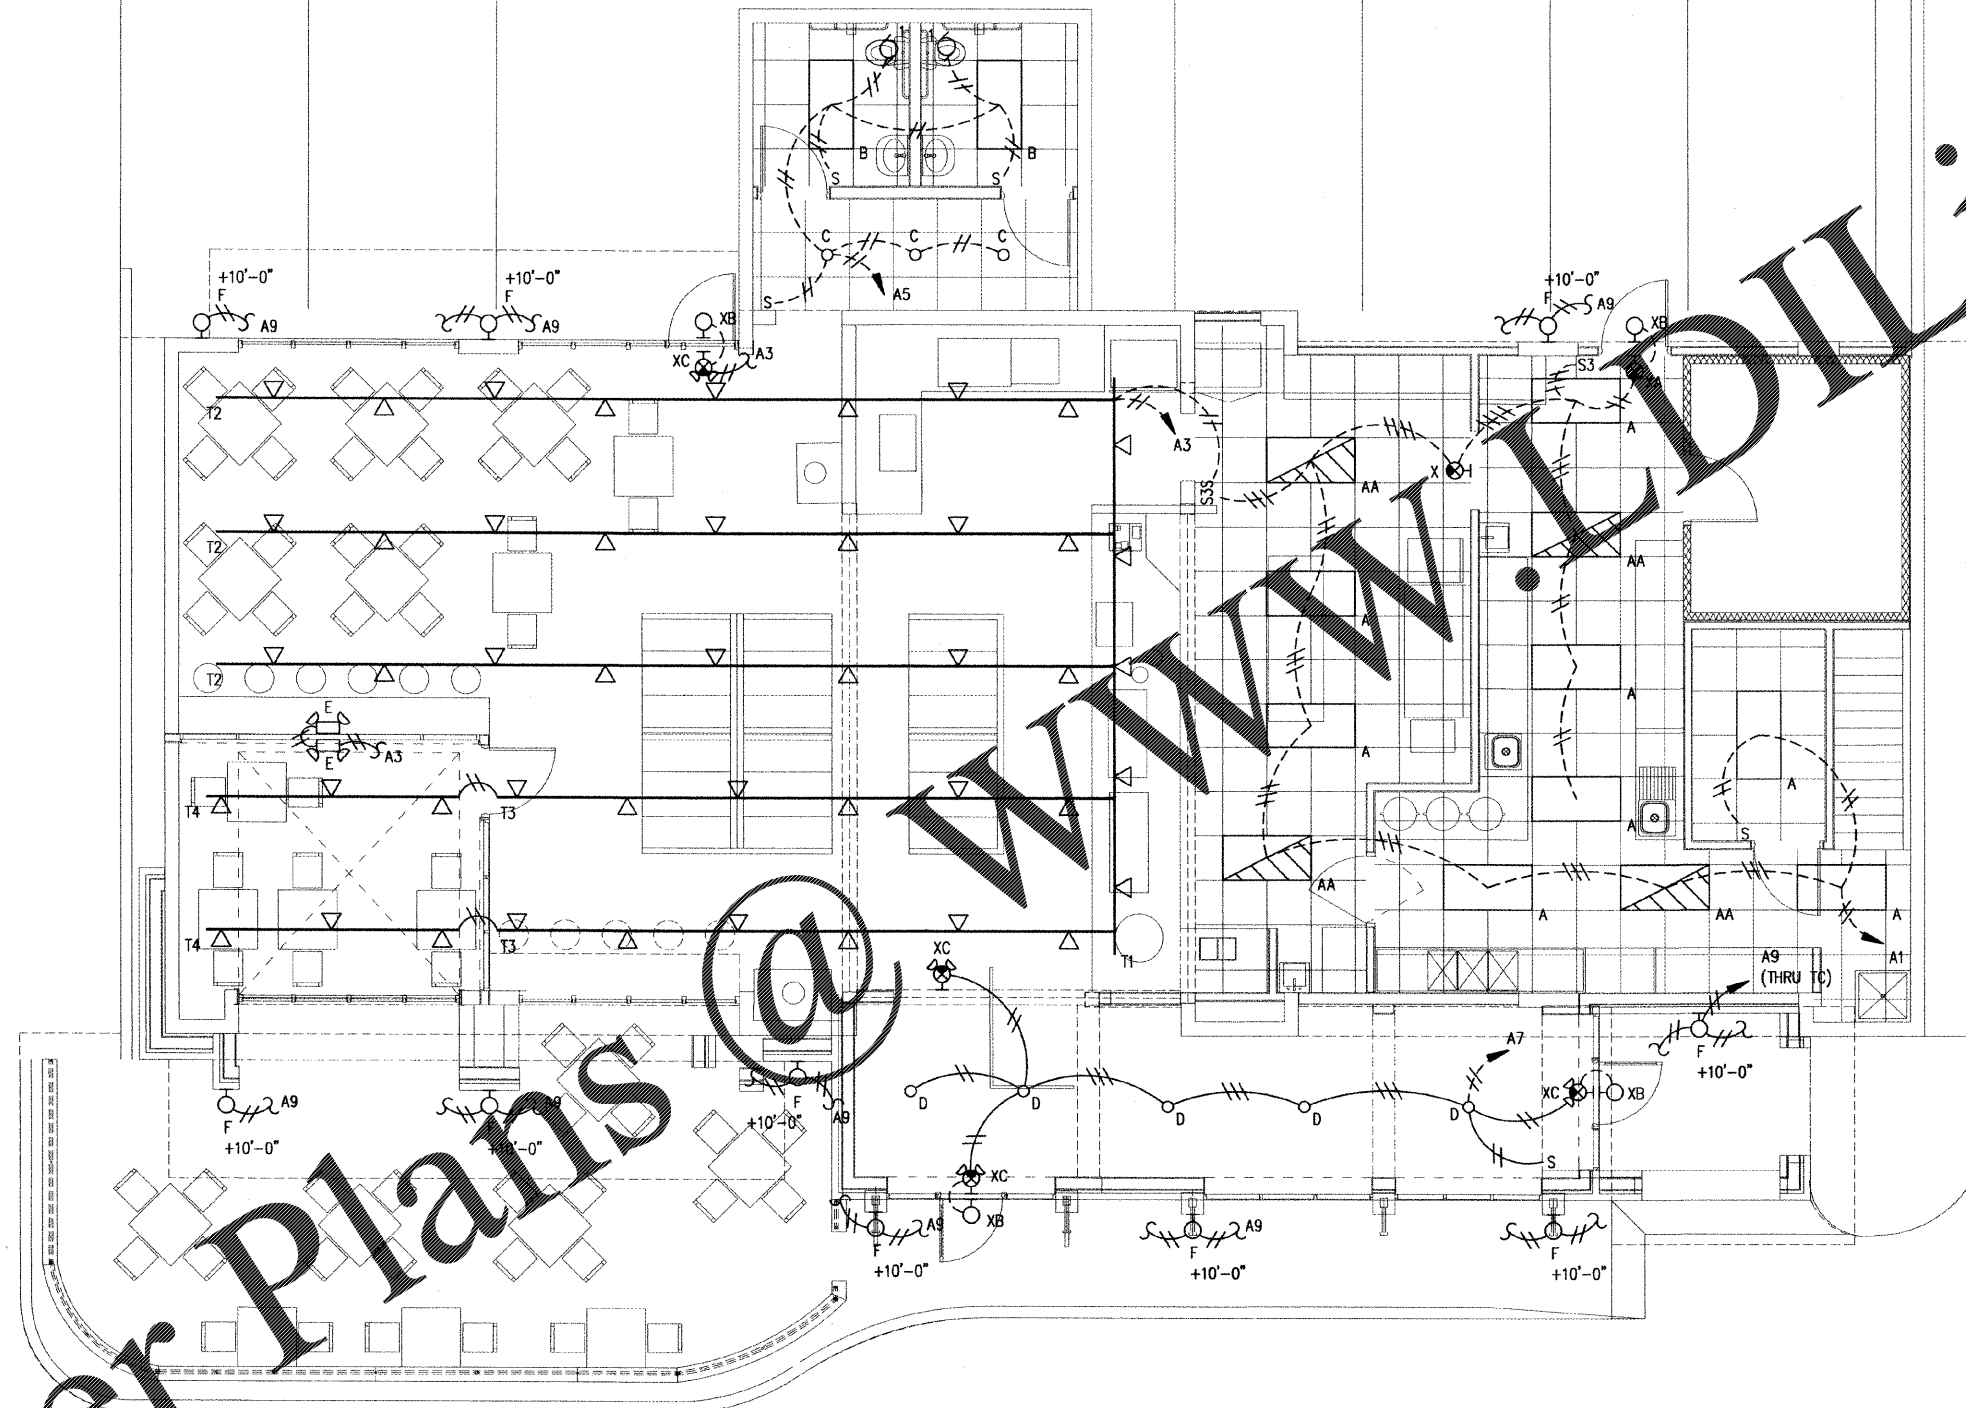

1 LIGHTING PLAN
E-01 SCALE: 1/4" = 1'-0"

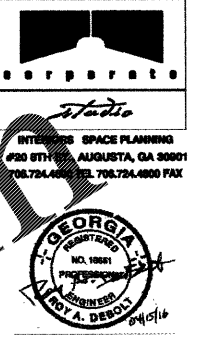

ALEKTROCON, LLC
PO BOX 21288
AUGUSTA, GEORGIA 30917-0288
TEL: (706) 886-8828
ALEKTROCON@GMAIL.COM

DIABLOS SOUTHWESTERN GRILLE

3102 Washington Rd.
Martinez, GA 30907

Date: 09.11.15

Approved by:

Print Record
11-19-15

Drawn By:
Checked by:
Date: 3/16/16

Revisions

| No. | Description |
|-----|-------------|
| | |
| | |
| | |
| | |
| | |

Sheet Title

Sheet No.

E-01

Scale:

2015 Copyright Alektron, Inc. These drawings are prepared by the registered professional architect. These drawings are not to be used for any other project without the written consent of Alektron, Inc.