


Order Plans @

WWW.DIline.com

1 POWER PLAN
E-02 SCALE: 1/4" = 1'-0"

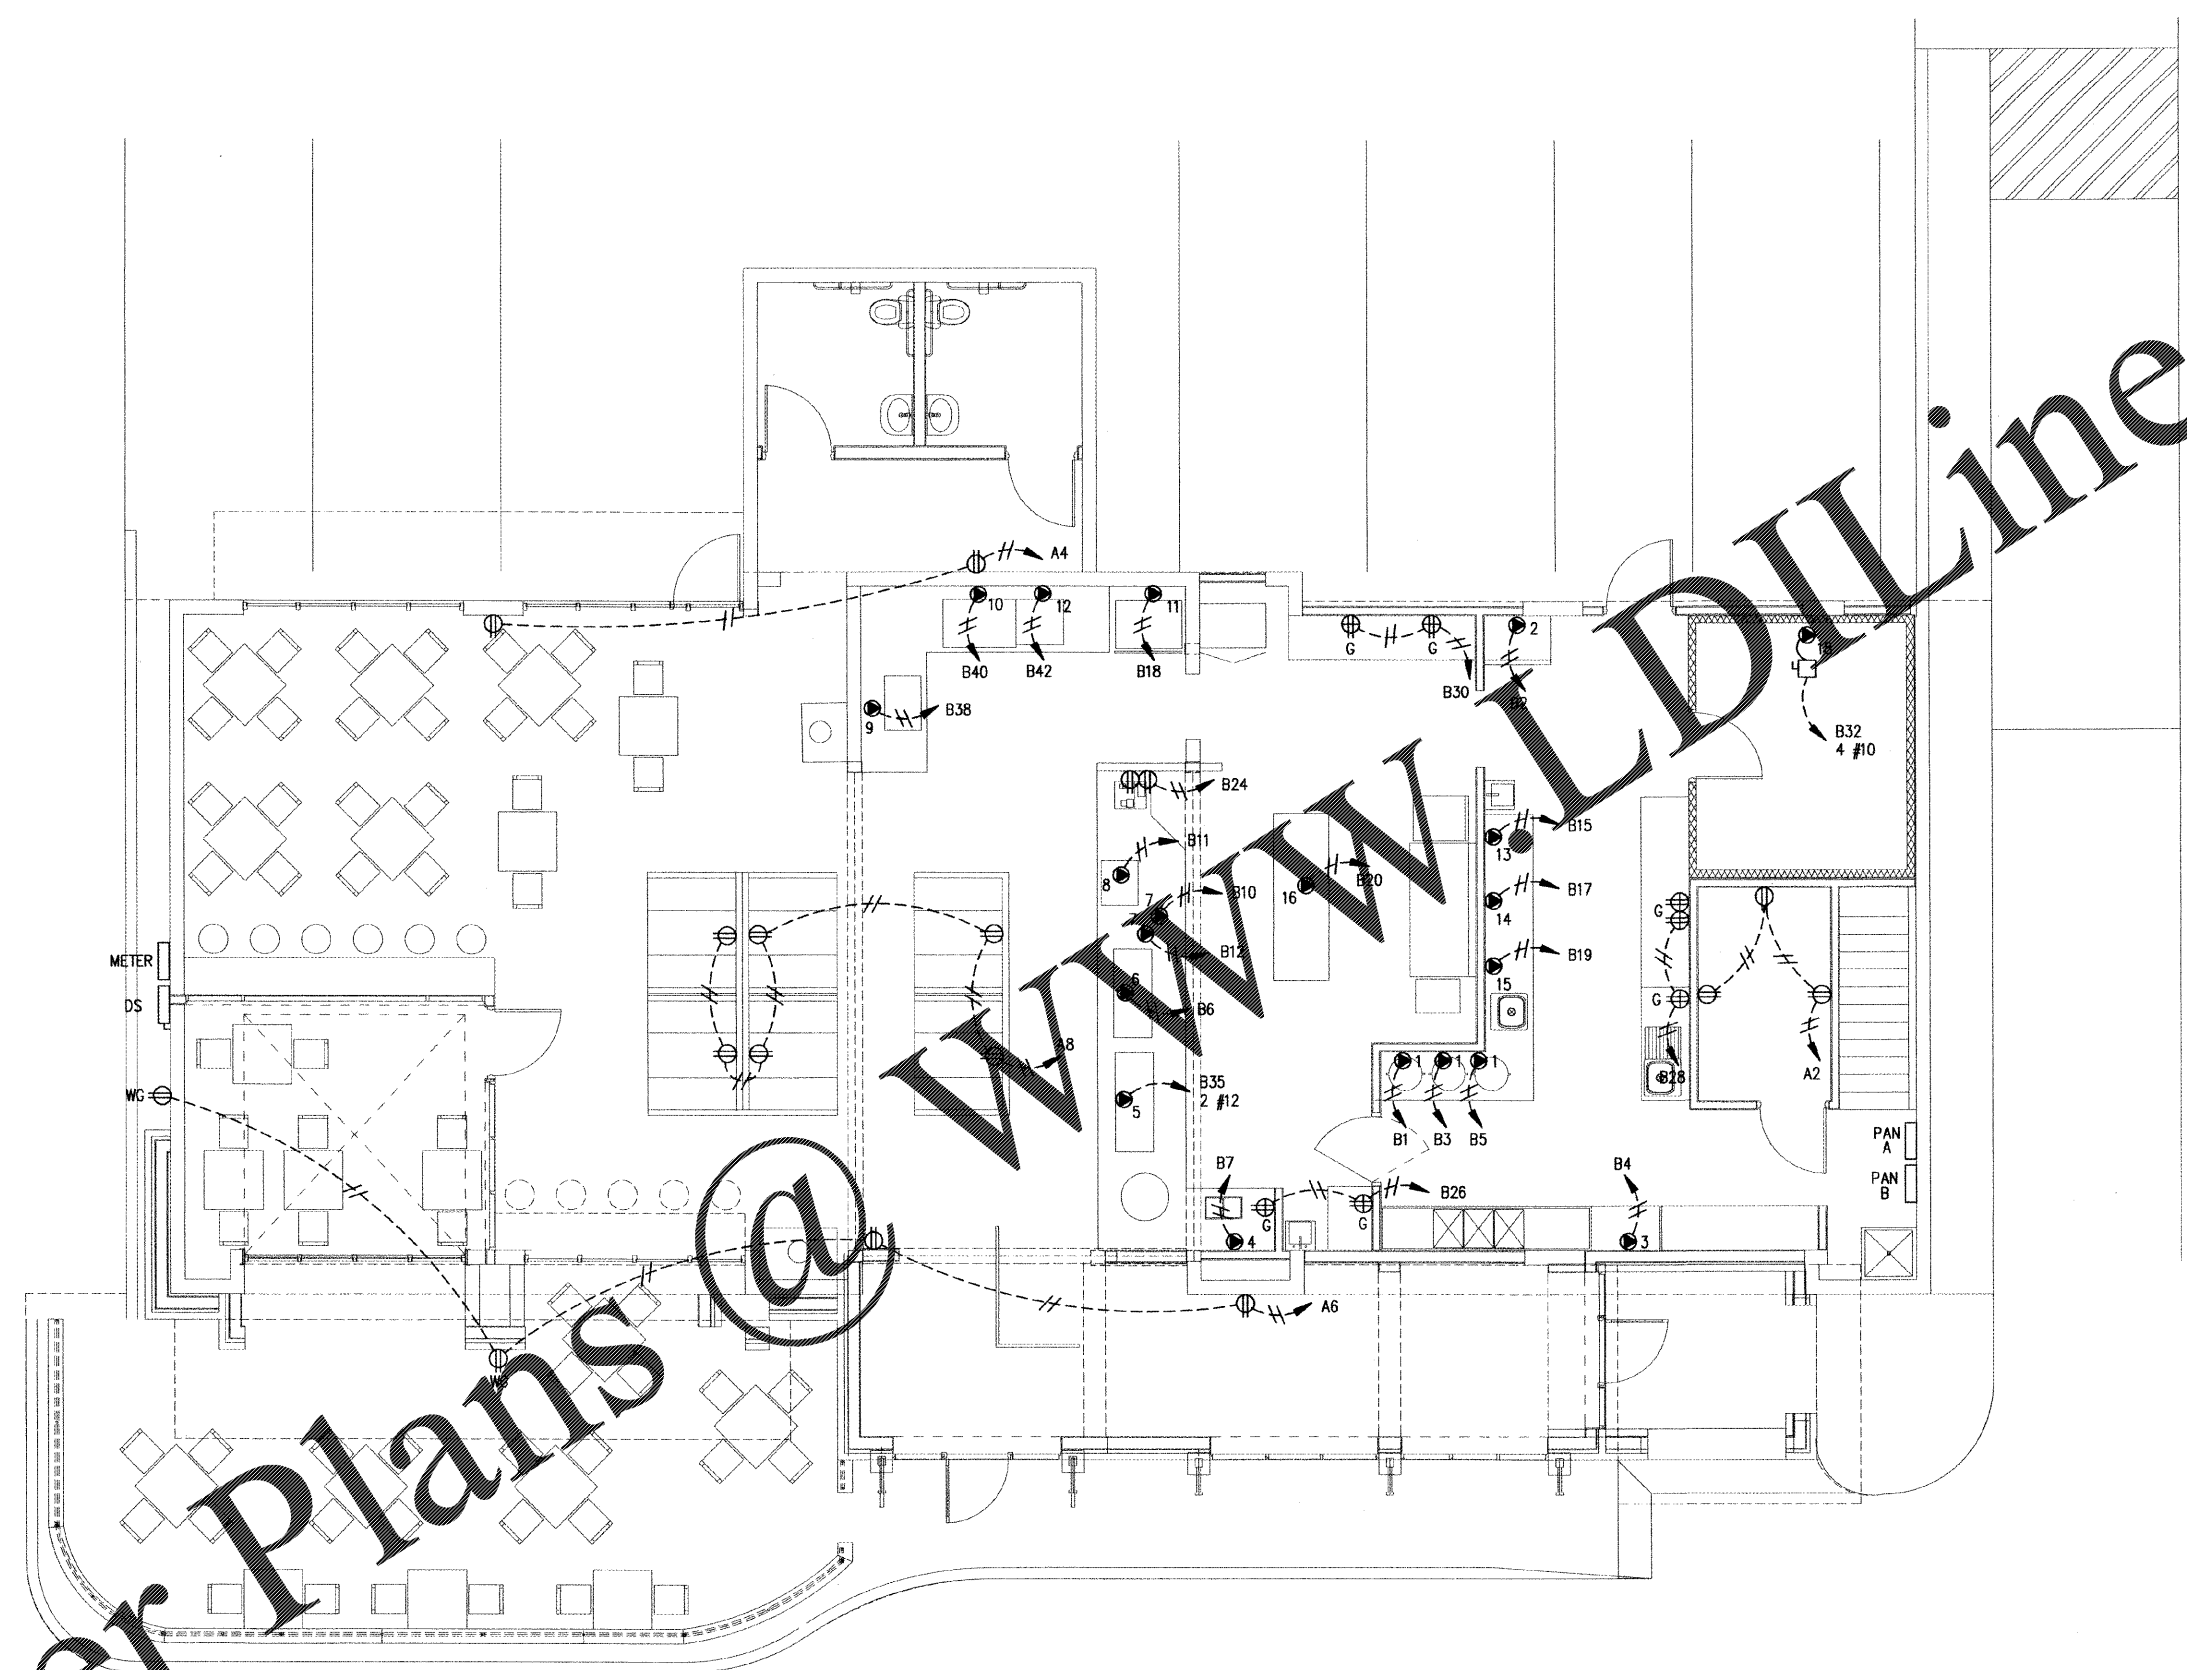

Studio
INTERIORS SPACE PLANNING
4200 BENTLEY, ALBUQUERQUE, NM 87106
703.724.4800 TEL. 703.724.4800 FAX

GEORGIA
REGISTERED PROFESSIONAL ENGINEER
NO. 10091
JOY A. DEBOLD
04/14

ALEKTROCON, LLC
PO BOX 5185
ALBUQUERQUE, GEORGIA 30017-0585
TEL: (404) 488-0720
ALEKTROCON@GMAIL.COM

DIABLOS SOUTHWESTERN GRILLE

3102 Washington Rd.
Martinez, GA 30907

Approved By: _____

2015, Copyright Bluffs Inc. These Drawings are protected by the copyright laws of the United States. These Drawings or any part thereof may not be used for any purpose or reproduced in any form or by any means without the written consent of Corporate Bluffs.

Dalco05.11.15

Print Record	11-19-15
Drawn By:	
Checked by:	
Date:	3/16/16
Revisions	
Sheet Title	
Sheet No.	E-02
Scale:	