


Order Plans @

WWW.LDLine.com

1 MECHANICAL POWER PLAN  
E-03 SCALE: 1/4" = 1'-0"

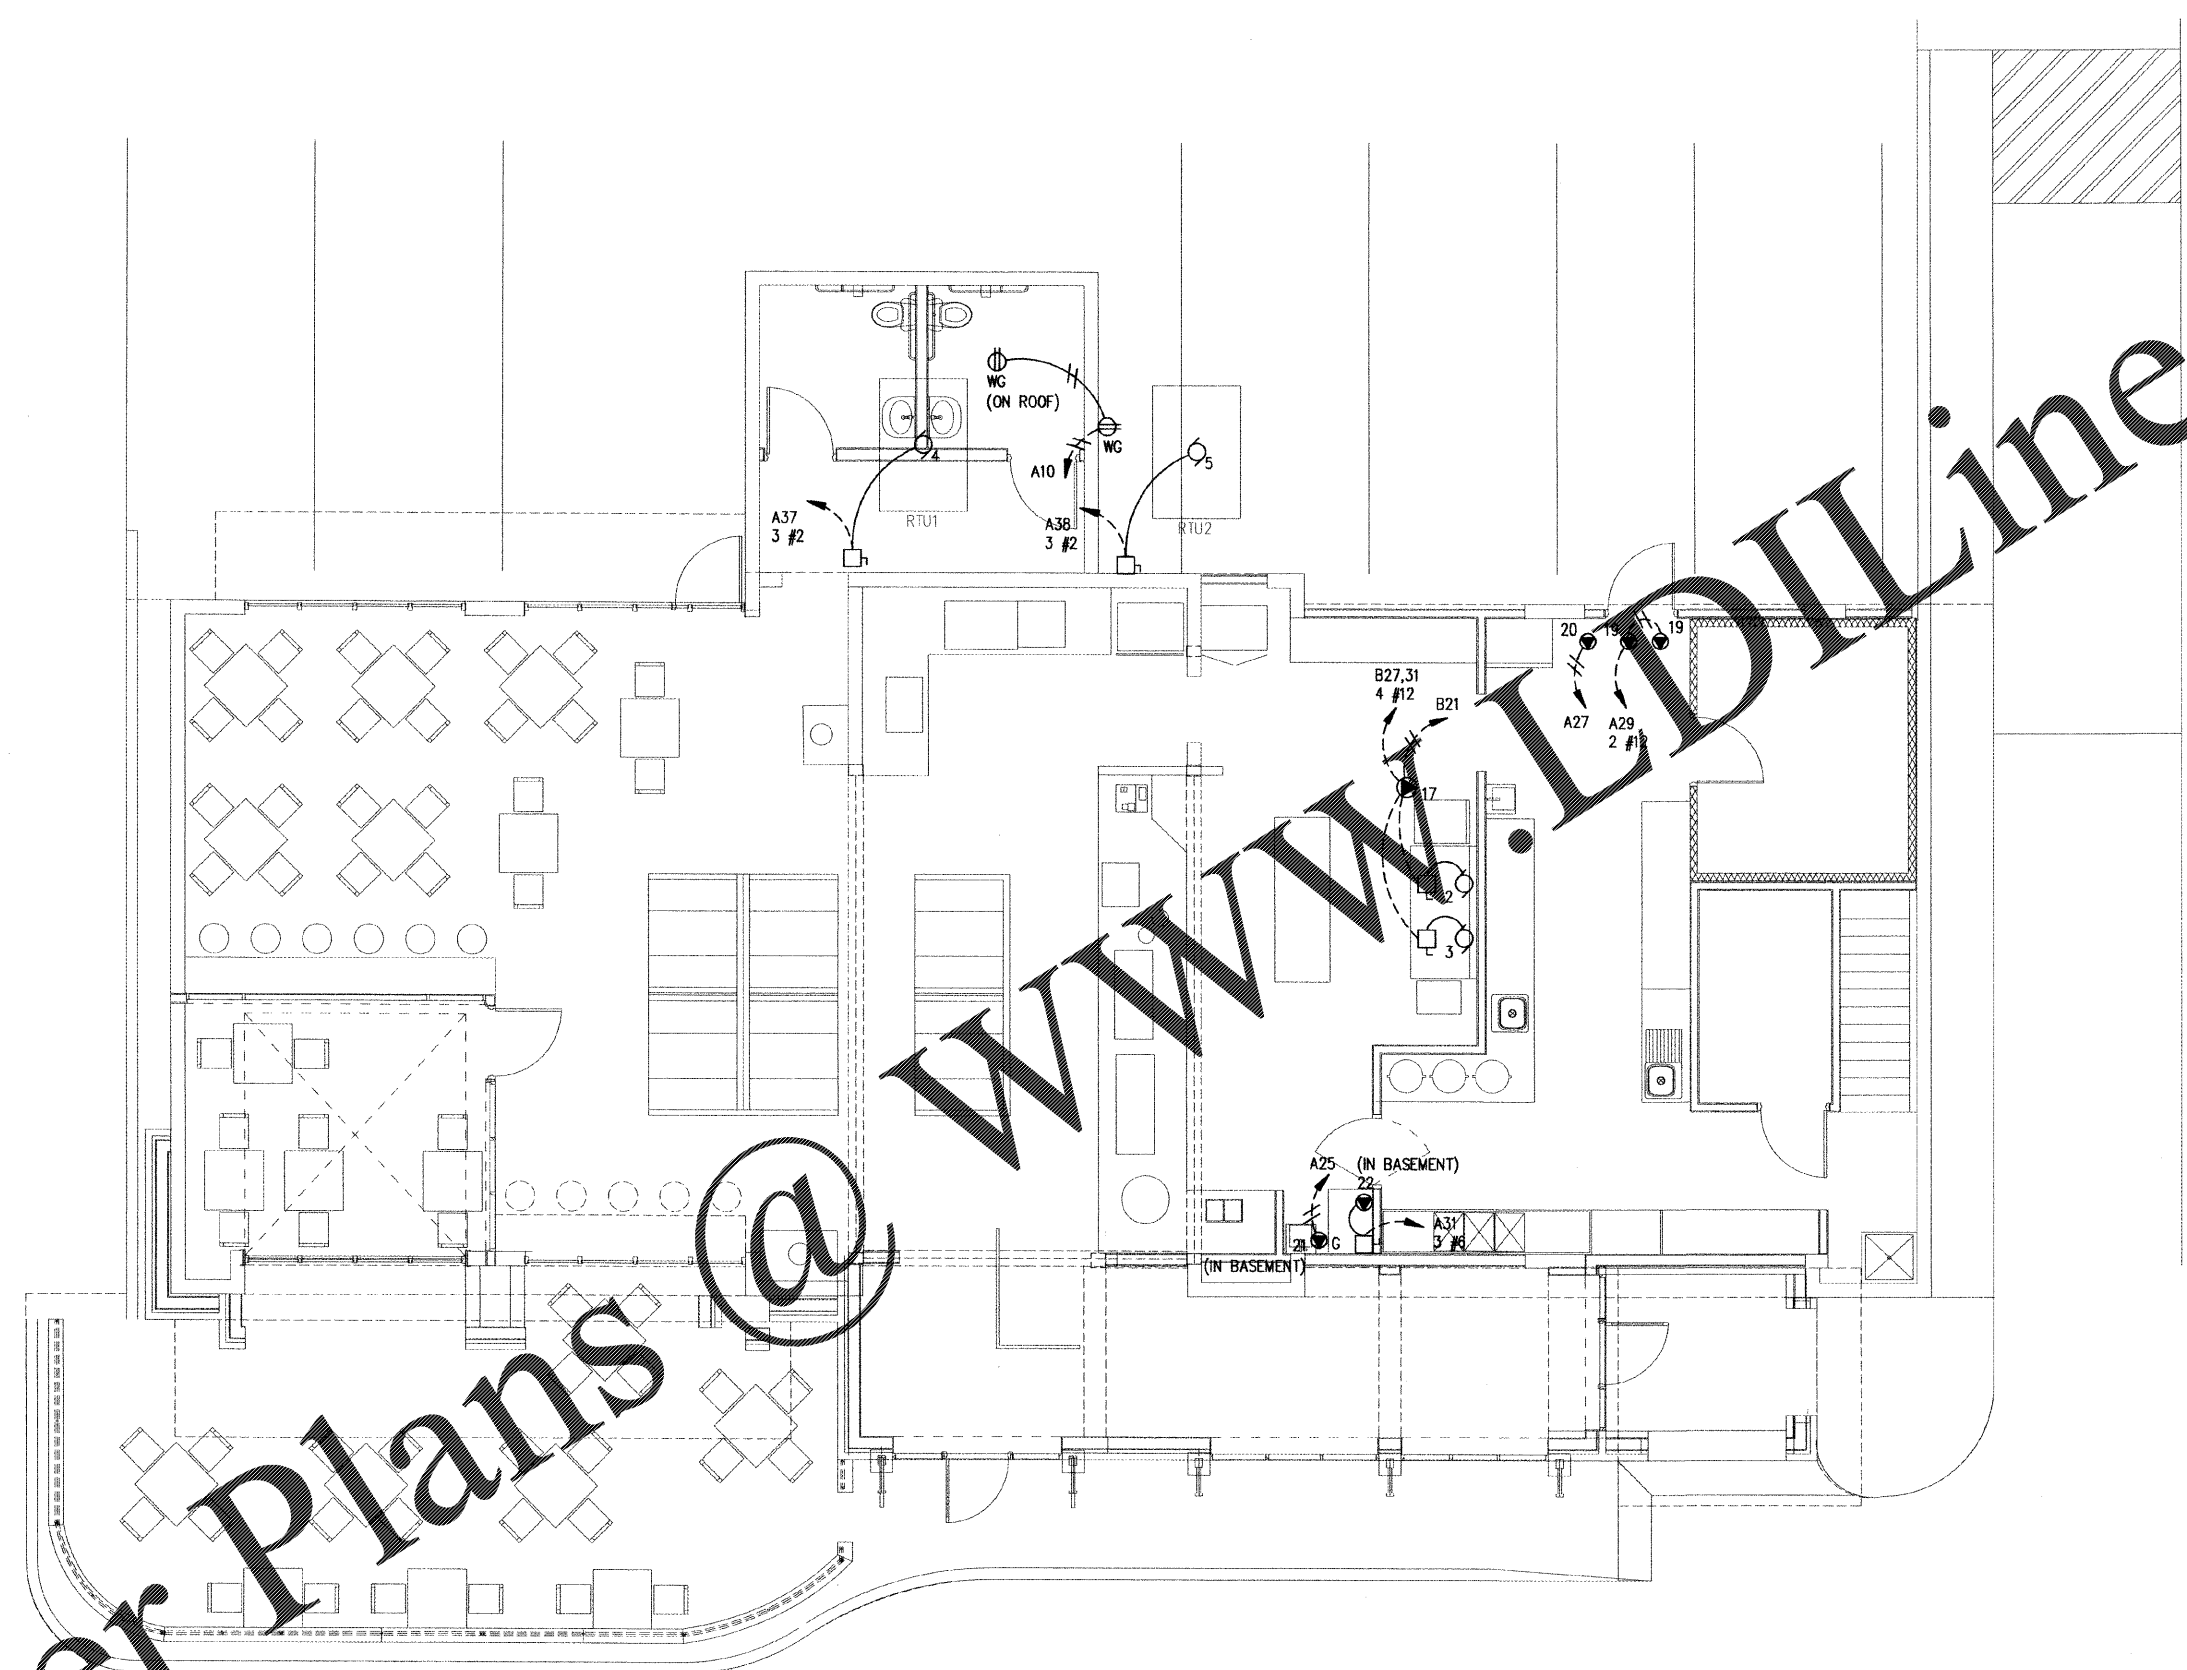

corporate  
studio  
INTERIORS SPACE PLANNING  
#20 S STREET, AUGUSTA, GA 30901  
706.724.4800 TEL 706.724.4800 FAX

GEORGIA  
REGISTERED  
NO. 10661  
PROFESSIONAL  
PLUMBING  
ROY A. DEBOLT  
04/04/14

ALEKTROCON, LLC  
PO BOX 11288  
AUGUSTA, GEORGIA 30917-0288  
TEL: (706) 884-4720  
ALEKTROCON@GOLDFLY.NET

DIABLOS SOUTHWESTERN GRILLE

3102 Washington Rd.  
Martinez, GA 30907

Approved by: \_\_\_\_\_  
Date: 03.11.15

©2015, Corporate Studio, Inc. These drawings are prepared by the copyright owner of the United States. These drawings or any part thereof may not be used for any purpose or reproduced in any form or by any means without the written consent of Corporate Studio.

Print Record	11-19-15
Drawn By:	
Checked by:	
Date:	3/16/16
Revisions	
Sheet Title	
Sheet No.	E-03
Scale:	