

15 North Arroyo North, 1st Floor, San Jose, CA 95134
 Phone: 952.944.8860 www.wilkusarch.com

EXPIRES 12-31-17

SIGNATURE
 30 August, 2017
 DATE

COPYRIGHT 2015
 THIS DRAWING IS AN INSTRUMENT OF SERVICE AND AS SUCH
 REMAINS THE PROPERTY OF CHIPOTLE MEXICAN GRILL, INC.
 PERMISSION FOR USE OF THIS DOCUMENT IS LIMITED AND
 CAN BE EXTENDED ONLY BY WRITTEN AGREEMENT WITH
 CHIPOTLE MEXICAN GRILL, INC.



CHIPOTLE MEXICAN GRILL, INC.
 1400 WYNDROP STREET, SUITE 500
 DENVER, COLORADO 80202
 TELEPHONE: (303) 595-4000
 FAX: (303) 595-4004
 INTERNET: WWW.CHIPOTLE.COM

STORE NO.: 3007
 Purcellville
 1200 Wolf Rock Drive, Suite 130
 Purcellville, VA 20132

Issue Record
 12-15-16 Permit Set


Revisions
 03-06-17 OWNER COMMENTS
 08-23-17 CHIPOTLE COMMENTS

Drawn: D. Austin
 Checked: M. Wilkus


Project No.
 2016-0424

Contents
 Slab Work plan

A110

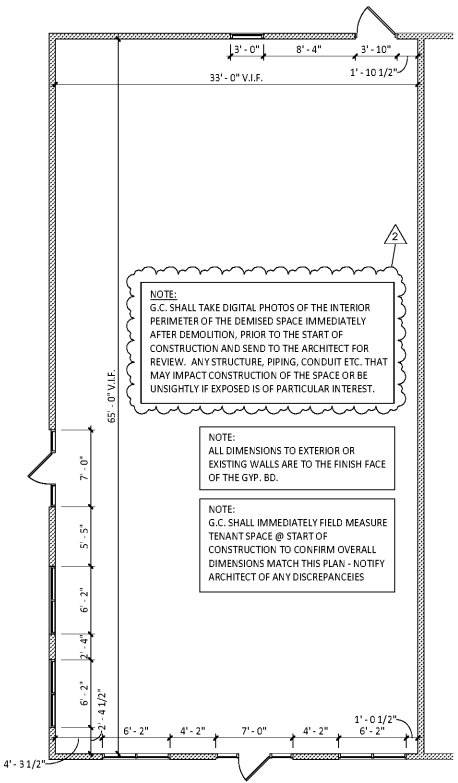

3
 A110
 DEMISED PREMISES PLAN
 1/8" = 1'-0"

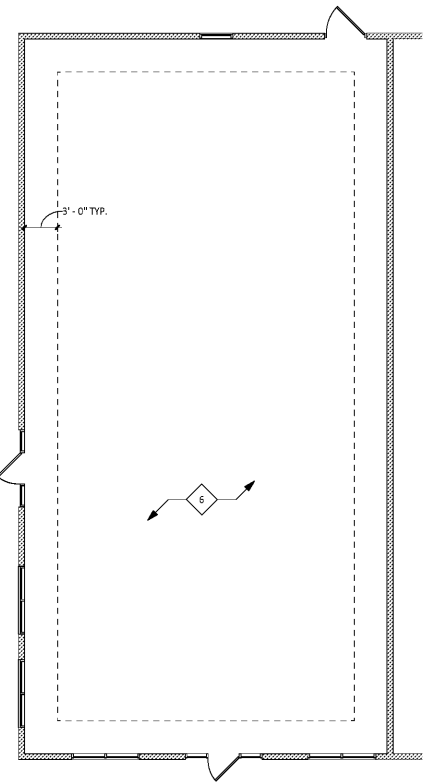

2
 A110
 DEMOLITION PLAN
 1/8" = 1'-0"

GENERAL NOTES


- ALL DIMENSIONS ARE FROM FACE OF WALL TO CENTERLINE OF FIXTURE, U.N.O. REFER TO SPEC. FOR CONCRETE PATCHING REFER TO SPEC. FOR WATERPROOFING MEMBRANE DETAILS

SLAB WORK PLAN KEYNOTES

- SLOPE FLOOR IN THIS AREA ONLY TO DRAIN 1/40
- 4" CONCRETE CURB WITH #4 W1.4/1.4 W.W.F. - ROUGHEN EXISTING SLAB ON GRADE OR USE SIKADUR 32 LPL EPOXY BONDING AGENT BELOW CURB - COORD. EXACT LOCATION WITH FINAL EQUIP. LOCATION
- 4" CONCRETE CURB WITH #4 W1.4/1.4 W.W.F. FINISH CORNER WITH 1/2" CHAMFER OR ROUNDED EDGE. ROUGHEN EXISTING SLAB ON GRADE OR USE SIKADUR 32 LPL EPOXY BONDING AGENT BELOW CURB - COORD. EXACT LOCATION WITH FINAL EQUIP. LOCATION
- 4" PVC PIPE WITH 2" HIGH CONCRETE INFILL FOR POWER STUB. TYP. OF TWO (2). REFER TO ELECTRICAL DRAWINGS AND 2/A125
- 5" X 5" POWER STUB LOCATION, COORDINATE WITH ELECTRICAL PLAN
- NEW CONCRETE SLAB-ON-GRADE TO MATCH EXISTING - PROVIDE JOINTS IN SLAB TO MATCH EXISTING LOCATIONS - REFER TO SPECIFICATIONS AND STRUCTURAL DRAWINGS FOR ADDITIONAL INFORMATION
- 6" PVC PIPE FOR SYRUP LINES, REFER TO PLUMBING PLAN - COORDINATE SYRUP LINE ROUTING WITH EXISTING UNDER SLAB CONDITIONS
- OUTLINE OF MOP SINK


NOTE:
 ALL DIMENSIONS TO EXTERIOR OR EXISTING WALLS ARE TO THE FINISH FACE OF THE G.V.P. BD.

NOTE:
 G.C. SHALL REVIEW RESPONSIBILITY MATRIX ON SHEET A001 PRIOR TO CONSTRUCTION

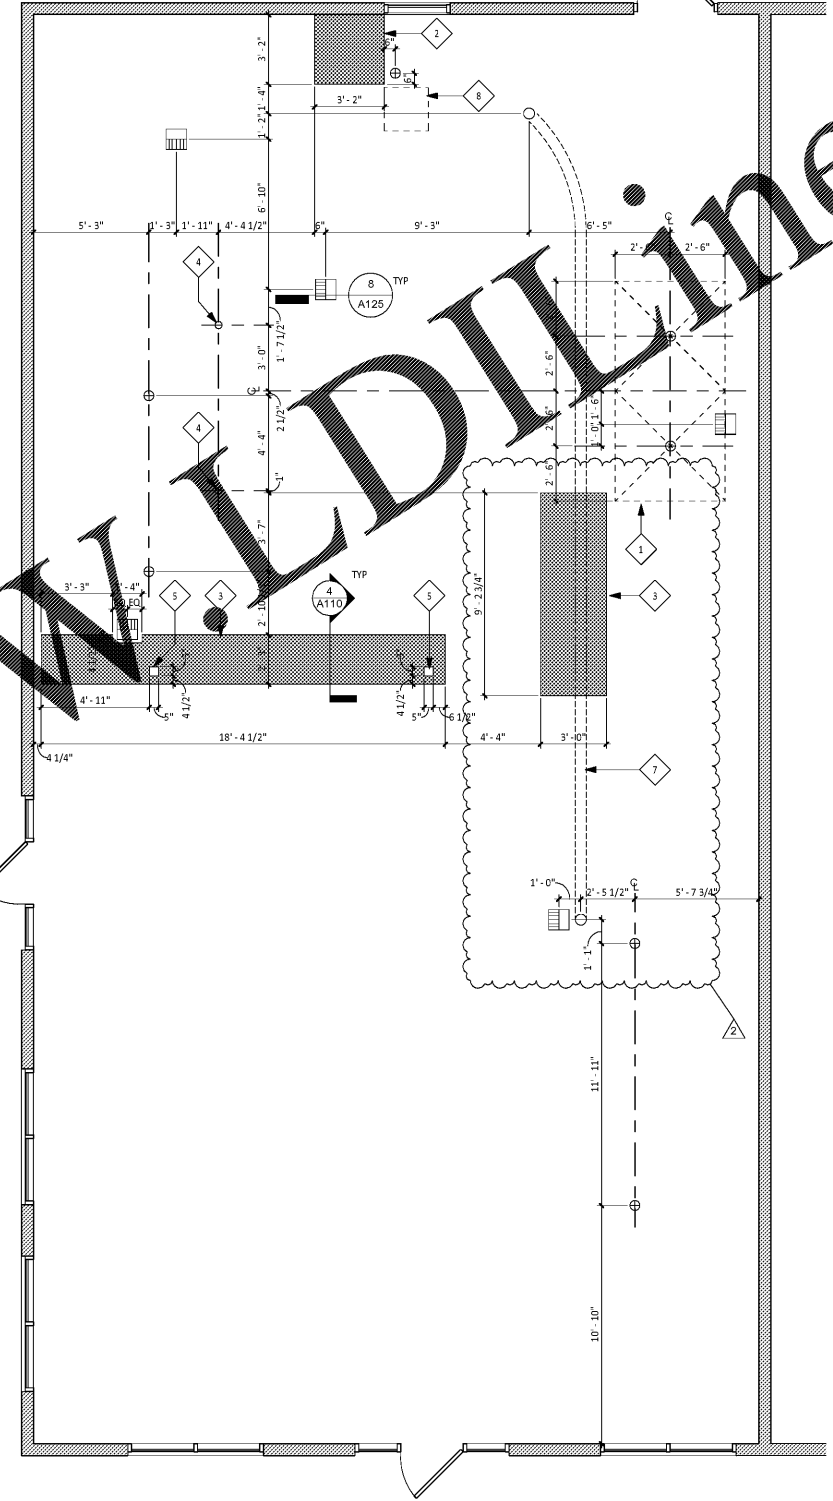

1
 A110
 SLAB WORK PLAN
 1/4" = 1'-0"

Order Plans @ WWW.LDLINE.COM

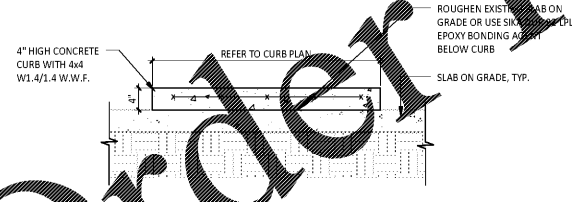

4
 A110
 CONCRETE CURB DETAIL
 3/4" = 1'-0"