

INT. DINING ELEVATION KEYNOTES

- 1 STAINLESS STEEL EXHAUST HOOD WITH WRAPPER PANEL ABOVE - REFER TO MECH. DWGS.
- 2 NOT USED
- 3 EXISTING ROOF STRUCTURE TO REMAIN
- 4 PLYWOOD SLAT WALL (REFER TO DETAILS FOR ADDITIONAL INFORMATION)
- 5 PAINT TRANSITION LINE - REFER TO SPECS.

ELEVATION SCHEDULE

NOTE: G.C. SHALL REVIEW RESPONSIBILITY MATRIX ON SHEET A001 PRIOR TO CONSTRUCTION

WALL BASE FINISHES		WALL FINISHES	
LGD. #		LGD. #	
B1	BLACK RUBBER, COVELESS	P1	NOT USED
B2	QUARRY TILE	P2	FIBERGLASS REINFORCED PANELS (SMOOTH FINISH)
B3	BLACK RUBBER, COVE	P3	GYP BD; PAINT "THIN ICE", SATIN FINISH ABOVE 5'-0" AFF
		P4	GYP BD; PAINT "THIN ICE", SEMI-GLOSS BELOW 5'-0" AFF
		P5	CERAMIC TILE
		P6	FIBERGLASS REINFORCED PANELS (PEBBLED FINISH)
		P7	DIAMOND PLATE TO 48" AFF
		P8	GYP BD; PAINT "AUTUMN RIDGE" BEHIND SLAT WALL ONLY
		P9	WOOD SLAT WALL SYSTEM
		P10	NOT USED

GENERAL NOTES

- REFER TO SHEET A131 FOR EQUIPMENT LIST AND FURNITURE SCHEDULE.
- REFER TO A120 FOR FINISH SCHEDULE.
- REFER TO A140 AND ELECTRICAL DRAWINGS FOR LIGHT FIXTURE SCHEDULE.



15 North Arroyo North, 1st Floor, SAN JOSE, CA 95131
 Phone: 952.944.8965 www.wilkusarch.com

EXPIRES 12-31-17
 SIGNATURE
 30 August, 2017
 DATE

COPYRIGHT 2017
 THIS DRAWING IS AN INSTRUMENT OF SERVICE AND AS SUCH
 REMAINS THE PROPERTY OF CHIPOTLE MEXICAN GRILL, INC.
 PERMISSION FOR USE OF THIS DOCUMENT IS LIMITED AND
 CAN BE EXTENDED ONLY BY WRITTEN AGREEMENT WITH
 CHIPOTLE MEXICAN GRILL, INC.



CHIPOTLE MEXICAN GRILL, INC.
 1400 WYNDGROVE STREET, SUITE 500
 DENVER, COLORADO 80202
 TELEPHONE: (303) 595-4000
 FAX: (303) 595-4004
 INTERNET: WWW.CHIPOTLE.COM

STORE NO.: 3007
 Purcellville
 1200 Wolf Rock Drive, Suite 130
 Purcellville, VA 20132

Issue Record:
 12-15-16 Permit Set


Revisions:
 03-06-17 OWNER COMMENTS
 08-23-17 CHIPOTLE COMMENTS

Drawn: D. Austin
 Checked: M. Wilkus


Project No.
 2016-0424

Contents:
 Elevations Interior Dining


A210

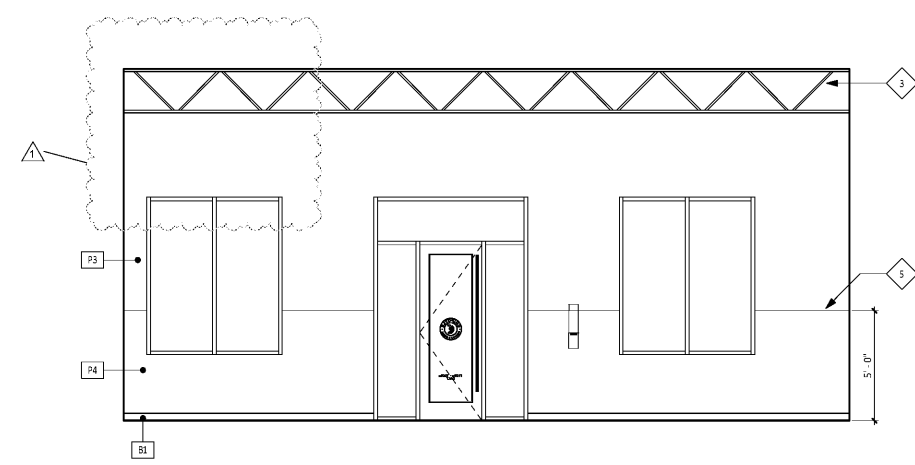


1 MAIN ENTRY ELEVATION
 1/4" = 1'-0"

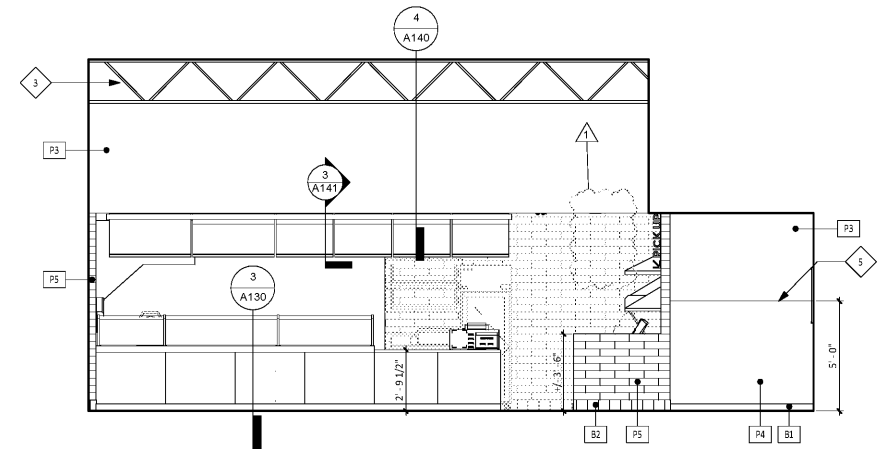

2 ORDERING ELEVATION
 1/4" = 1'-0"

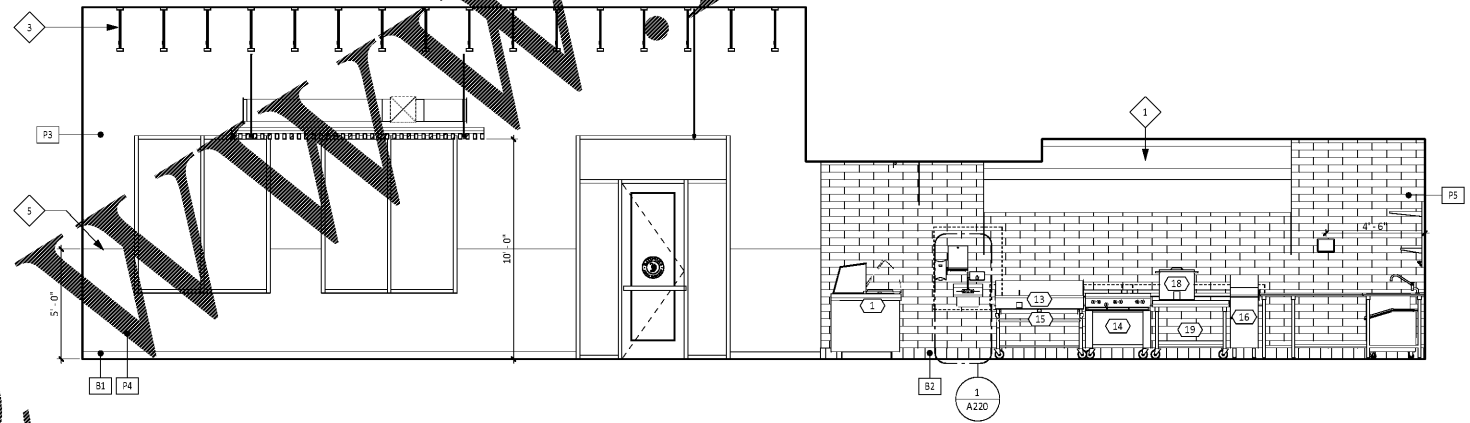

3 DINING / ORDERING / COOKING ELEVATION
 1/4" = 1'-0"

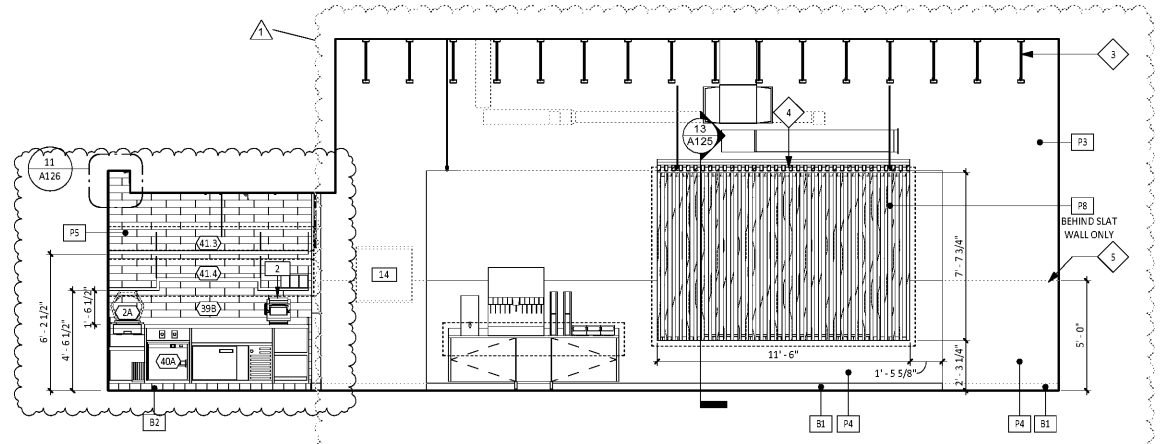

4 DINING ELEVATION
 1/4" = 1'-0"

Order Plans @