


30\_AUG\_2017 3:00 PM [BY: mgr/ffr] [PLOTED] [PROJECTSERVER\DATA\PROJECTS\1904\_FBC\_HOYDEN\1904-SD\_A020-A120 Phase One.dwg] 30 AUG 2017 3:00 PM [BY: mgr/ffr] [PLOTED]

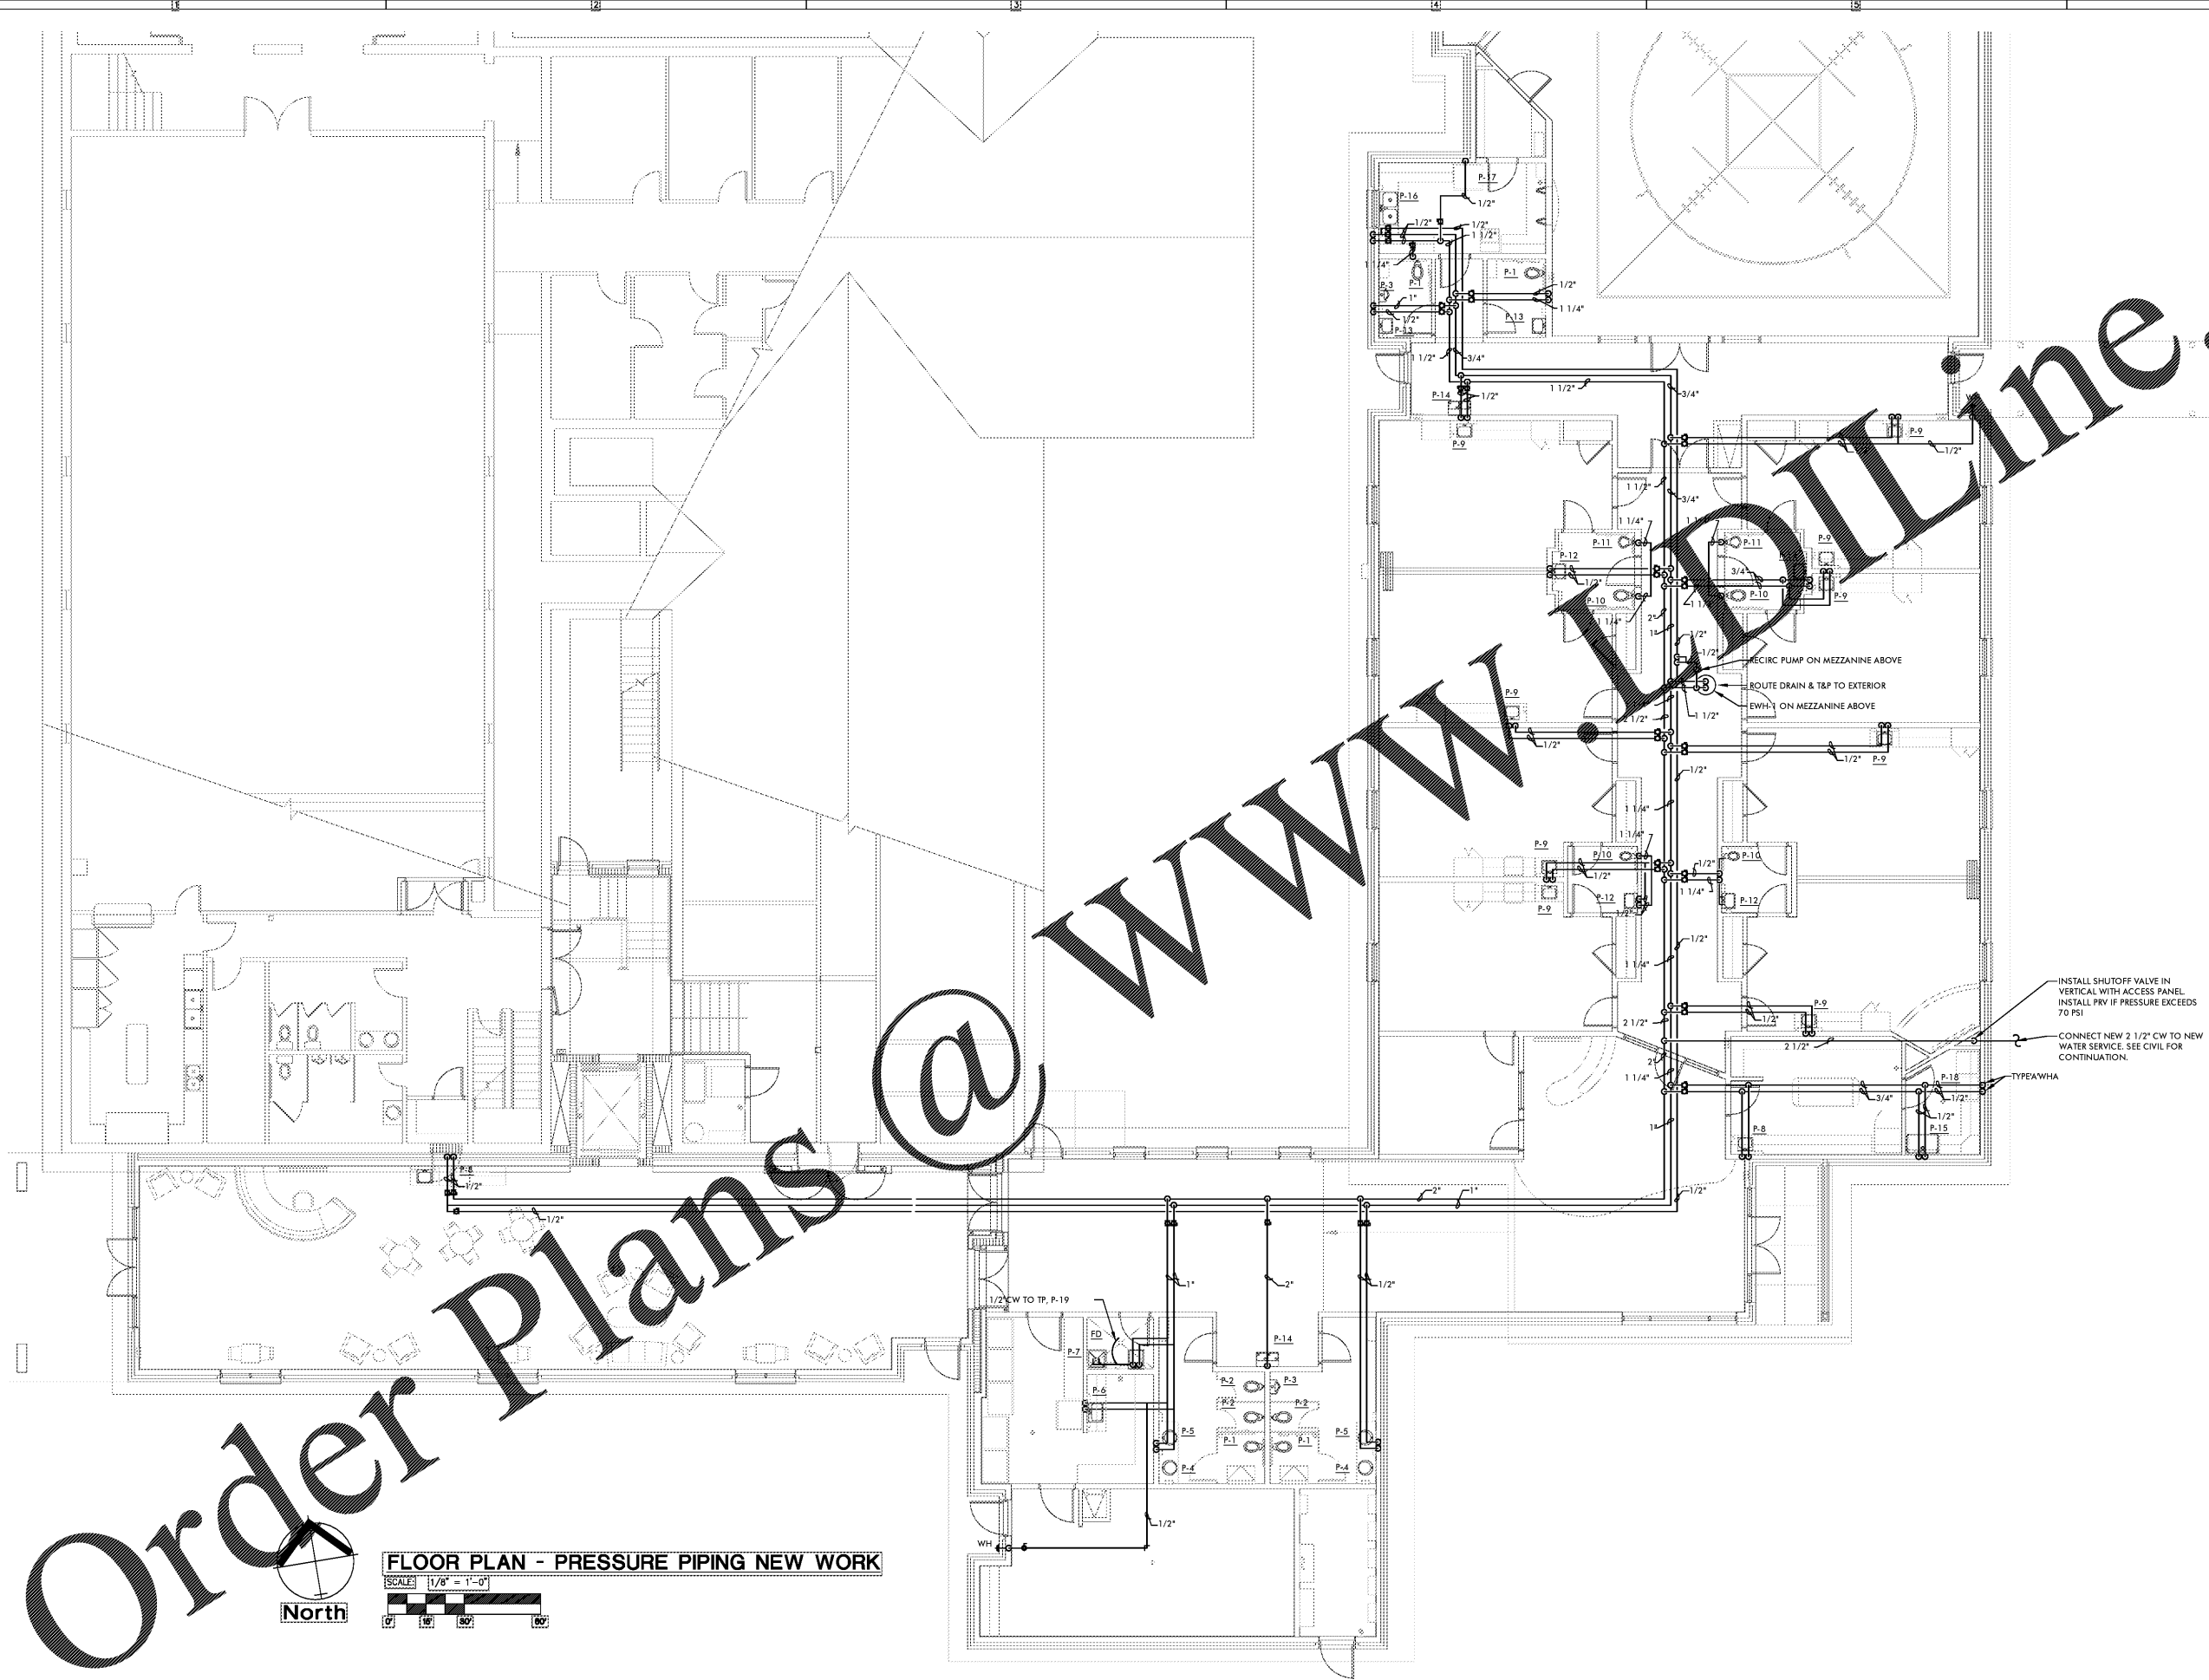

Order Plans @

**FLOOR PLAN - PRESSURE PIPING NEW WORK**  
SCALE: 1/8" = 1'-0"  
0' 10' 20' 30'



**WR**  
WHITAKER & RAWSON, LLC  
3332 Old Montgomery Hwy  
Suite 103 Mark Harris Bldg  
Birmingham, AL 35209  
www.whitakerandrawson.com  
Mechanical: Doug Rawson  
Direct Line: (205) 949-5118  
Plumbing: Erik Harwig  
Direct Line: (205) 949-5107  
W&R PROJECT NUMBER: 17180

**Corley Timothy Sweeney McCormac**  
C T S M A R C H I T E C T S I N C.  
THREE RIVERCHASE OFFICE PLAZA / SUITE 124 / HOOVER, ALABAMA 35244  
T 205-443-3720 F 205-443-3720 W ctsmarchitects.com

FLOOR PLAN  
PRESSURE PIPING NEW WORK  
01-08-17  
1904-030  
ALABAMA

FIRST BAPTIST CHURCH  
HAYDEN, ALABAMA  
REVISED:  
P300