


Order Plans

AL HIGHWAY 160

CITY
BUILDING

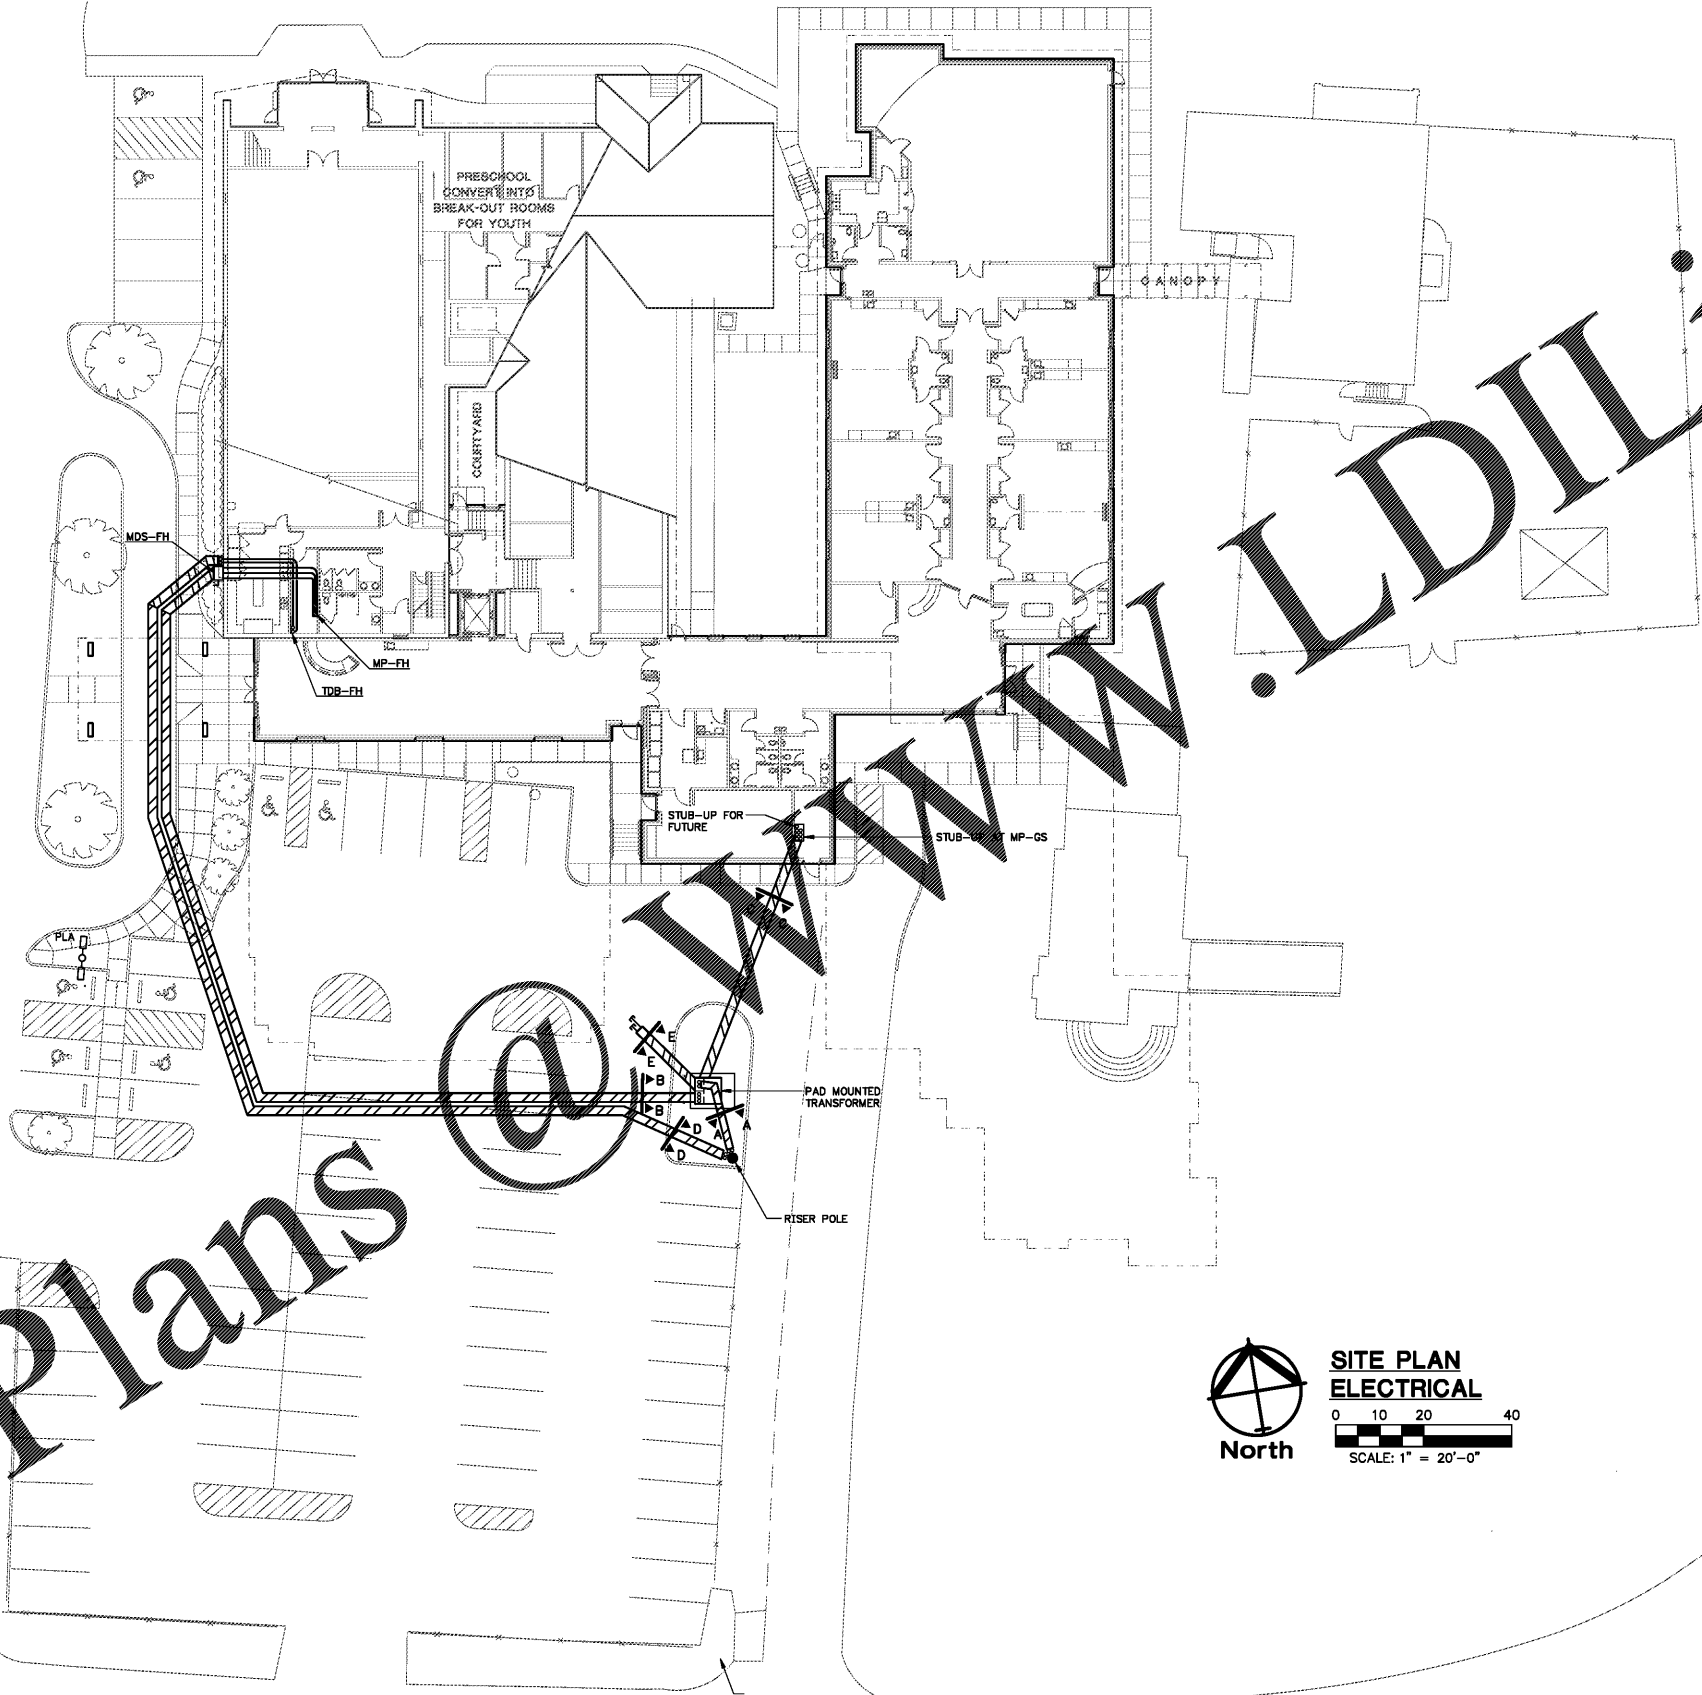

**SITE PLAN
ELECTRICAL**
0 10 20 40
SCALE: 1" = 20'-0"

SEI
Staub Engineering, Inc.
2524 Valleydale Road
Birmingham, Alabama 35244
Ph: 205.981-1900 Fax: 205.981-0500
Email: staub@seieing.com



Corley Timothy Sweeney McCormac
C T S M A R C H I T E C T S I N C.
THREE RIVERCHASE OFFICE PLAZA / SUITE 124 / HOOVER, ALABAMA 35244
T 205.443.3720 F 205.443.3720 W ctsmarchitects.com

**SITE PLAN
ELECTRICAL**

08-30-17
ALABAMA
1904

**FIRST BAPTIST CHURCH
CHILDREN'S ADDITION
HAYDEN,**

REVISED: