


DATE PLOTTED: SEPTEMBER 21, 2017 PLOTTED BY: STEVE AT 10:16
 © COPYRIGHT LAWRENCE L. CORLEY, THESE DRAWINGS / FILES, AS INSTRUMENTS OF SERVICE, ARE, AND SHALL REMAIN THE SOLE PROPERTY OF THE ARCHITECT. THEY ARE NOT TO BE REPRODUCED IN ANY FORM WITHOUT WRITTEN CONSENT OF THE ARCHITECT.


1708B21A.DWG, 09-21-17 AT 10:16 - STEVE
 SCALE: 1/8" = 1'-0"

1708B21A.DWG, 09-08-17 AT 09:09 - STEVE
 SHEET SIZE: 24.0x36.0
 SCALE: 1/8" = 1'-0"

Order Plans

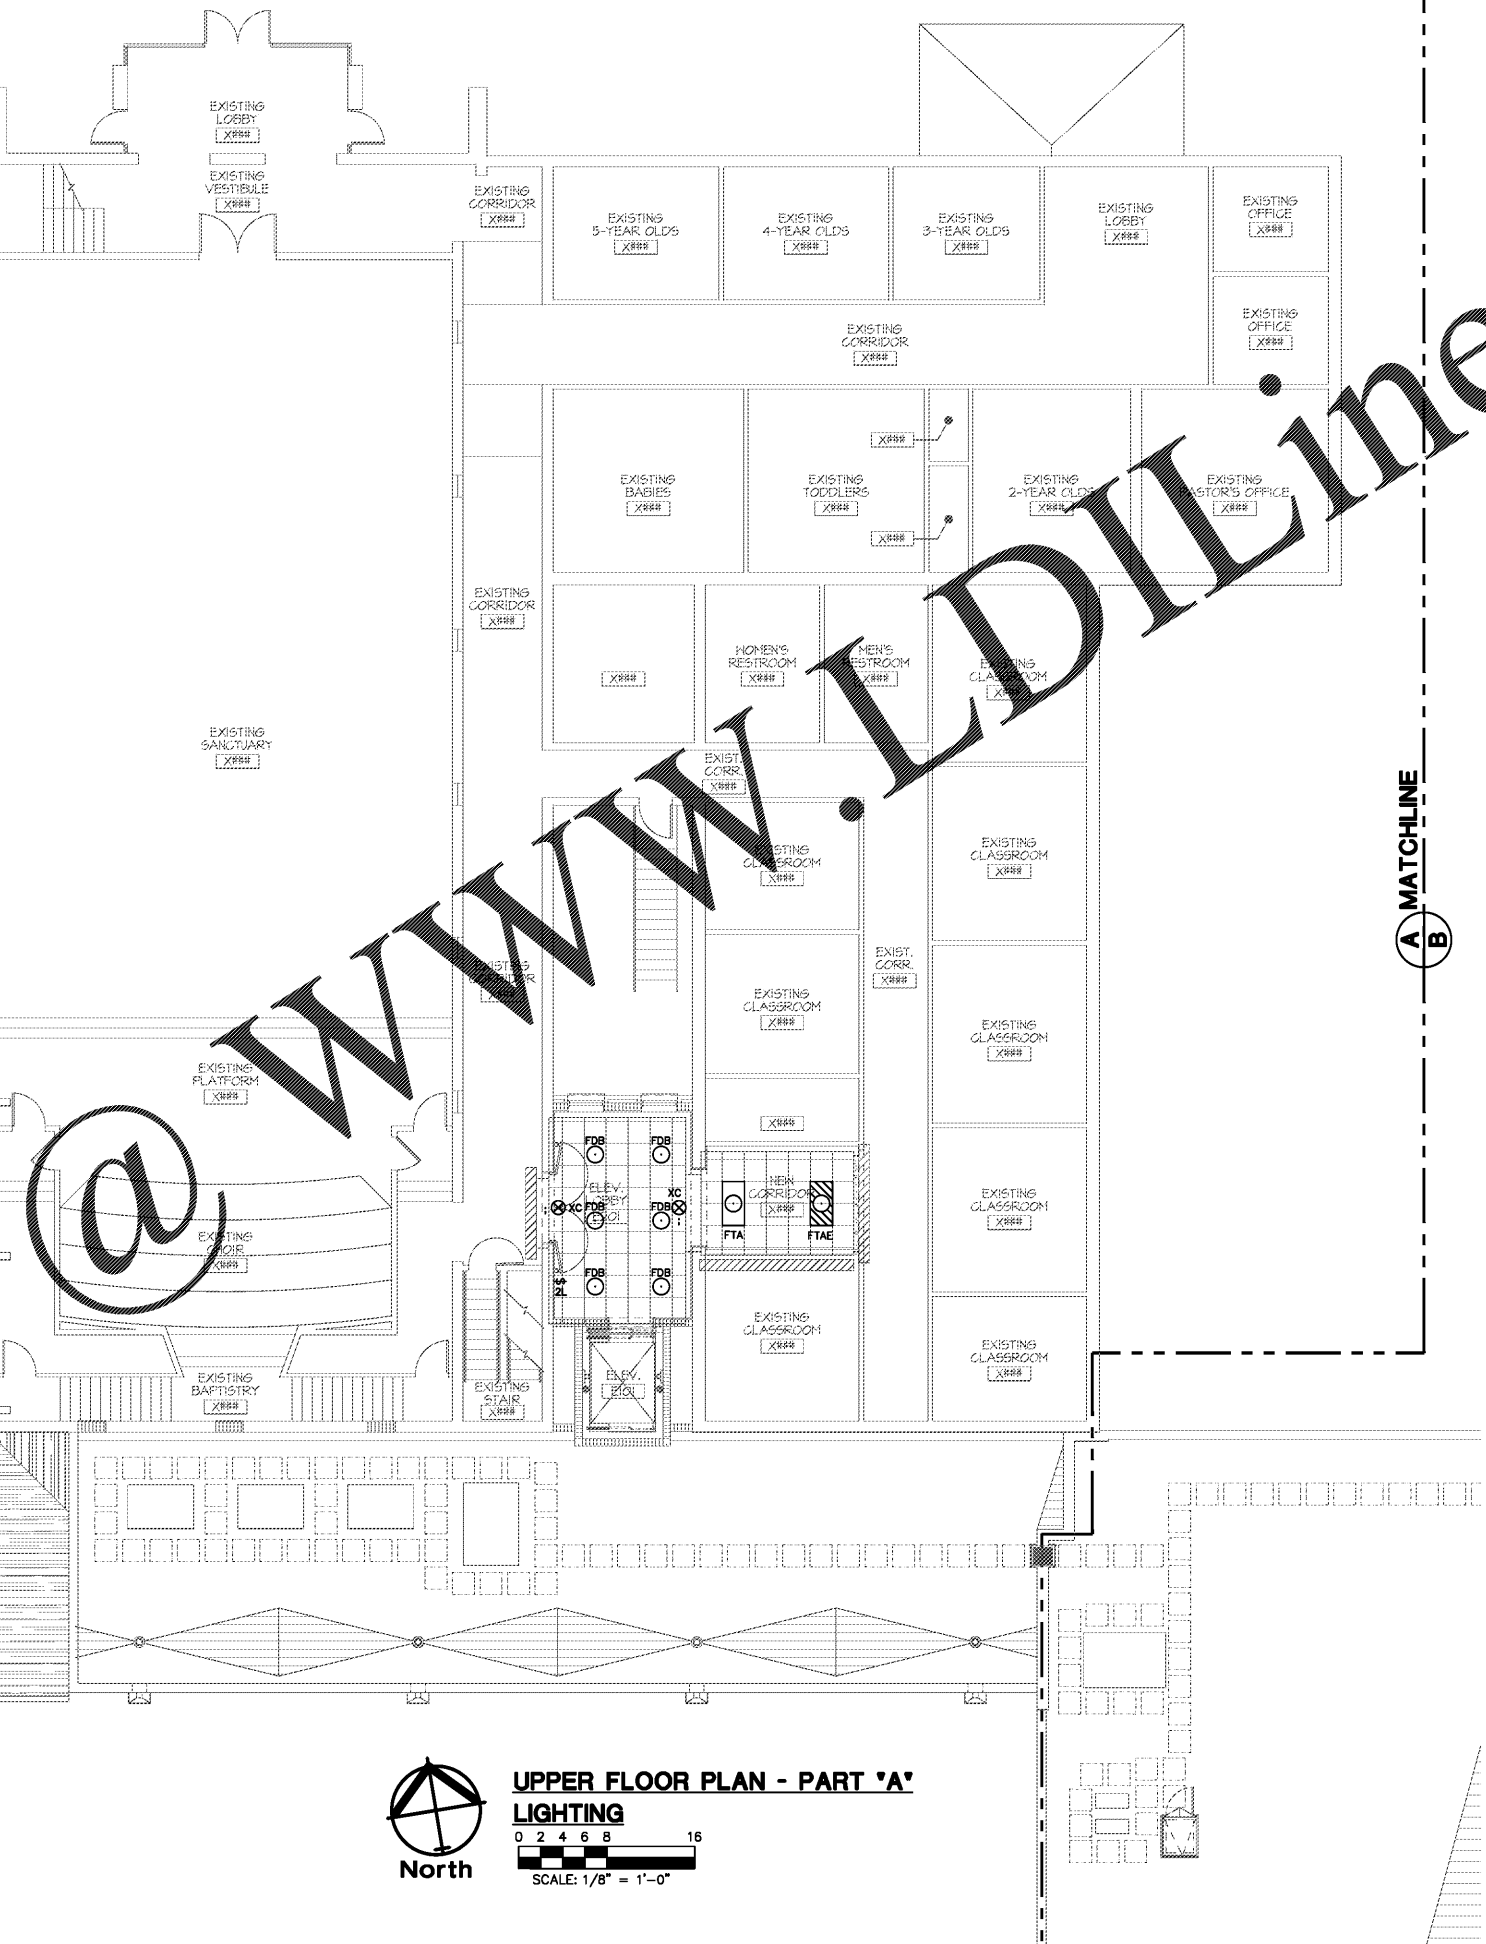

UPPER FLOOR PLAN - PART 'A'
LIGHTING
 0 2 4 6 8 16
 SCALE: 1/8" = 1'-0"

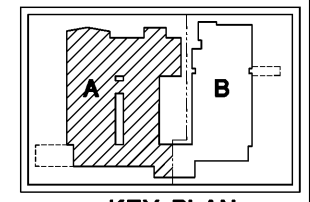

KEY PLAN

SET
 Staub Engineering Inc.
 2524 Valleydale Road,
 Birmingham, Alabama 35244
 Ph: 205.981-8100 Fax: 205.981-8597
 Email: staub@staubeng.com



Corley Timothy Sweeney McCormac
 C T S M A R C H I T E C T S I N C
 THREE RIVERCHASE OFFICE PLAZA / SUITE 124 / HOOPER, ALABAMA 35244
 T 205.443.3720 W csmarchitects.com

UPPER FLOOR PLAN
 PART "A"
 LIGHTING

08-30-17
 ALABAMA
 1904

FIRST BAPTIST CHURCH
 CHILDREN'S ADDITION
 HAYDEN,

REVISED:
 E121A