


**COOK OUT**  
 155 Tom Hill Sr. Blvd  
 Macon GA 31210

PK	DATE	DESCRIPTION	REVISIONS

**REFLECTED CEILING PLAN**

DATE 09-01-2011  
 DRAWN BY DNE  
 CHECK BY RML  
 JOB NO. 17-001-000  
 SHEET

**A1.2**

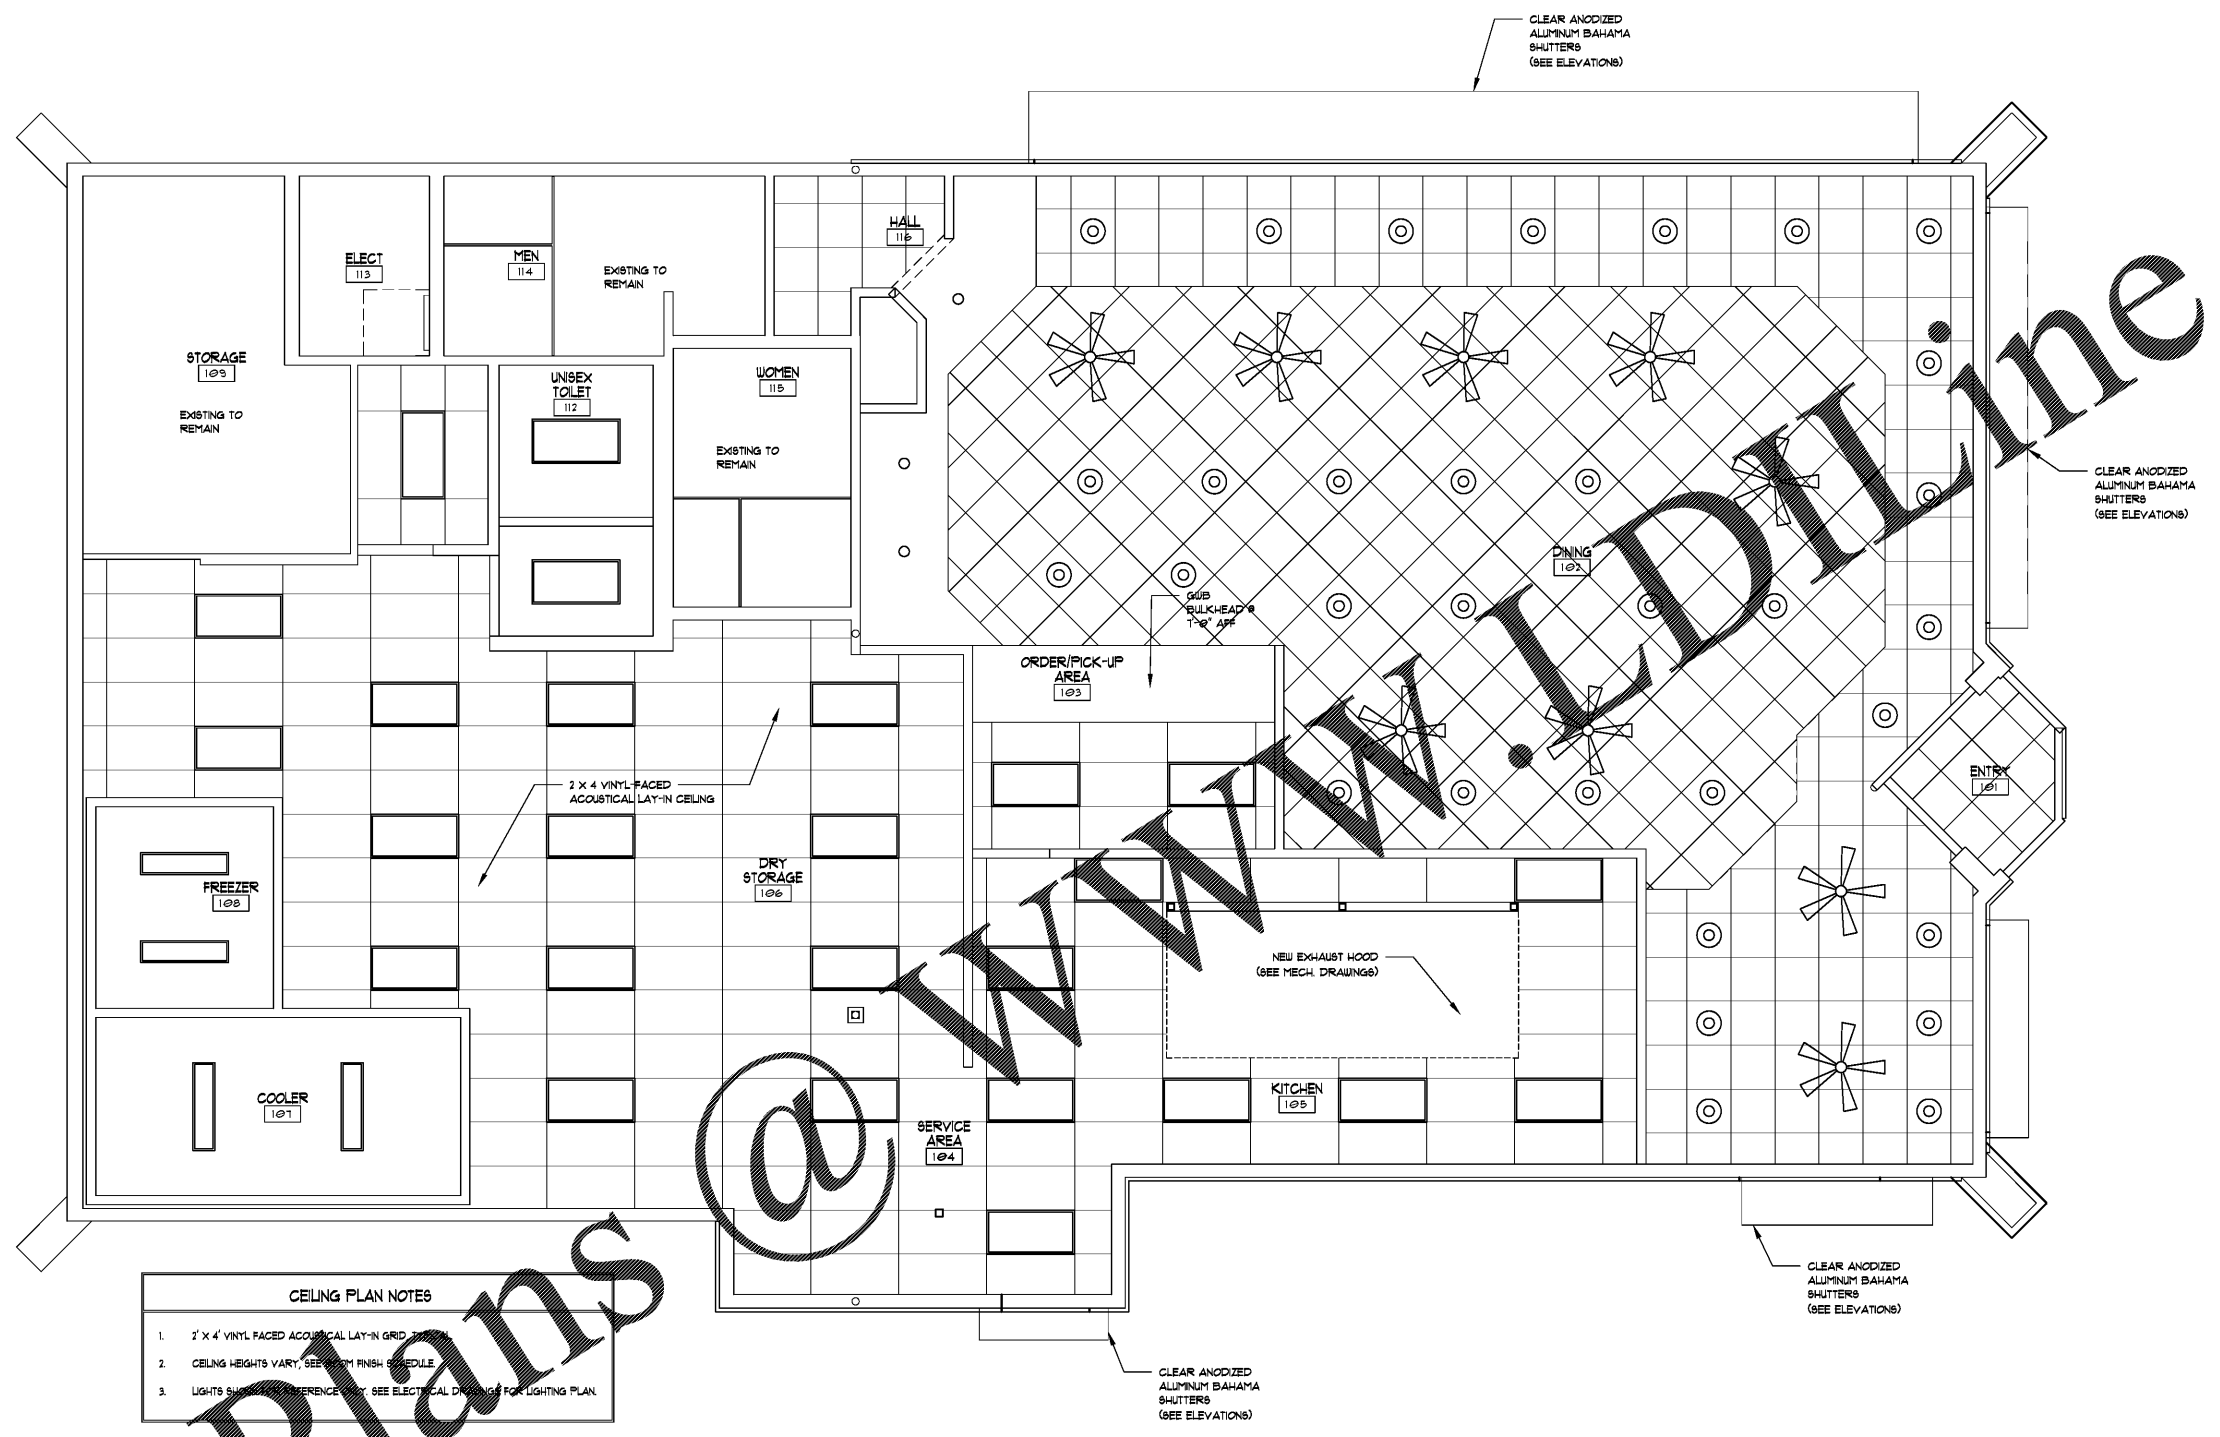

- CEILING PLAN NOTES**
- 2' X 4' VINYL FACED ACOUSTICAL LAY-IN GRID
  - CEILING HEIGHTS VARY, SEE FINISH SCHEDULE
  - LIGHTS SHOWN FOR REFERENCE ONLY. SEE ELECTRICAL DRAWING FOR LIGHTING PLAN.

**1 REFLECTED CEILING PLAN**  
 A1.2 SCALE: 1/4"=1'-0"

Order Plans @ WWW.LINDESEYARCHITECTURE.COM