


ALL DESIGNS, DRAWINGS AND SPECIFICATIONS DEPICTED ON THIS SHEET ARE THE PROPERTY OF R V ARCHITECTURE, P.A. ANY UNAUTHORIZED USE OR REPRODUCTION IS SUBJECT TO LEGAL PROSECUTION. POSSESSION IN ANY FORM CONSTITUTES ACCEPTANCE OF THESE CONDITIONS. COPYRIGHT 2017

- GAS PIPING NOTES:**
1. WORK TO INCLUDE PIPING FROM GAS METER TO ALL GAS FIRED EQUIPMENT. FINAL CONNECTION TO ROOFTOP UNITS BY MECHANICAL CONTRACTOR. MECHANICAL CONTRACTOR TO PROVIDE SHUT-OFF VALVE, DIRT TRAP, AND PRESSURE REGULATOR AT EACH PIECE OF EQUIPMENT.
 2. ALL WORK SHALL BE IN ACCORDANCE WITH ALL APPLICABLE LOCAL CODE REQUIREMENTS AND THE PROVISIONS OF NFPA-54 AND NFPA-58.
 3. THE CONTRACTOR SHALL SUPPLY ALL PERMITS AND LICENSES REQUIRED FOR THE WORK AND FOR ALL INSPECTIONS REQUIRED.
 4. PIPE 3" AND SMALLER SHALL BE SCHEDULE 40 STEEL WITH THREADED MALLEABLE FITTINGS.
 5. VALVES SHALL BE GAS COCKS MANUFACTURED BY NIBCO.
 6. ALL GAS PIPING LOCATED UNDER THE FLOOR SLABS SHALL BE INSTALLED IN CONDUIT OR AS REQUIRED BY CODE.
 7. ALL PIPING EXPOSED TO THE OUTDOORS OR RUN IN UNCONDITIONED SPACES SHALL BE PAINTED WITH TWO COATS OF BIAMEL.

- SHEET KEYNOTES:**
1. SEE SITE UTILITY DRAWINGS FOR CONTINUATION OF BUILDING DOMESTIC WATER MAIN LINE AND NATURAL GAS SUPPLY LINE. COORDINATE EXACT LOCATION OF WATER MAIN WITH ELECTRICAL SERVICE.
 2. 2" DOUBLE-CHECK BACKFLOW PREVENTION DEVICE FOR NON-POTABLE WATER SUPPLY TO CAR WASH EQUIPMENT.
 3. 2" NFW - SEE SHEET P204 FOR CONTINUATION.
 4. CONNECT GAS TO APPLIANCES INLET WITH LISTED PLUG ISOLATION VALVE, 6" MIN. DIRT LEG. PIPE TRANSITION (AS REQUIRED) AND LISTED APPLIANCE CONNECTOR USE.




Project
Sam's Mart
E. Independence Blvd.
Indian Trail, NC 28097


Owner
Sam's Mart
2823 South Tryon Street
Charlotte, North Carolina
tel 704.373.0068

Site 280
7733 Council Place
Suite 200
Matthews, NC 28105


MECHANICAL ELECTRICAL PLUMBING



Wayne King, II
Professional Engineer
No. 35, 2017
FIRM NUMBER = C-2130



WWW.LDILINE.COM

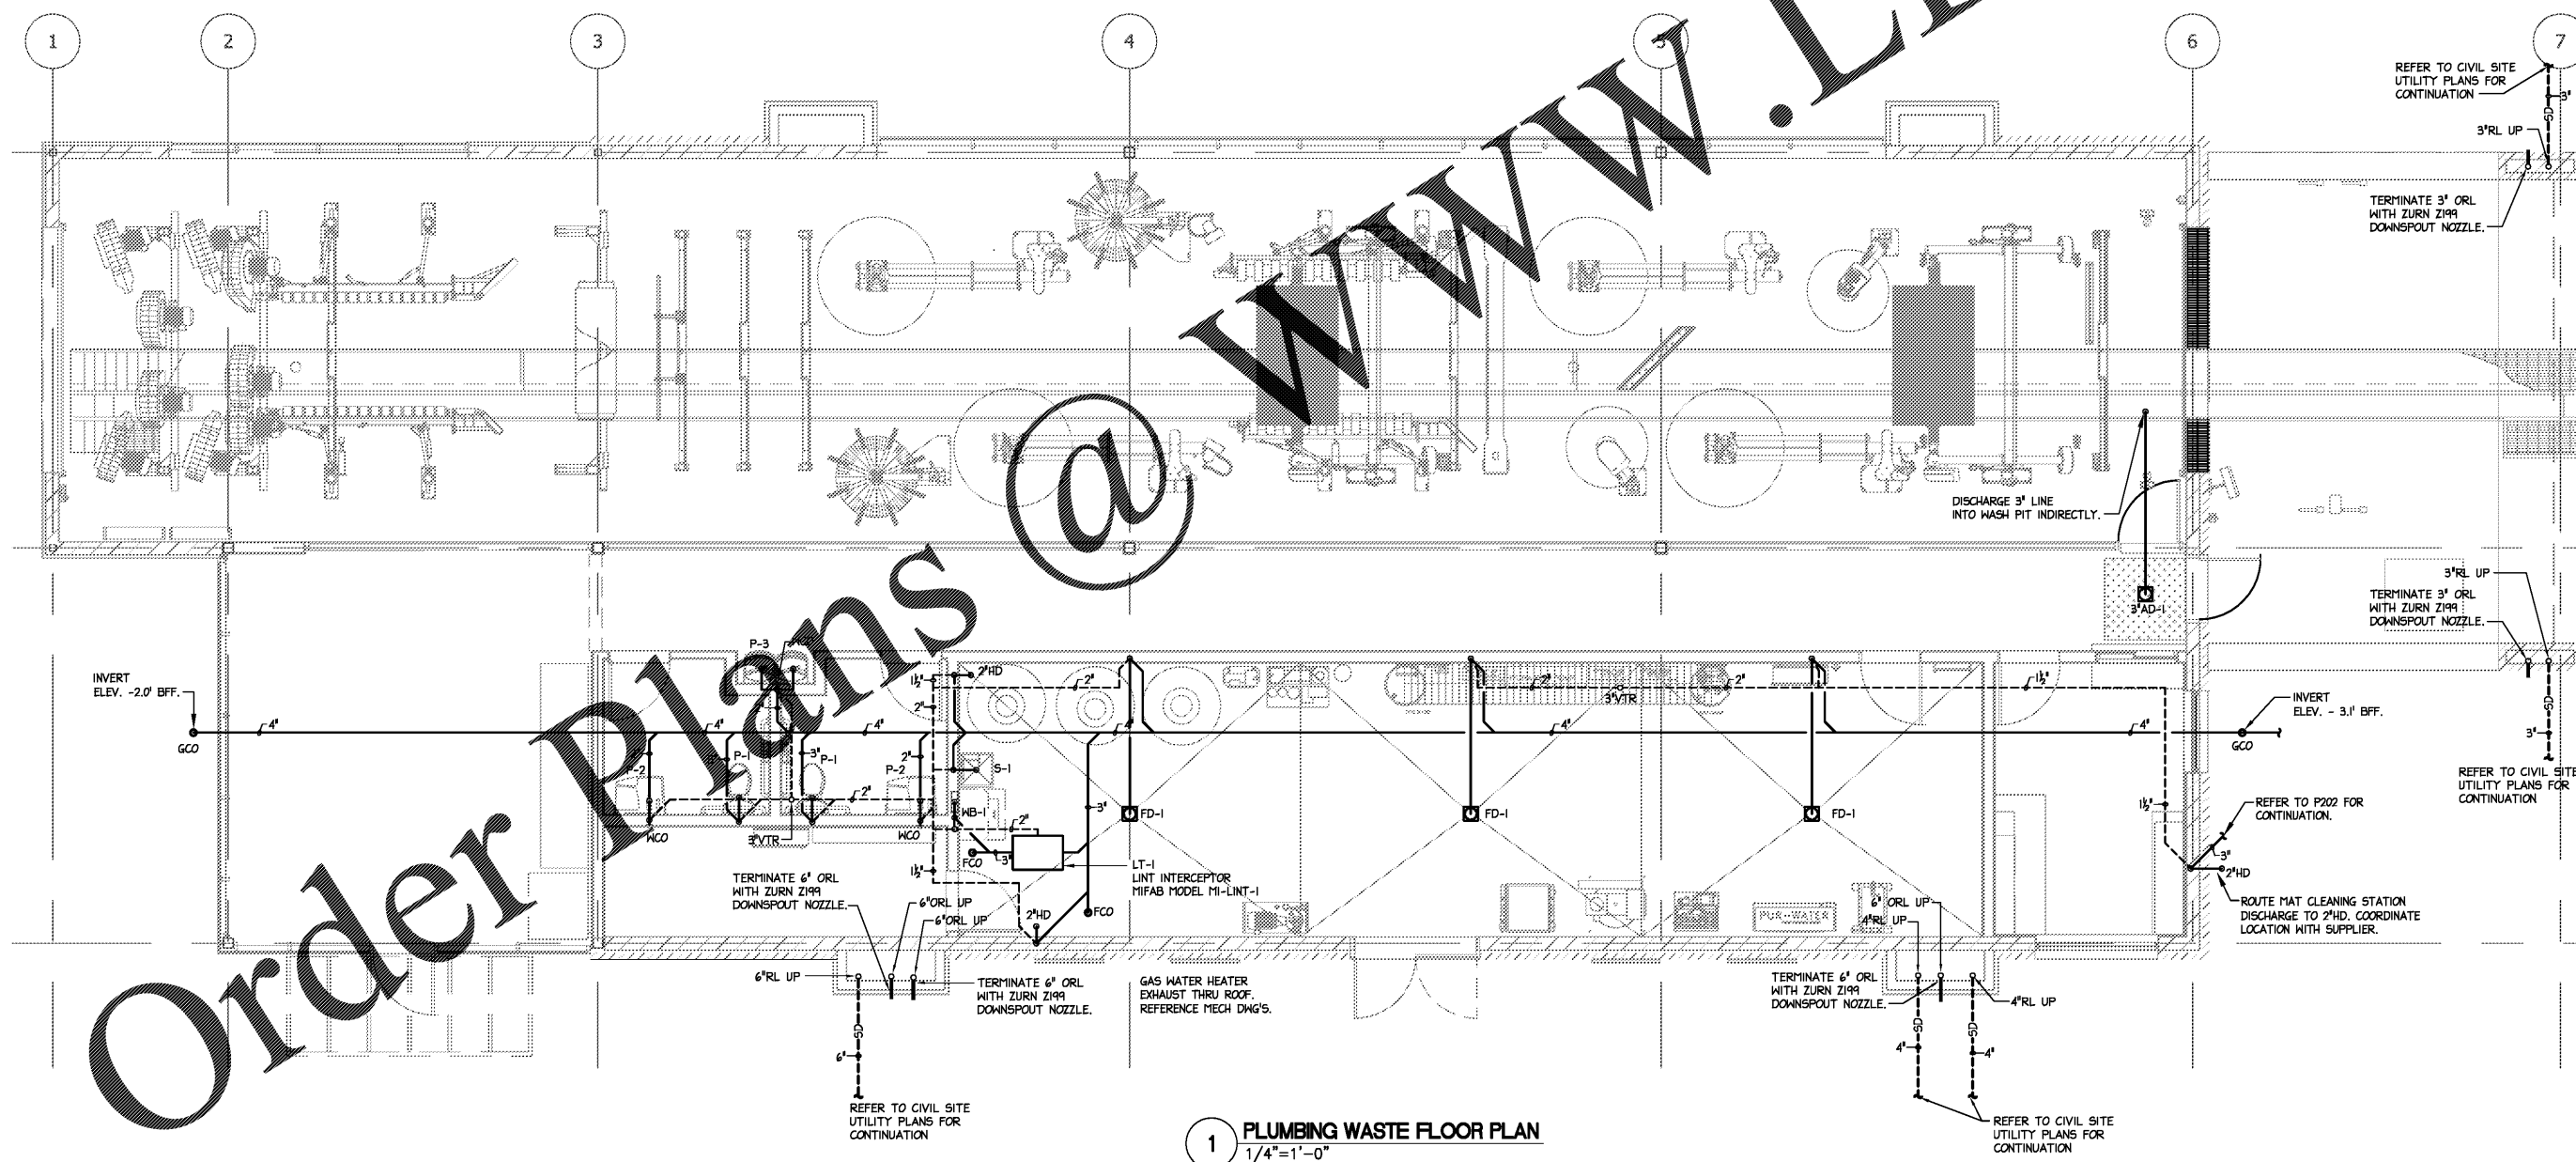

R V ARCHITECTURE, P.A.

124 Floyd Smith Dr
Suite 375
Charlotte, NC 28262
Tel - 704 - 688-7500

7301 Rivers Avenue
Suite 188
North Charleston, SC 29406
Tel - 843 - 531-6848

www.R4architecture.com

Revision	Date

Drawn By	Saber
Checked By	Saber
Issue Date	07-05-17
Project No	160345

Sheet Title
PLUMBING
WASTE AND
VENT PLAN

Sheet Number
P201

1 PLUMBING WASTE FLOOR PLAN
1/4"=1'-0"