



ALL STRUCTURAL AND ELECTRICAL DETAILS ARE THE PROPERTY OF R4 ARCHITECTURE, P.A. ANY REPRODUCTION IS STRICTLY PROHIBITED. PERMISSION IS GRANTED TO PRINT FOR PERSONAL USE ONLY.

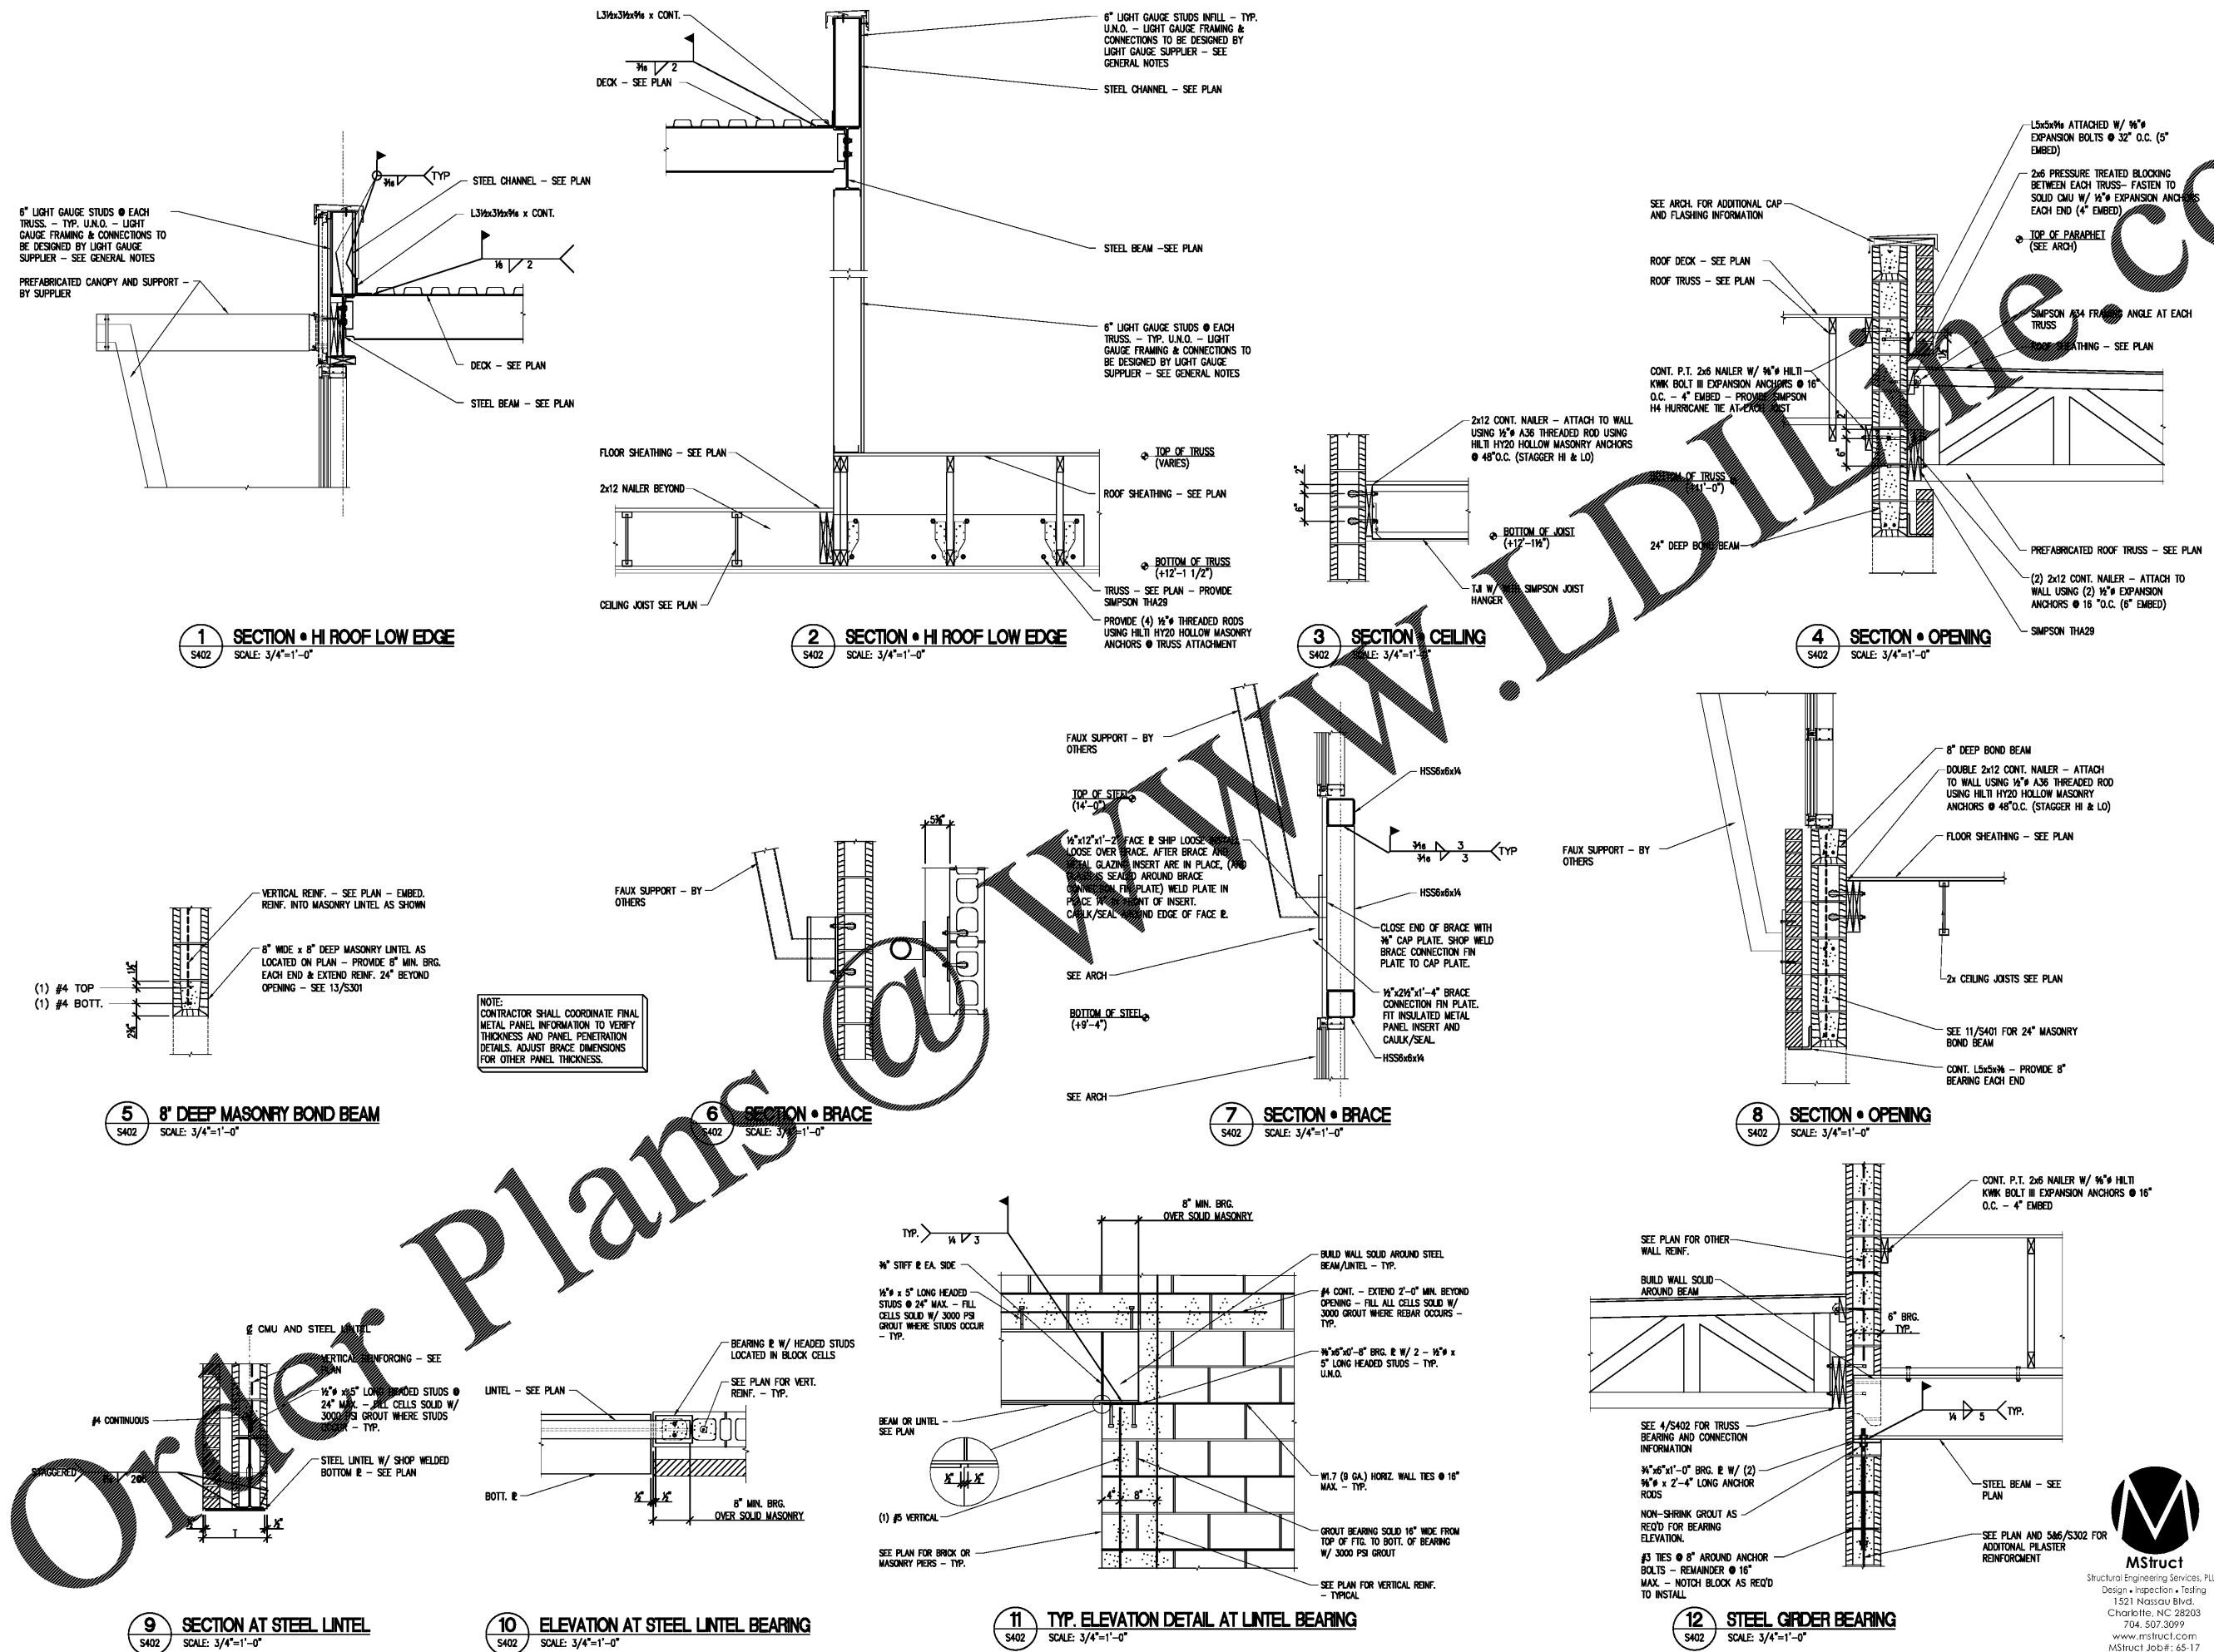

NOTE: CONTRACTOR SHALL COORDINATE FINAL METAL PANEL INFORMATION TO VERIFY THICKNESS AND PANEL PENETRATION DETAILS. ADJUST BRACE DIMENSIONS FOR OTHER PANEL THICKNESS.

Project
 Sam's Xpress Car Wash
 4965 University Parkway
 Winston-Salem, NC 27106

Owner
 Sam's M...
 93 Church Place
 Suite 200
 Matthews, NC 28105

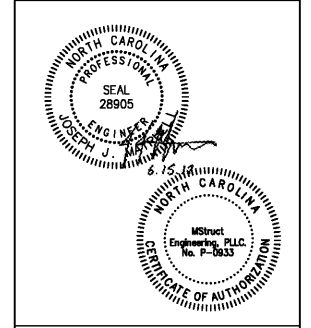

R4 ARCHITECTURE, P.A.

124 Floyd Smith Dr
 Suite 375
 Charlotte, NC 28262
 Tel - 704 - 688-7500

7301 Rivers Avenue
 Suite 188
 North Charleston, SC 29406
 Tel - 843 - 531-6848

www.R4architecture.com

Revision	Date

Revision	Date

Drawn By PJW
Checked By JJM
Issue Date 06.15.17
Project No 170382

Sheet Title

FRAMING SECTIONS AND DETAILS

Sheet Number

S402

