
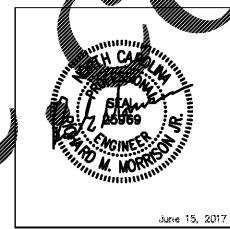


ALL DESIGN, DRAWINGS AND SPECIFICATIONS SHOWN ON THIS SHEET ARE THE PROPERTY OF R4 ARCHITECTURE, P.A. ANY UNAUTHORIZED USE OR REPRODUCTION IS SUBJECT TO LEGAL PROSECUTION. POSSESSION IN ANY FORM CONSTITUTES ACCEPTANCE OF THESE CONDITIONS. COPYRIGHT 2017




SABER ENGINEERING
 2923 South Tryon Street, Suite 200
 Charlotte, North Carolina 28217
 tel 704.373.0068
 MECHANICAL ELECTRICAL PLUMBING



June 15, 2017

Project
 Sam's Xpress Car Wash
 4965 University Parkway
 Winston-Salem, NC 27106

Owner
 Sam's Mart
 7900 Courthouse Place
 Suite 200
 Matthews, NC 28105

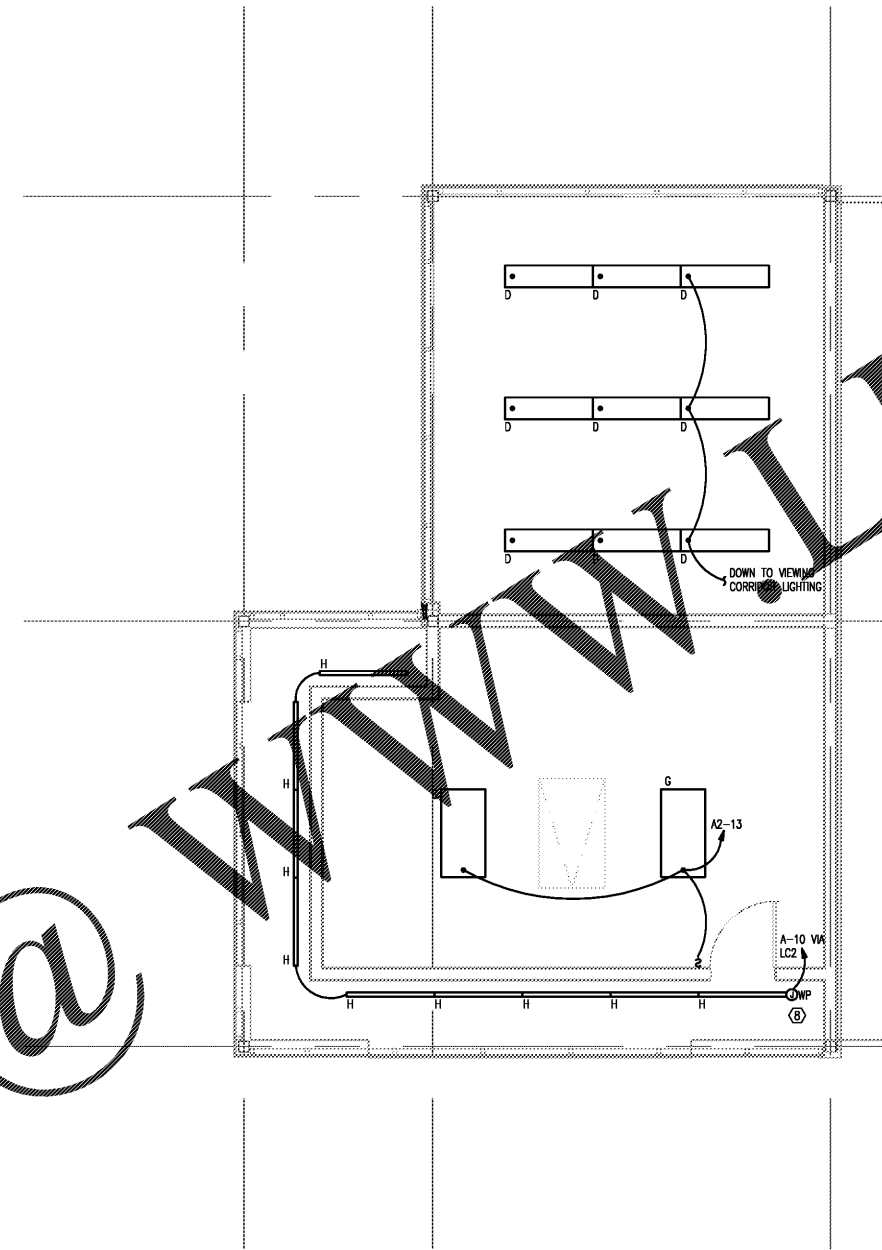

1 MEZZANINE LIGHTING PLAN
 1/4"=1'-0"

R4
 ARCHITECTURE, P.A.

124 Floyd Smith Dr
 Suite 375
 Charlotte, NC 28262
 Tel - 704 - 688-7500

7301 Rivers Avenue
 Suite 188
 North Charleston, SC 29406
 Tel - 843 - 531-6848

www.R4architecture.com

Revision	Date
----------	------

Drawn By	SABER
Checked By	SABER
Issue Date	06.15.17
Project No	170382

Sheet Title
 ELECTRICAL
 MEZZANINE
 LIGHTING PLAN

Sheet Number
E203

Order Plans @