

ALL DESIGNS, DRAWINGS AND SPECIFICATIONS DEPICTED ON THIS SHEET ARE THE PROPERTY OF R4 ARCHITECTURE, P.A. ANY UNAUTHORIZED USE OR REPRODUCTION IS SUBJECT TO LEGAL PROSECUTION. POSSESSION IN ANY FORM CONSTITUTES ACCEPTANCE OF THESE CONDITIONS. COPYRIGHT 2017

Project
 Sam's Xpress Car Wash
 4965 University Parkway
 Winston-Salem, NC 27106




Owner
 Sam's Mart
 7900 Courthouse Place
 Suite 200
 Matthews, NC 28105

SABER ENGINEERING
 2923 South Tryon Street, Suite 282
 Charlotte, North Carolina 28217
 tel 704.373.0068

MECHANICAL ELECTRICAL PLUMBING


SEAL CLAY
 1000000000
 H. WAYNE KING, II
 ENGINEER

June 15, 2017

- GAS PIPING NOTES:**
1. WORK TO INCLUDE PIPING FROM GAS METER TO ALL GAS FIRED EQUIPMENT. FINAL CONNECTION TO ROOFTOP UNITS BY MECHANICAL CONTRACTOR. MECHANICAL CONTRACTOR TO PROVIDE SHUT-OFF VALVE, DIRT TRAP, AND PRESSURE REGULATOR AT EACH PIECE OF EQUIPMENT.
 2. ALL WORK SHALL BE IN ACCORDANCE WITH ALL APPLICABLE LOCAL CODE REQUIREMENTS AND THE PROVISIONS OF NFPA-54 AND NFPA-58.
 3. THE CONTRACTOR SHALL SUPPLY ALL PERMITS AND LICENSES REQUIRED FOR THE WORK AND FOR ALL INSPECTIONS REQUIRED.
 4. PIPE 3" AND SMALLER SHALL BE SCHEDULE 40 STEEL WITH THREADED MALLEABLE FITTINGS.
 5. VALVES SHALL BE GAS COCKS MANUFACTURED BY NIBCO.
 6. ALL GAS PIPING LOCATED UNDER THE FLOOR SLABS SHALL BE INSTALLED IN CONDUIT OR AS REQUIRED BY CODE.
 7. ALL PIPING EXPOSED TO THE OUTDOORS OR RUN IN UNCONDITIONED SPACES SHALL BE PAINTED WITH TWO COATS OF ENAMEL.

- SHEET KEYED NOTES**
- ① SEE SITE UTILITY DRAWINGS FOR CONTINUATION OF BUILDING DOMESTIC WATER MAIN LINE AND NATURAL GAS SUPPLY LINE. COORDINATE EXACT LOCATION OF WATER MAIN WITH ELECTRICAL SERVICE.
 - ② 2" DOUBLE-CHECK BACKFLOW PREVENTION DEVICE FOR NON-POTABLE WATER SUPPLY TO CAR WASH EQUIPMENT.
 - ③ 2" NPW - SEE SHEET P204 FOR CONTINUATION.
 - ④ CONNECT GAS TO APPLIANCES INLET WITH LISTED PLUG ISOLATION VALVE, 6" MIN. DIRT LEG, PIPE TRANSITION (AS REQUIRED) AND LISTED APPLIANCE CONNECTOR HOSE.

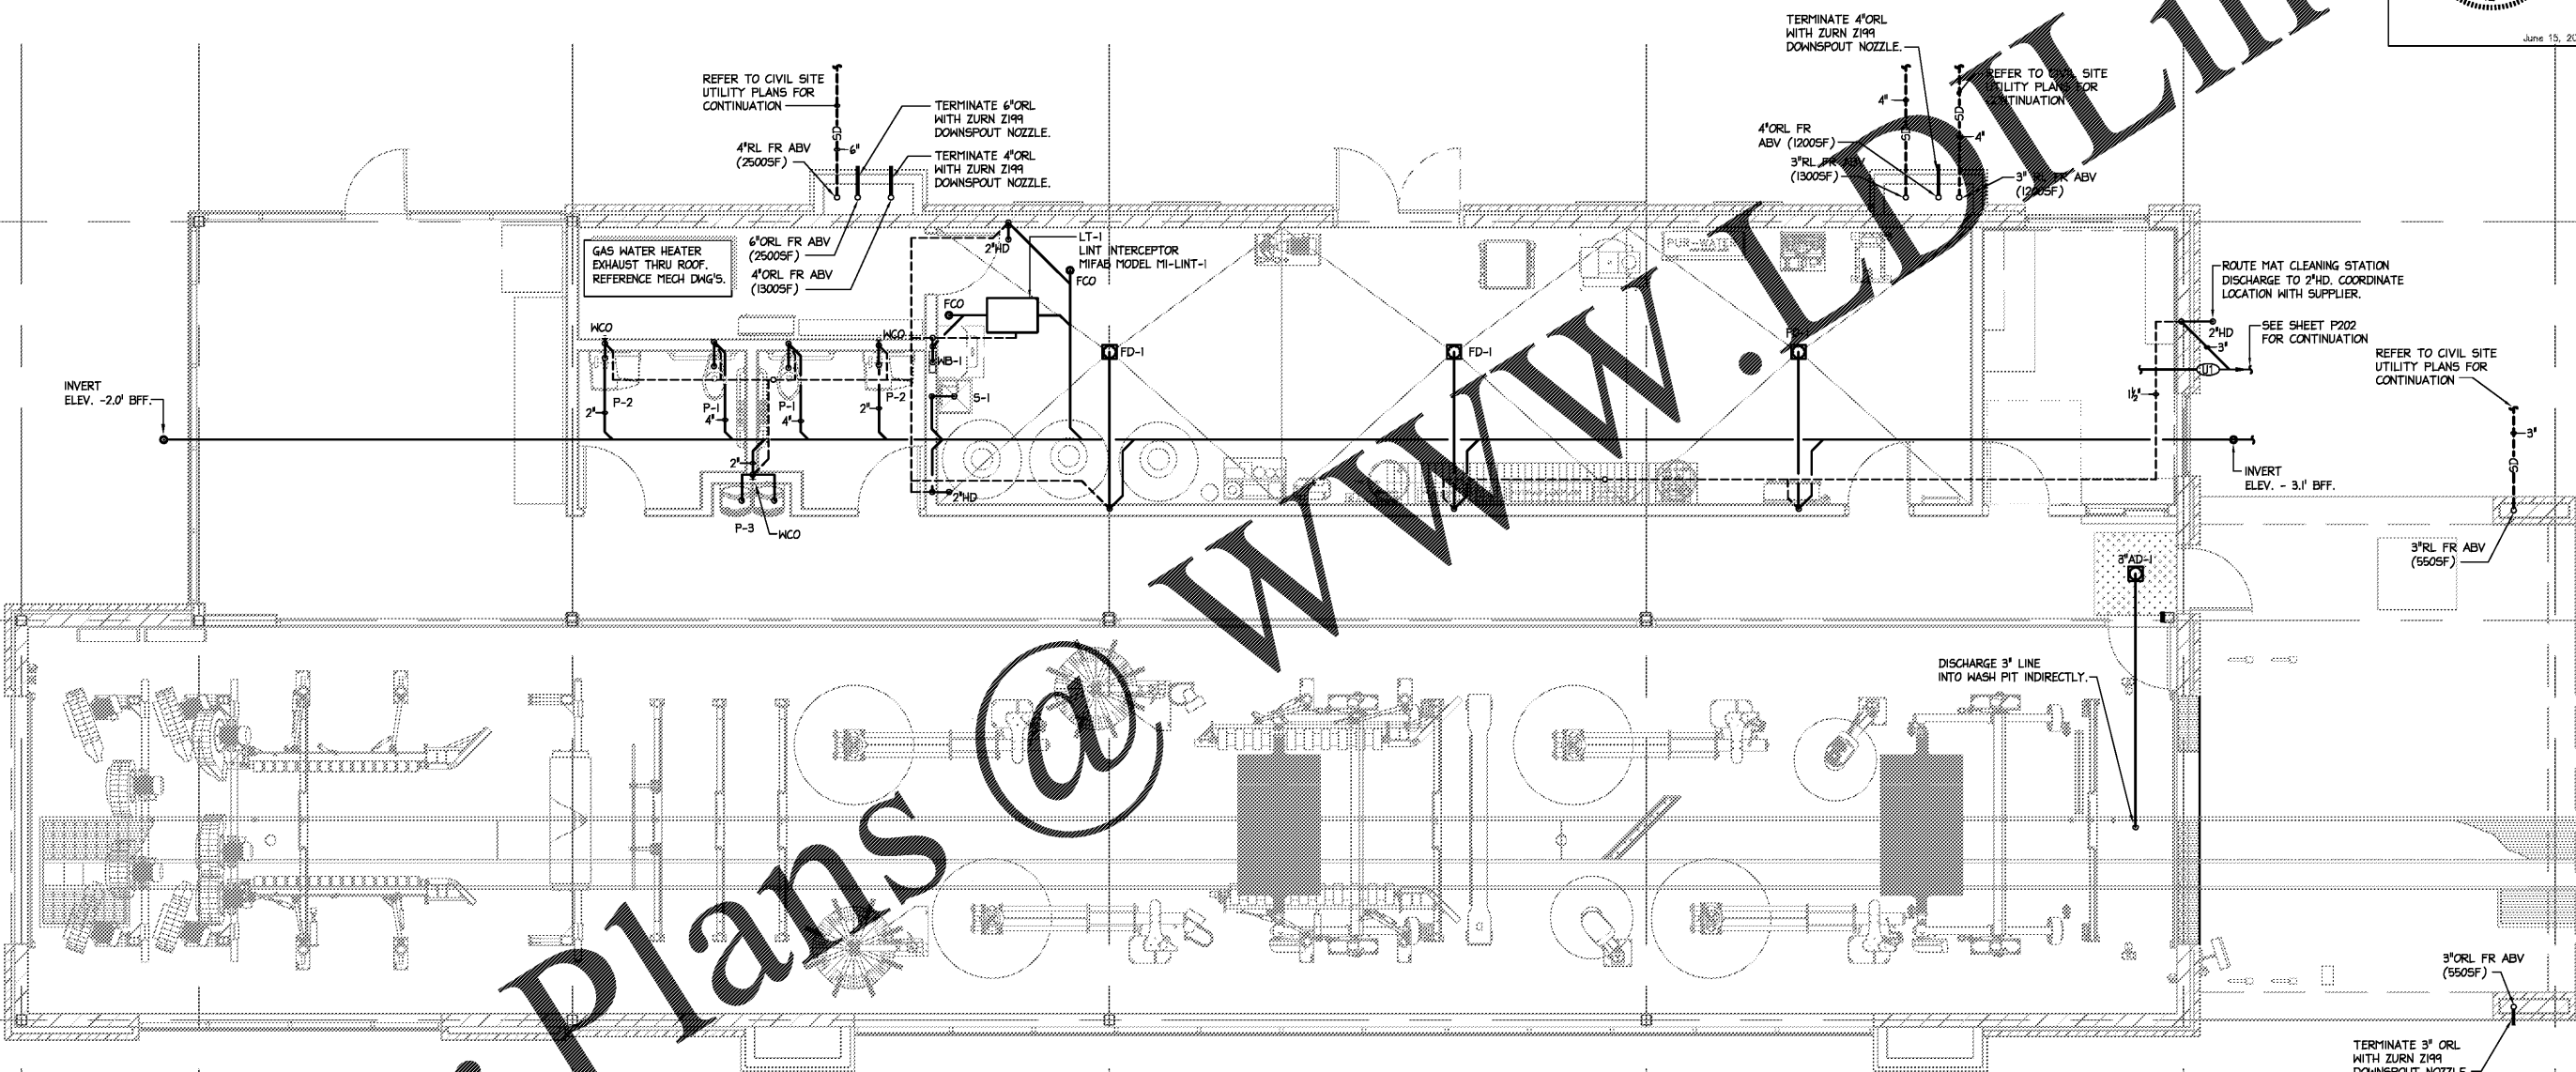

1 PLUMBING WASTE FLOOR PLAN
 1/4" = 1'-0"
 NOTE: UNLESS OTHERWISE SPECIFIED, 1/4" PER FOOT SLOPE.

R4 ARCHITECTURE, P.A.
 124 Floyd Smith Dr
 Suite 375
 Charlotte, NC 28262
 Tel - 704 - 688-7500

7301 Rivers Avenue
 Suite 188
 North Charleston, SC 29406
 Tel - 843 - 531-6848

www.R4architecture.com

Revision	Date

Drawn By	SABER
Checked By	SABER
Issue Date	06.15.17
Project No	170382

Sheet Title
 PLUMBING
 WASTE AND
 VENT PLAN

Sheet Number
P201

Order Plans