


ALL DESIGNS, DRAWINGS AND SPECIFICATIONS DEPICTED ON THIS SHEET ARE THE PROPERTY OF R4 ARCHITECTURE, P.A. ANY UNAUTHORIZED USE OR REPRODUCTION IS SUBJECT TO LEGAL PROSECUTION. PERMISSION IN ANY FORM CONSTITUTES ACCEPTANCE OF THESE CONDITIONS. COPYRIGHT 2017



Project
Sam's Xpress Car Wash
4965 University Parkway
Winston-Salem, NC 27106

Owner
Sam's Mart
7900 Courthouse Place
Suite 200
Matthews, NC 28105

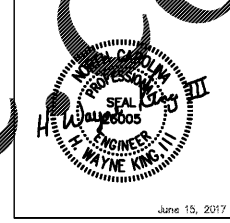

124 Floyd Smith Dr
Suite 375
Charlotte, NC 28262
Tel - 704 - 688-7500

7301 Rivers Avenue
Suite 188
North Charleston, SC 29406
Tel - 843 - 531-6848


www.R4architecture.com

Revision **Date**

Drawn By SABER
Checked By SABER
Issue Date 06.15.17
Project No 170382


Sheet Title
WASTE AND RECLAIM
UNDERGROUND
PIPING

Sheet Number
P202

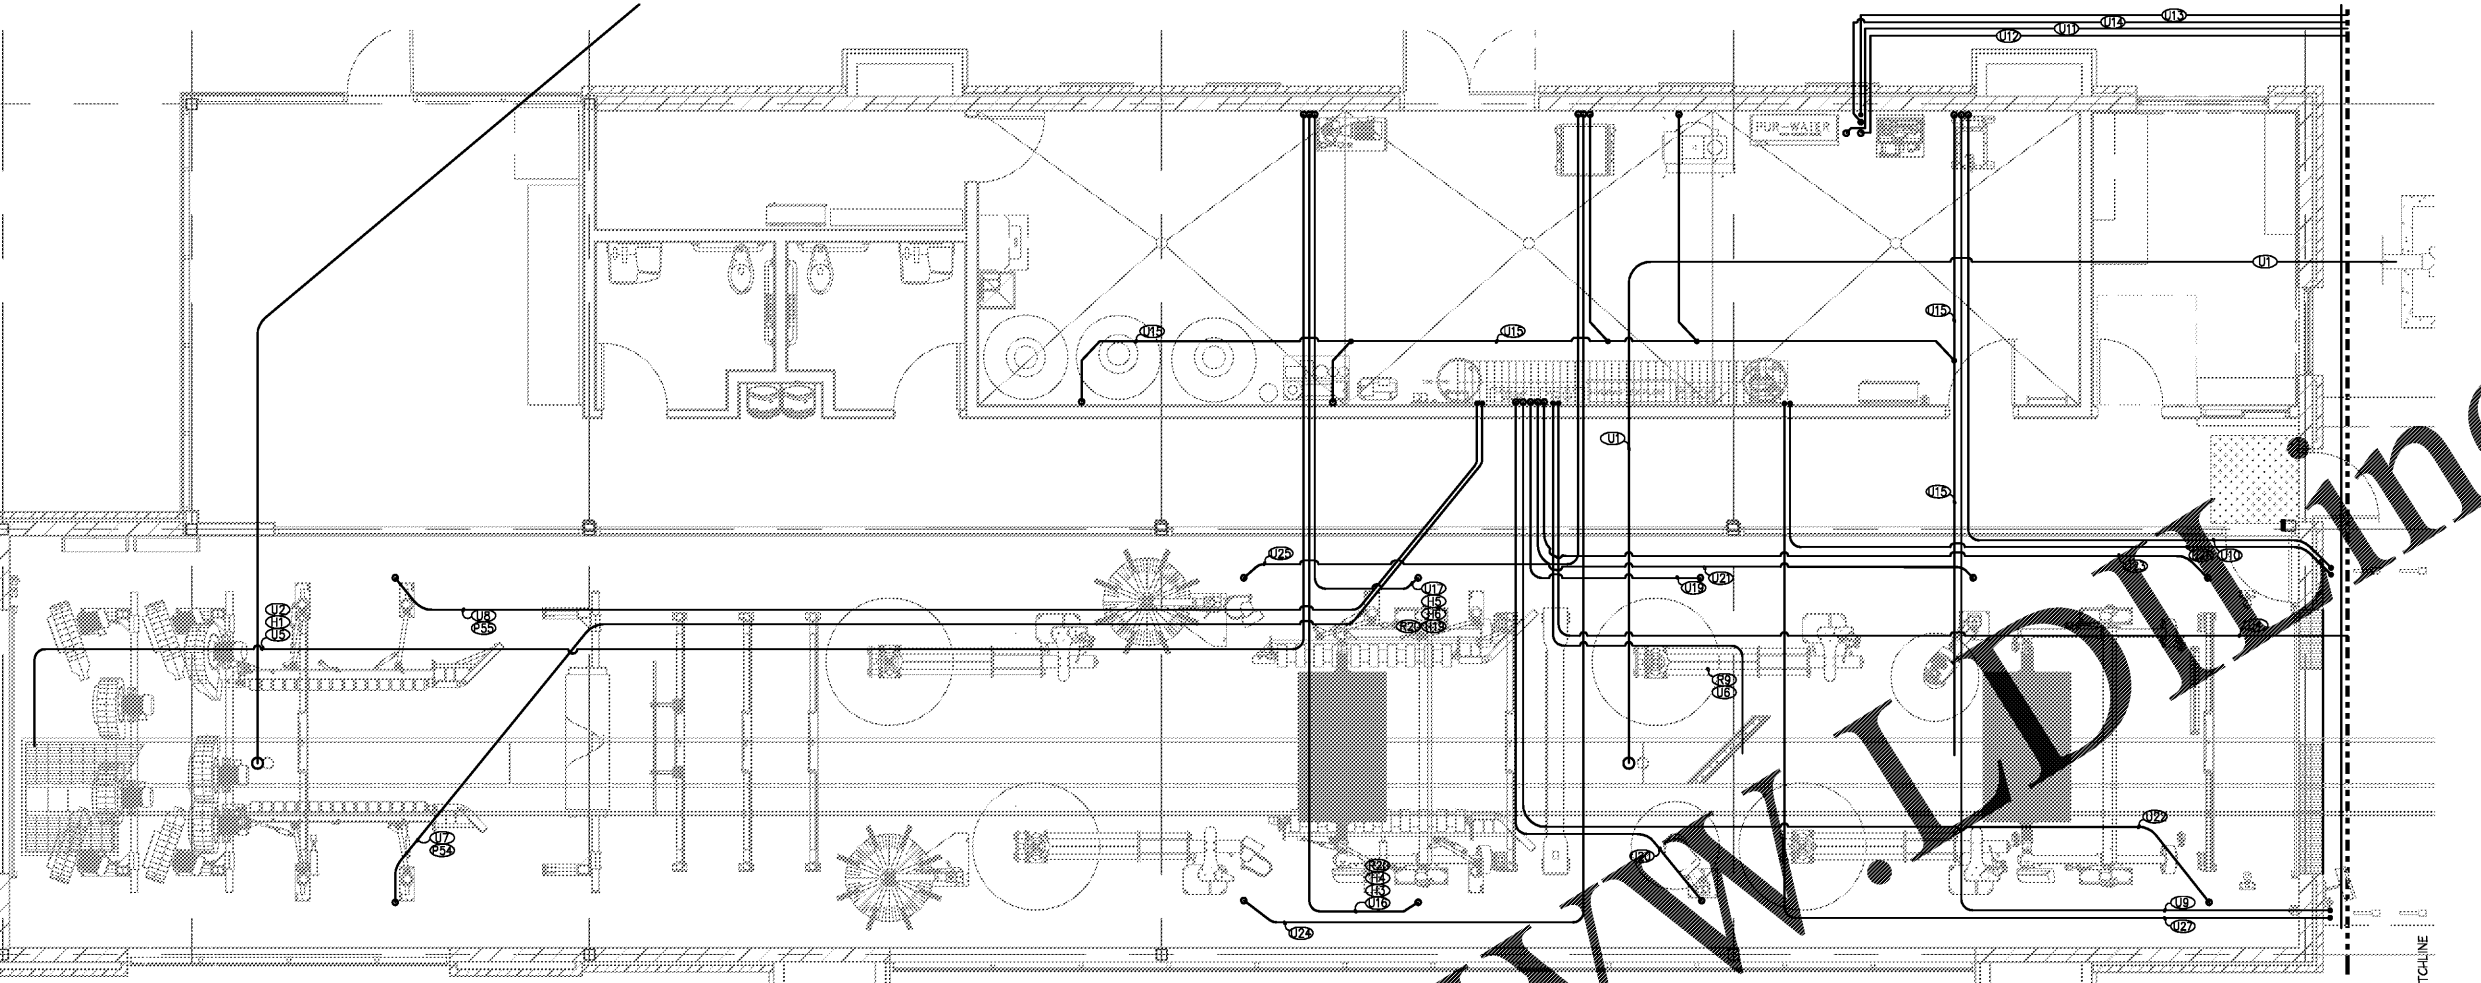

1 WASTE AND RECLAIM UNDERGROUND PIPING
1/4"=1'-0"
ALL PIPING IS 3" UNLESS NOTED OTHERWISE.

SEE SHEET P201
FOR CONTINUATION

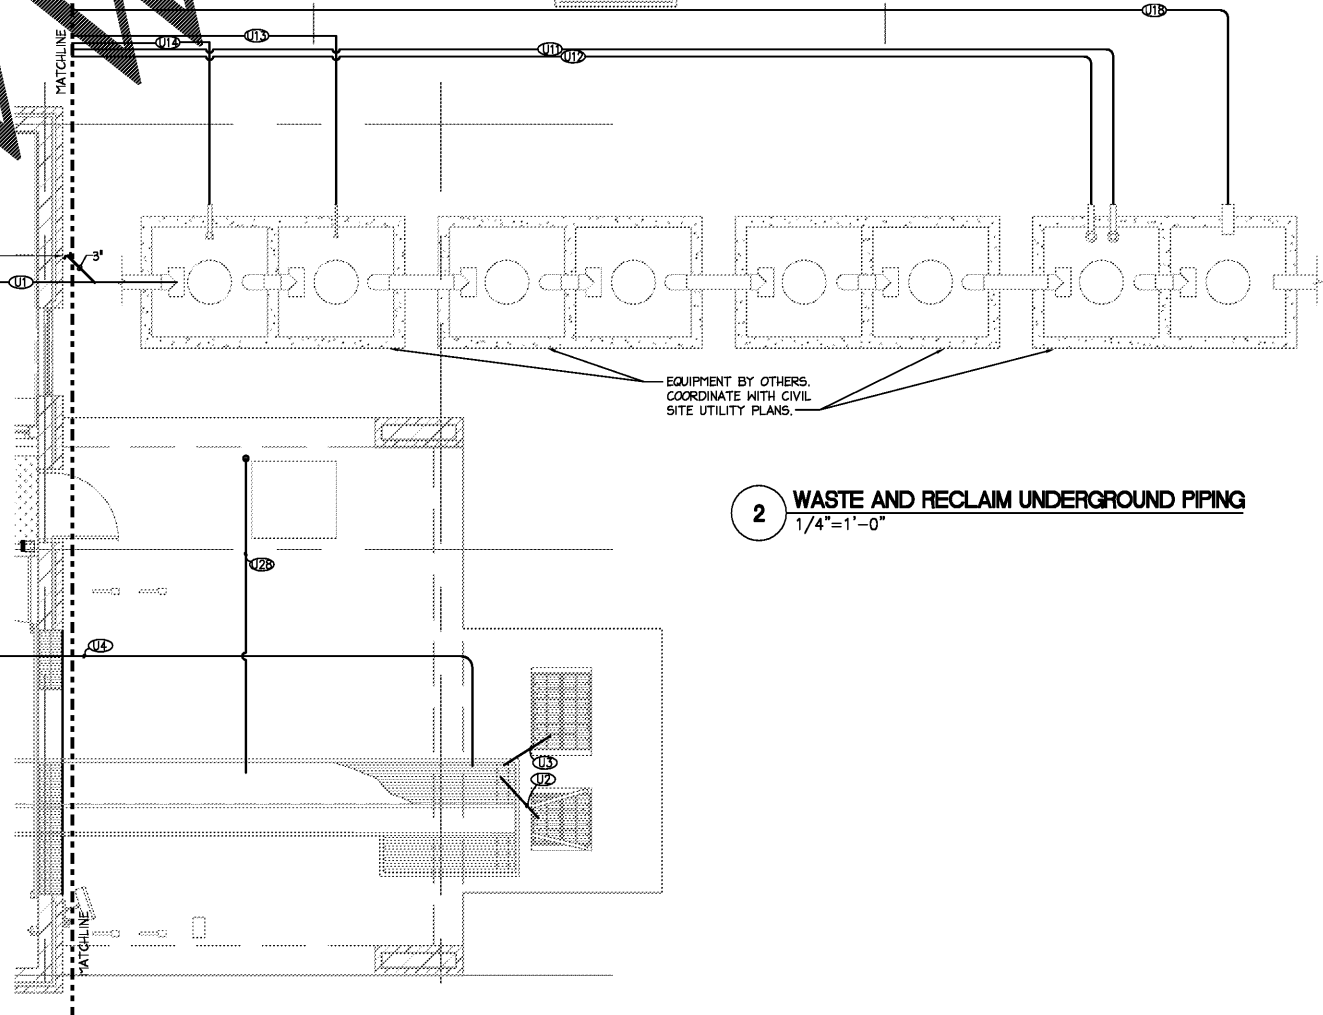

EQUIPMENT BY OTHERS.
COORDINATE WITH CIVIL
SITE UTILITY PLANS.

2 WASTE AND RECLAIM UNDERGROUND PIPING
1/4"=1'-0"

- TAGGED NOTES - THIS SHEET**
- 1 SEE SITE UTILITY PLANS FOR CONTINUATION OF RECLAIM TANK DISCHARGE LINE.
 - 2 COORDINATE INSTALLATION WITH SPECIFIC CAR WASH EQUIPMENT AND PIPING REQUIREMENTS AS DIRECTED BY THE OWNER'S REPRESENTATIVE.
 - 3 ROUTE CONDUIT PIPING IN CHASE OVERHEAD. COORDINATE ROUTING AND TERMINATION REQUIREMENTS AS DIRECTED BY THE OWNER'S REPRESENTATIVE.

- GENERAL NOTES - THIS SHEET**
- 1. ALL STUB UPS TO BE 12" ABOVE FINISHED FLOOR, WITH UNGLUED 90 DEGREE ELBOW AT TOP.
 - 2. ALL UNDERGROUND PIPES AND CONDUITS TO BE PROVIDED BY GENERAL CONTRACTOR.
 - 3. CAP AND PRESSURE TEST ALL DISCHARGE LINES FOR 24 HOURS AT 30PSI.
 - 4. ALL STUB OUTS IN THE RECLAIM TANK TO BE A MINIMUM 6" ABOVE WATER LEVEL. BRING PIPES DOWN TO BE ABOVE THE BOTTOM OF THE TANK.
 - 5. DRAIN FROM RECLAIM TANK TO SEWER SHOULD FOLLOW STATE AND LOCAL CODES.
 - 6. IF NO SEWER OIL SEPARATOR IS AVAILABLE, DRAIN TO FIRST STAGE OF RECLAIM TANK.
 - 7. REFER TO BEHANGER DRAWINGS FOR EQUIPMENT SCHEDULES AND DIMENSIONS.

- NOTE TO CONTRACTOR**
- 1. THE PLUMBING CONTRACTOR SHALL COORDINATE WITH THE EQUIPMENT DRAWINGS FOR INSTALLATION OF ALL PIPING RELATING TO ALL EQUIPMENT AND REQUIRED CONNECTIONS PER EQUIPMENT SUPPLIER/OWNER LAYOUT. ALL WORK SHALL BE IN ACCORDANCE WITH STATE AND LOCAL CODES.
 - 2. THE PLUMBING CONTRACTOR SHALL COORDINATE ALL UTILITIES AND LINES RELATING TO CAR WASHING EQUIPMENT WITH THE CIVIL ENGINEER AND THE CIVIL DRAWINGS.