



ALL DESIGNS, DRAWINGS AND SPECIFICATIONS DEPICTED ON THIS SHEET ARE THE PROPERTY OF R4 ARCHITECTURE, P.A. ANY UNAUTHORIZED USE OR REPRODUCTION IS SUBJECT TO LEGAL PROSECUTION. POSSESSION IN ANY FORM CONSTITUTES ACCEPTANCE OF THESE CONDITIONS. COPYRIGHT 2017

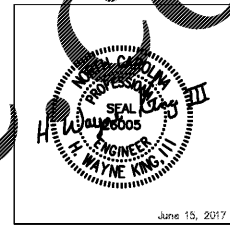


Project
Sam's Xpress Car Wash
4965 University Parkway
Winston-Salem, NC 27106
Owner
Sam's Mart
7900 Courthouse Place
Suite 200
Matthews, NC 28105

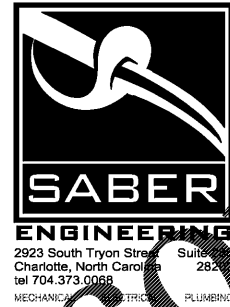

- SHEET KEYED NOTES**
- 2" NON-POTABLE WATER (NPH) WATER LINE. SEE SHEET P200 FOR CONTINUATION.
 - REFER TO RISER DIAGRAM ON SHEET P301 FOR ADDITIONAL INFORMATION.
 - 1" TEE WITH ISO VALVE AS PROVISION FOR FUTURE IN-LINE BOOSTER PUMP INSTALLATION.
 - 2" NORMALLY OPEN VALVE.
 - REFER TO SHEET P301 FOR CONTINUATION.
 - 4" PVC DWV PIPING CONDUIT FOR WASH TUBING RUN ABOVE CEILING WITH DROPS THROUGH CEILING WHEN SHOWN. COORDINATE FINAL DROP LOCATIONS WITH CAR WASH EQUIPMENT INSTALLER. RUN CONDUITS USING LONG SHEEP ELBOWS OR TWO 45° LONG RADIUS FITTINGS.

- GENERAL NOTES:**
- COORDINATE WITH CAR WASH EQUIPMENT FOR EQUIPMENT CONNECTION REQUIREMENTS.
 - ALL UNDERGROUND PIPES AND CONDUITS TO BE PROVIDED BY GENERAL CONTRACTOR.
 - COORDINATE ELEVATION AND LOCATION OF ALL PIPING WITH CAR WASH EQUIPMENT REPRESENTATIVE.

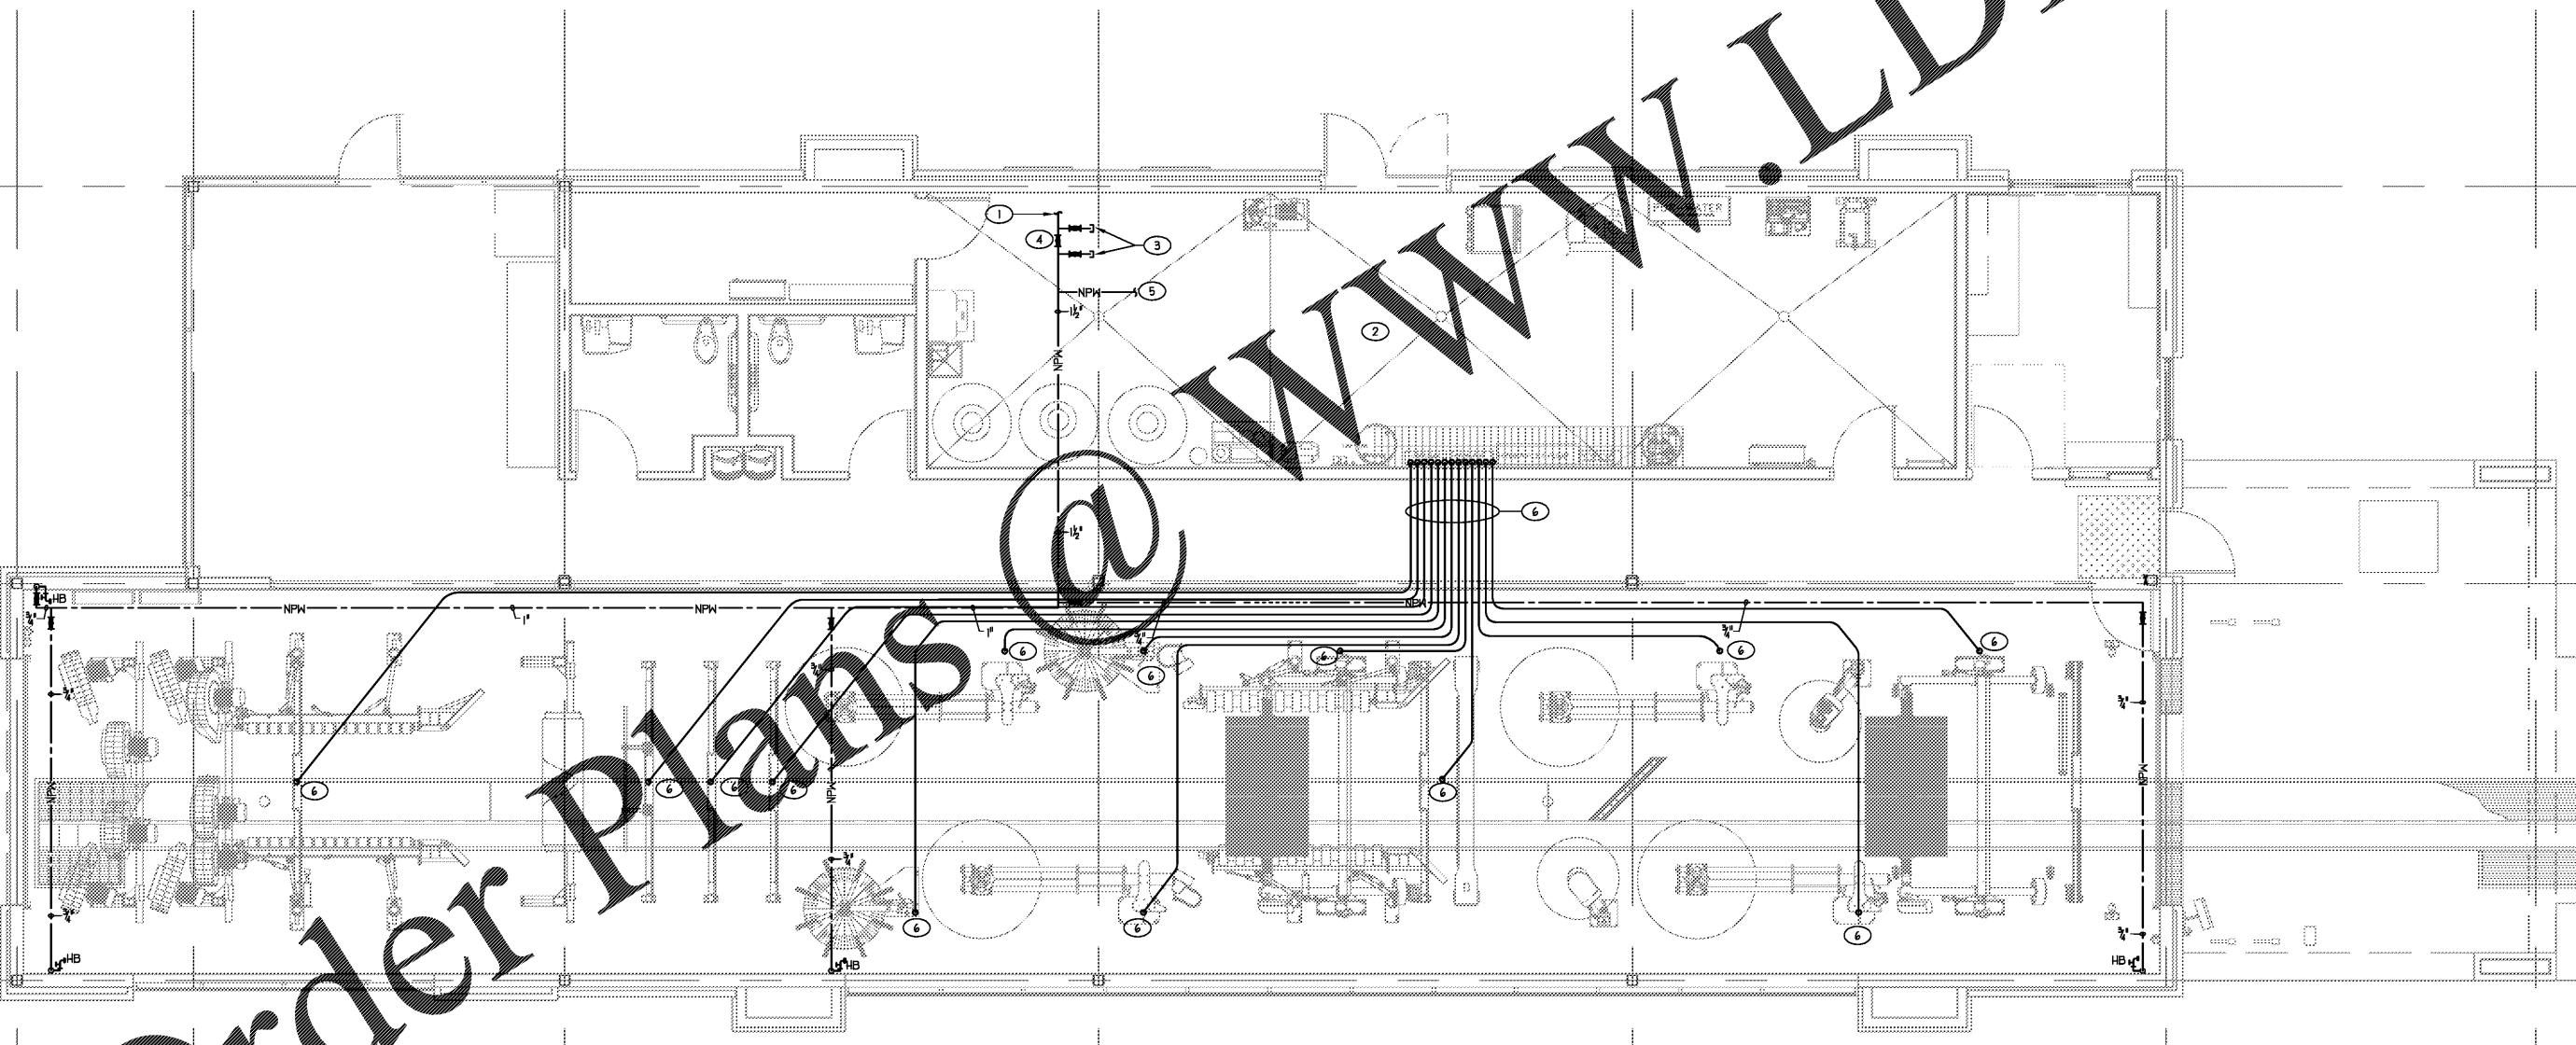

1 OVERHEAD PIPING PLAN
1/4" = 1' 0"

- NOTE TO CONTRACTOR**
- THE PLUMBING CONTRACTOR SHALL COORDINATE WITH THE EQUIPMENT DRAWINGS FOR INSTALLATION OF ALL PIPING RELATING TO ALL EQUIPMENT AND REQUIRED CONNECTIONS PER EQUIPMENT SUPPLIER/OWNER LAYOUT. ALL WORK SHALL BE IN ACCORDANCE WITH STATE AND LOCAL CODES.
 - THE PLUMBING CONTRACTOR SHALL COORDINATE ALL UTILITIES AND LINES RELATING TO CAR WASHING EQUIPMENT WITH THE CIVIL ENGINEER AND THE CIVIL DRAWINGS.



124 Floyd Smith Dr
Suite 375
Charlotte, NC 28262
Tel - 704 - 688-7500

7301 Rivers Avenue
Suite 188
North Charleston, SC 29406
Tel - 843 - 531-6848

www.R4architecture.com

Revision	Date

Drawn By	SABER
Checked By	SABER
Issue Date	06.15.17
Project No	170382

Sheet Title
EQUIPMENT
OVERHEAD
PIPING PLAN

Sheet Number
P203